

GENERAL NOTES

1. THIS SET OF DRAWINGS, IN ADDITION TO THE EXHIBIT TECHNICAL SPECIFICATIONS, EXHIBIT DATABASE REPORTS, EXHIBIT GRAPHIC PACKAGE, AND EXHIBIT MATERIALS SAMPLES COMPRISE THE FINAL EXHIBIT DESIGN PACKAGE AND EXPRESS THE DESIGNERS' INTENT.
2. SHOP DRAWINGS BY FABRICATOR REQUIRED.
3. FABRICATOR TO VERIFY ALL DIMENSIONS ON SITE.
4. FABRICATOR TO ENSURE STABILITY, SAFETY, AND COMPLIANCE OF ALL EXHIBITS.
5. ALL EDGES AND CORNERS SHOULD BE EASED OR ROUNDED.
6. FABRICATOR TO CONFORM TO NATIONAL PARK SERVICE FABRICATION STANDARDS AVAILABLE FROM NPS-HARPERS FERRY CENTER.

FINISH SCHEDULE

ID	TYPE
F1	HIGH PRESSURE LAMINATE WITH GRAPHIC
F2	INKJET GRAPHIC ON ALUMINUM, CLEAR LAMINATE PROTECTIVE LAYER, WRAPPED EDGES, MOUNTED ON 1/2" SUBSTRATE, BLACK SIDES & BACK
F3	UV INKJET ON BALIHAI WALLCOVERING WITH MATTE CLEAR COAT
F4	PEELED LODGEPOLE PINE LOGS, FIRE-RETARDANT MATTE CLEAR FINISH
F5	CHERRY VENEER, MATTE POLYURETHANE CLEAR FINISH
F6	STEEL, POWDERCOAT SOLAR BLACK FLAT TIGER DRYLAC 44-80060
F7	PAINT: BENJAMIN MOORE 1183 "SEMINOLE BROWN"
F8	PAINT: BENJAMIN MOORE HC-68 "MIDDLEBURY BROWN"
F9	PAINT: BENJAMIN MOORE 2004-10 "DEEP ROSE"
F10	TEMPO VELCRO FABRIC, CHARCOAL #390A
F11	RICHLITE COUNTERTOP "GRAYS HARBOR"
F12	TEXTURAL CANVAS FOR HANGING HIDES
F13	CARPET TILE: INTERFACE CUBIC 6395 "CONSTRUCTION"

SHEET INDEX

ID	NAME
A01	COVER SHEET
A02	SITE PLAN
A03	EXHIBIT PLAN
A04	SCENE 01
A05	SCENE 02
A06	SCENE 02 DETAILS
A07	SCENE 03
A08	SCENE 03 DETAILS
A09	SCENE 04
A10	SCENE 04 DETAILS
A11	SCENE 05
A12	SCENE 06
A13	SCENE 06 DETAILS
A14	LIGHTING & ELECTRICAL PLAN

COVER SHEET

Title:

DD2

Revision #:

6/14/18

Date:

These documents have been created to show the designers' intent only. Written dimensions shall take precedence over scaled dimensions. Contractors shall verify and be responsible for all dimensions and conditions on the job, and this office must be notified of any variations from the dimensions and conditions shown by these drawings. Shop details must be submitted to this office before beginning fabrication. All ideas, designs, and arrangements indicated on these drawings are the property of EDX and are intended for the sole use of the client noted.

SITE PLAN

Title:

DD2

Revision #:

6/14/18


Date:

PIPESTONE NATIONAL MONUMENT
VISITOR CENTER EXHIBITS

These documents have been created to show the designers' intent only. Written dimensions shall take precedence over scaled dimensions. Contractors shall verify and be responsible for all dimensions and conditions on the job, and this office must be notified of any variations from the dimensions and conditions shown by these drawings. Shop details must be submitted to this office before beginning fabrication. All ideas, designs, and arrangements indicated on these drawings are the property of EDX and are intended for the sole use of the client noted.

A02

SHEET 2 OF 14

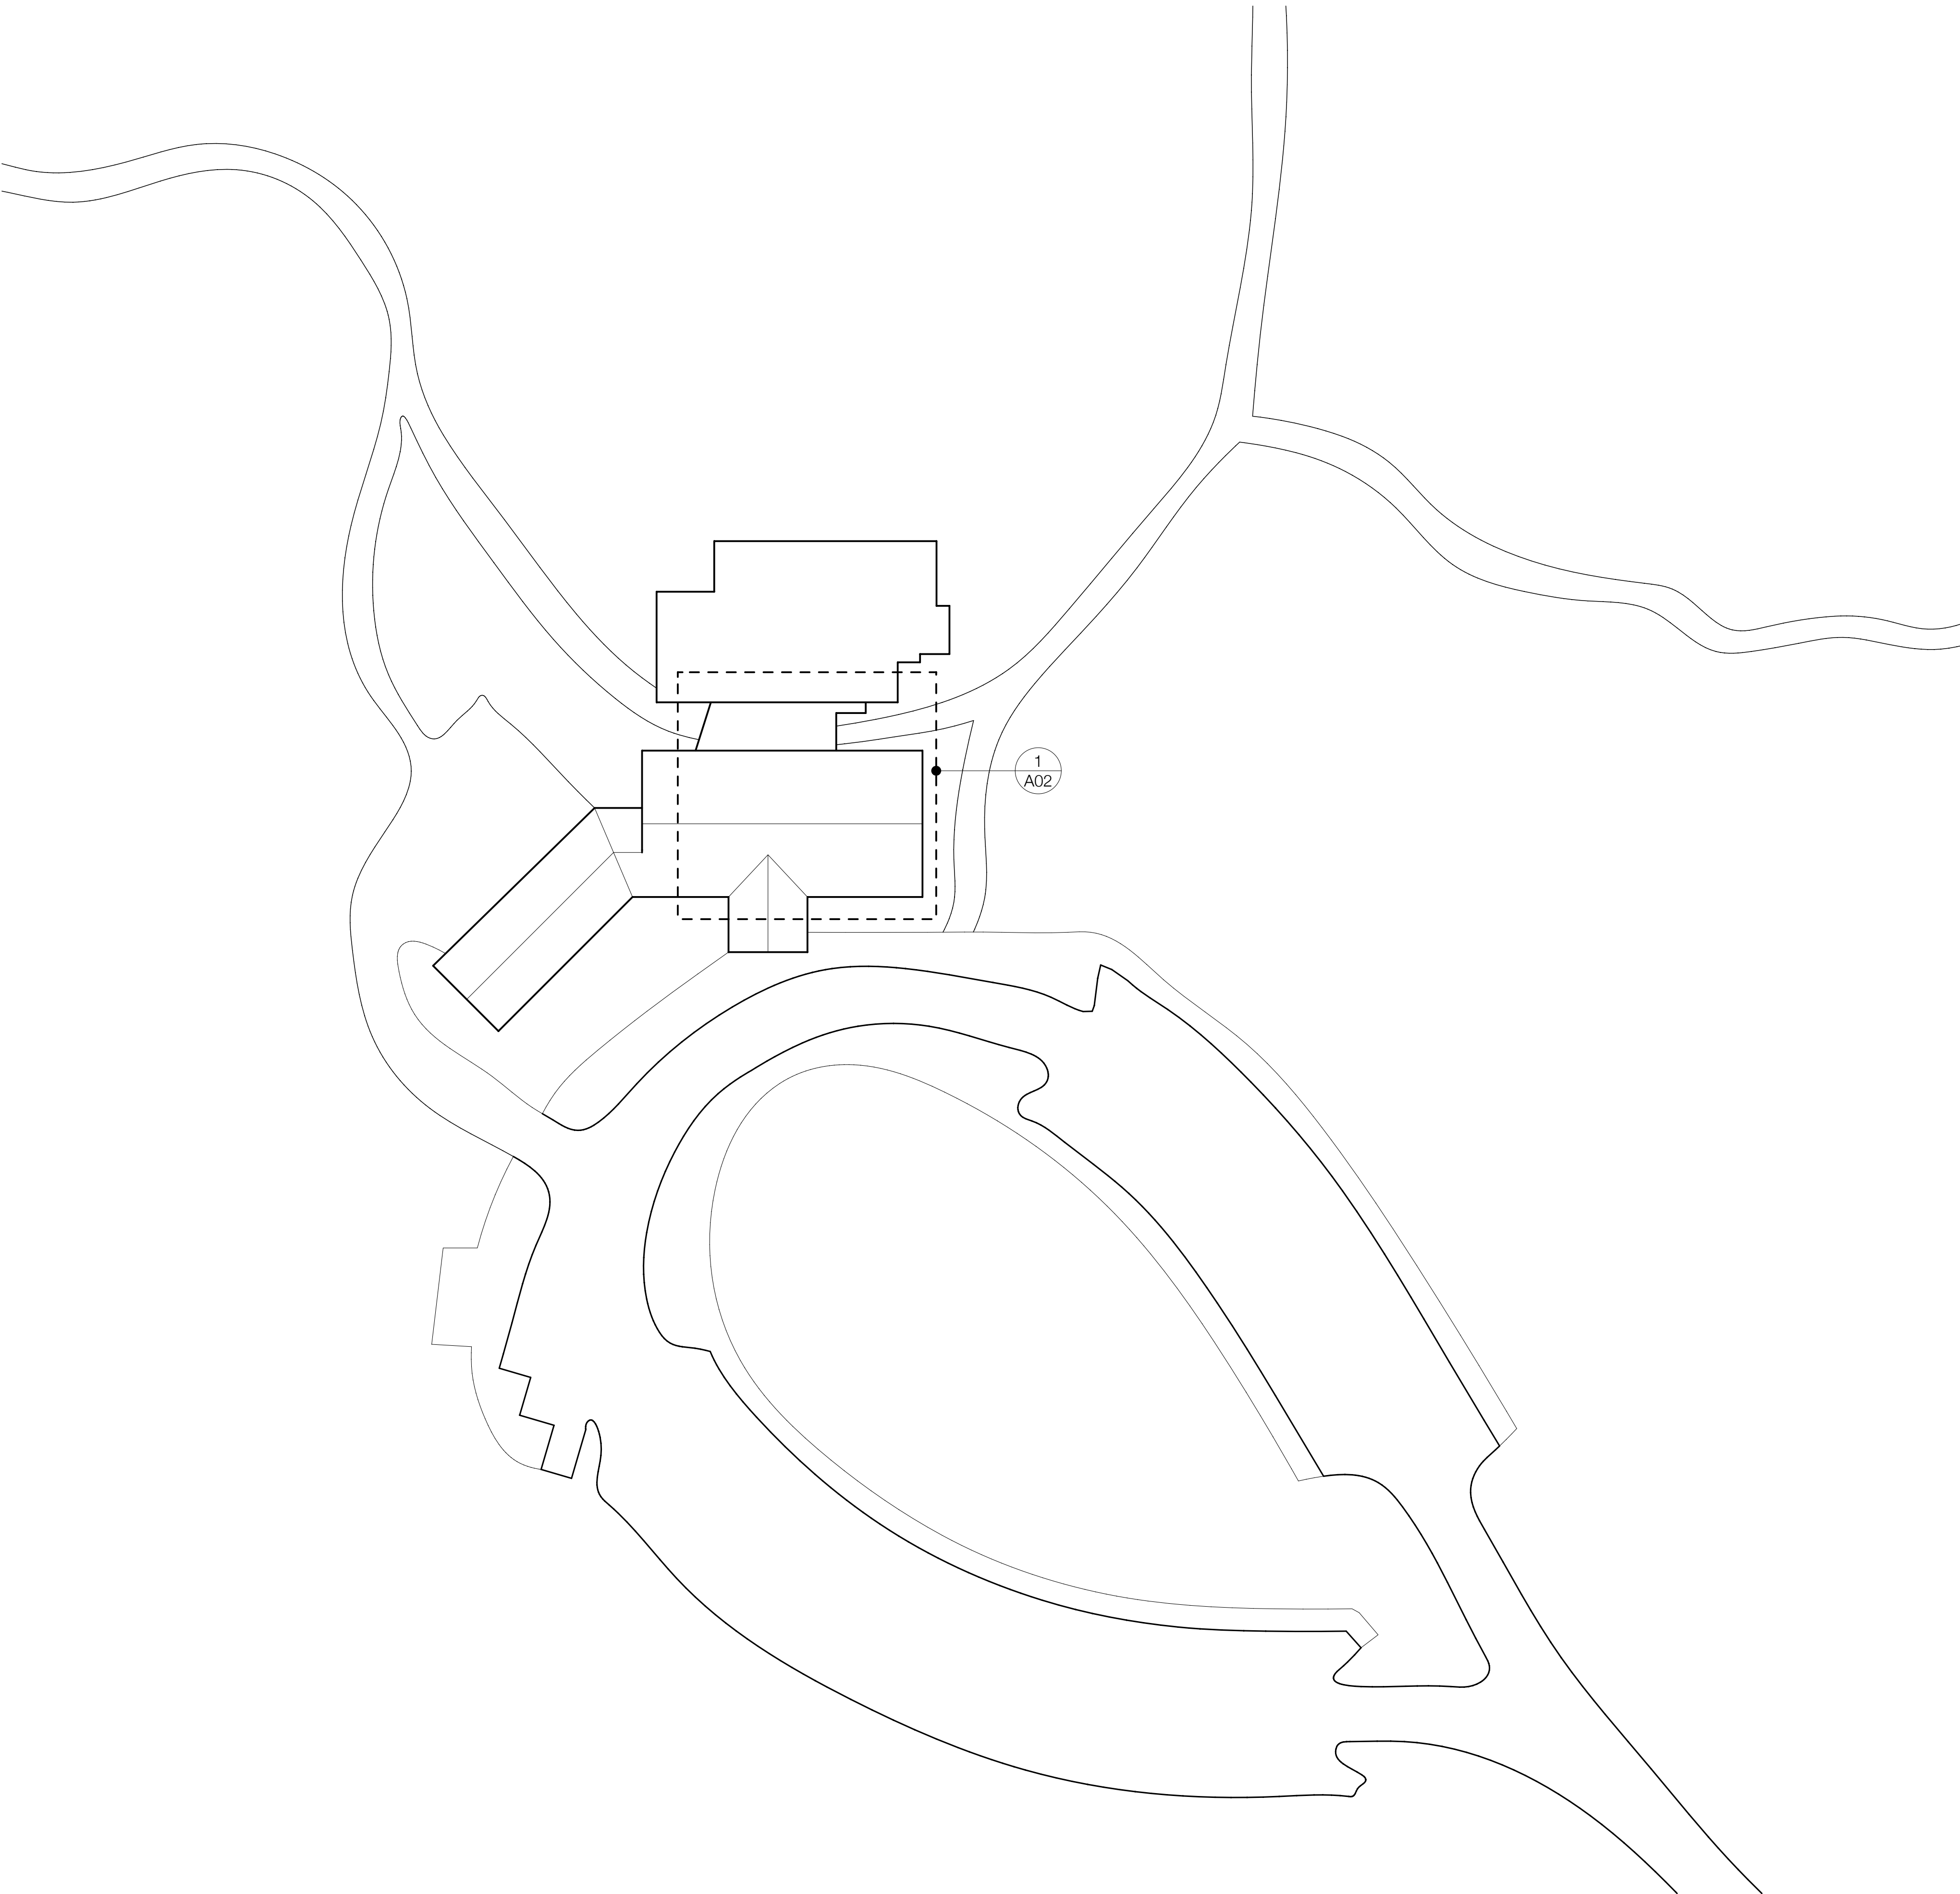

SITE PLAN
SCALE: 1/32" = 1'-0"

 


EXHIBIT PLAN

Title:

DD2

Revision #:

6/14/18


Date:

PIPESTONE NATIONAL MONUMENT
VISITOR CENTER EXHIBITS

These documents have been created to show the designers' intent only. Written dimensions shall take precedence over scaled dimensions. Contractors shall verify and be responsible for all dimensions and conditions on the job, and this office must be notified of any variations from the dimensions and conditions shown by these drawings. Shop details must be submitted to this office before beginning fabrication. All ideas, designs, and arrangements indicated on these drawings are the property of EDX and are intended for the sole use of the client noted.

A03


SHEET 3 OF 14

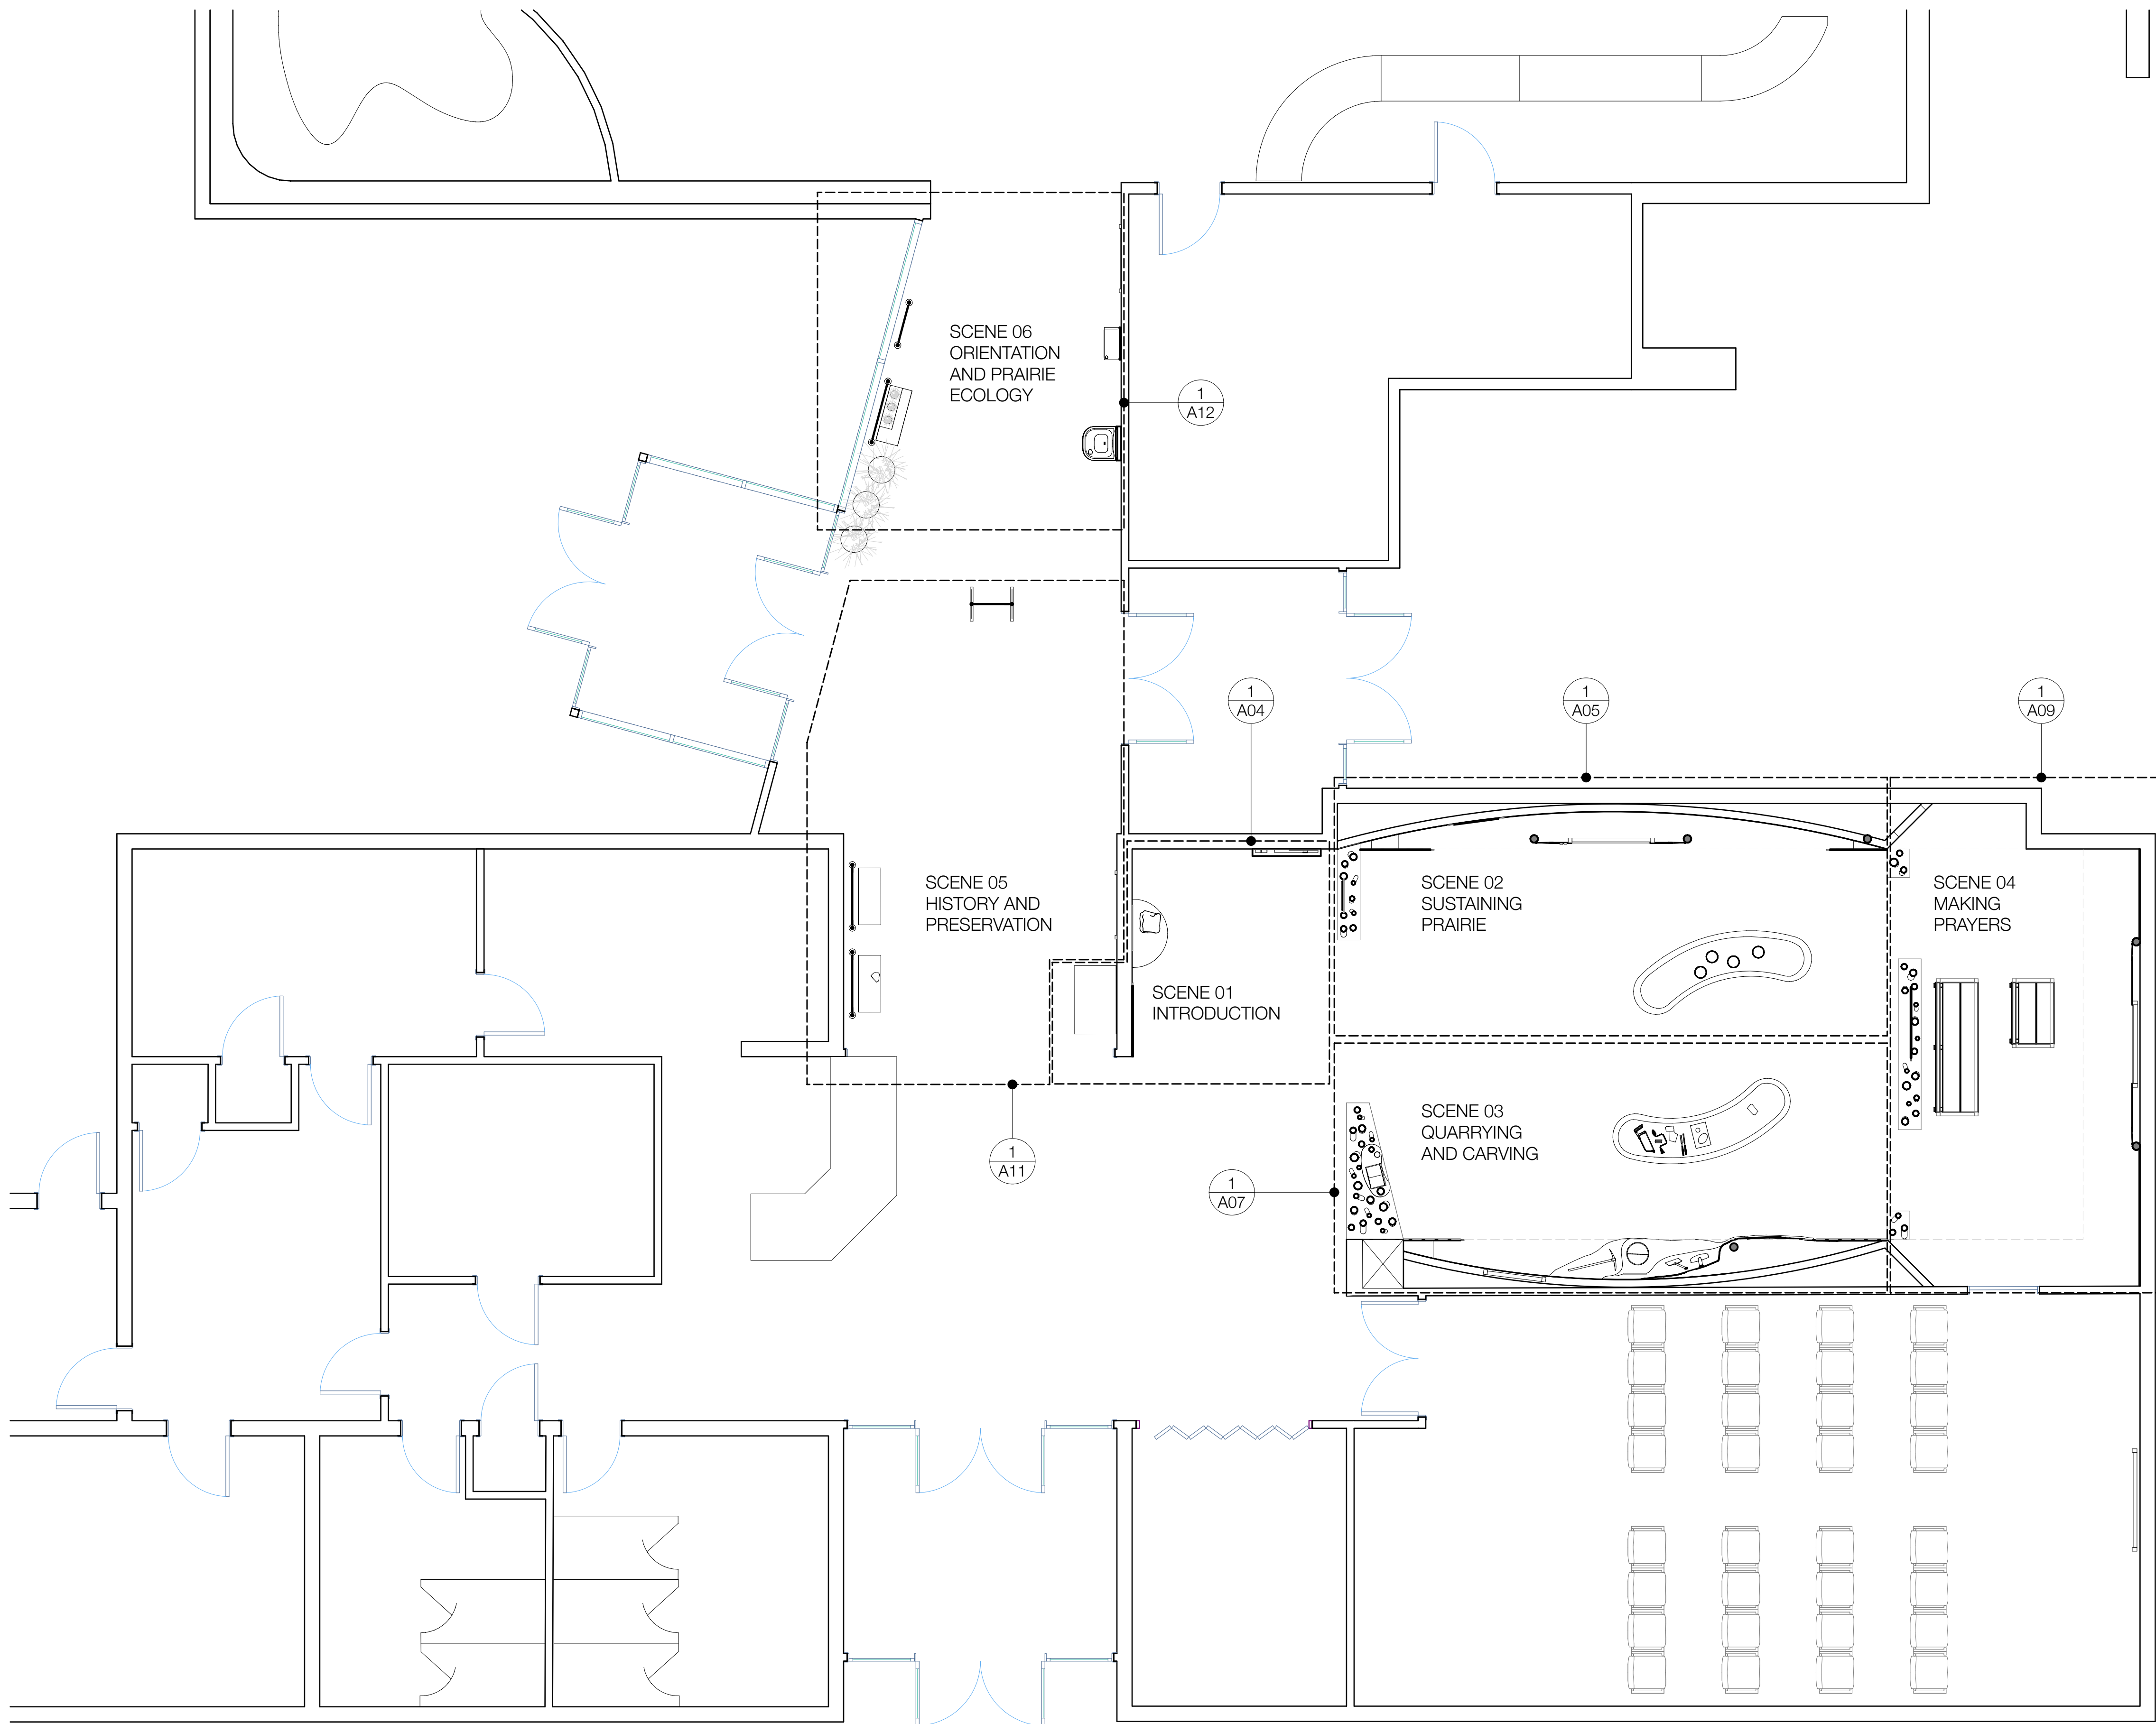

PIPESTONE NATIONAL MONUMENT
VISITOR CENTER EXHIBITS

These documents have been created to show the designers' intent only. Written dimensions shall take precedence over scaled dimensions. Contractors shall verify and be responsible for all dimensions and conditions on the job, and this office must be notified of any variations from the dimensions and conditions shown by these drawings. Shop details must be submitted to this office before beginning fabrication. All ideas, designs, and arrangements indicated on these drawings are the property of EDX and are intended for the sole use of the client noted.


A04

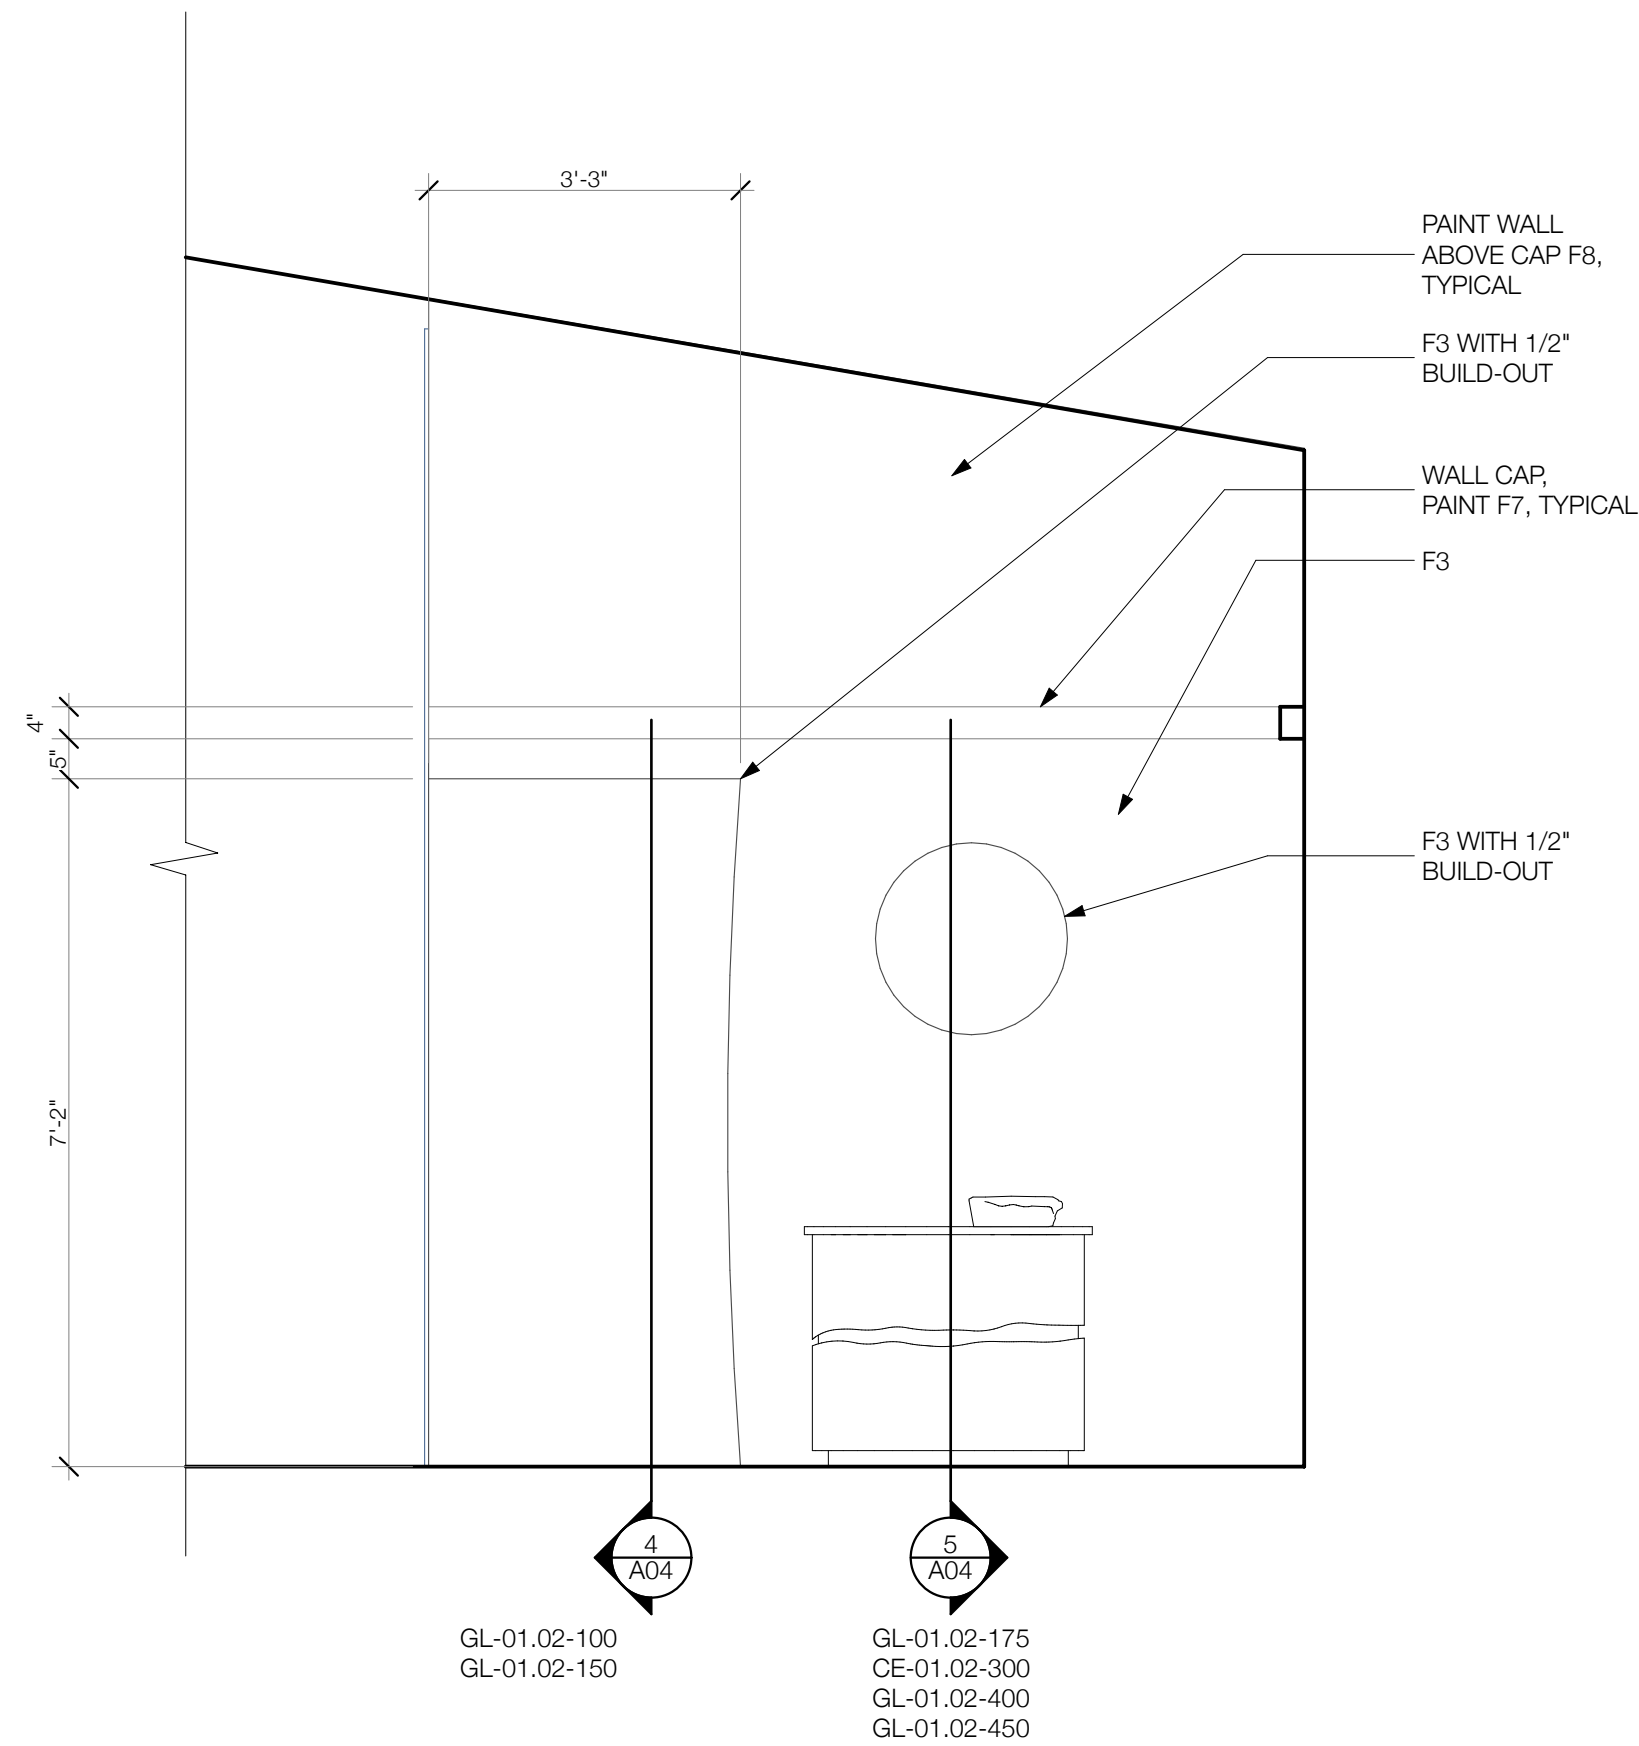

INTRODUCTION ELEVATION

SCALE: 1/2" = 1'-0"


6

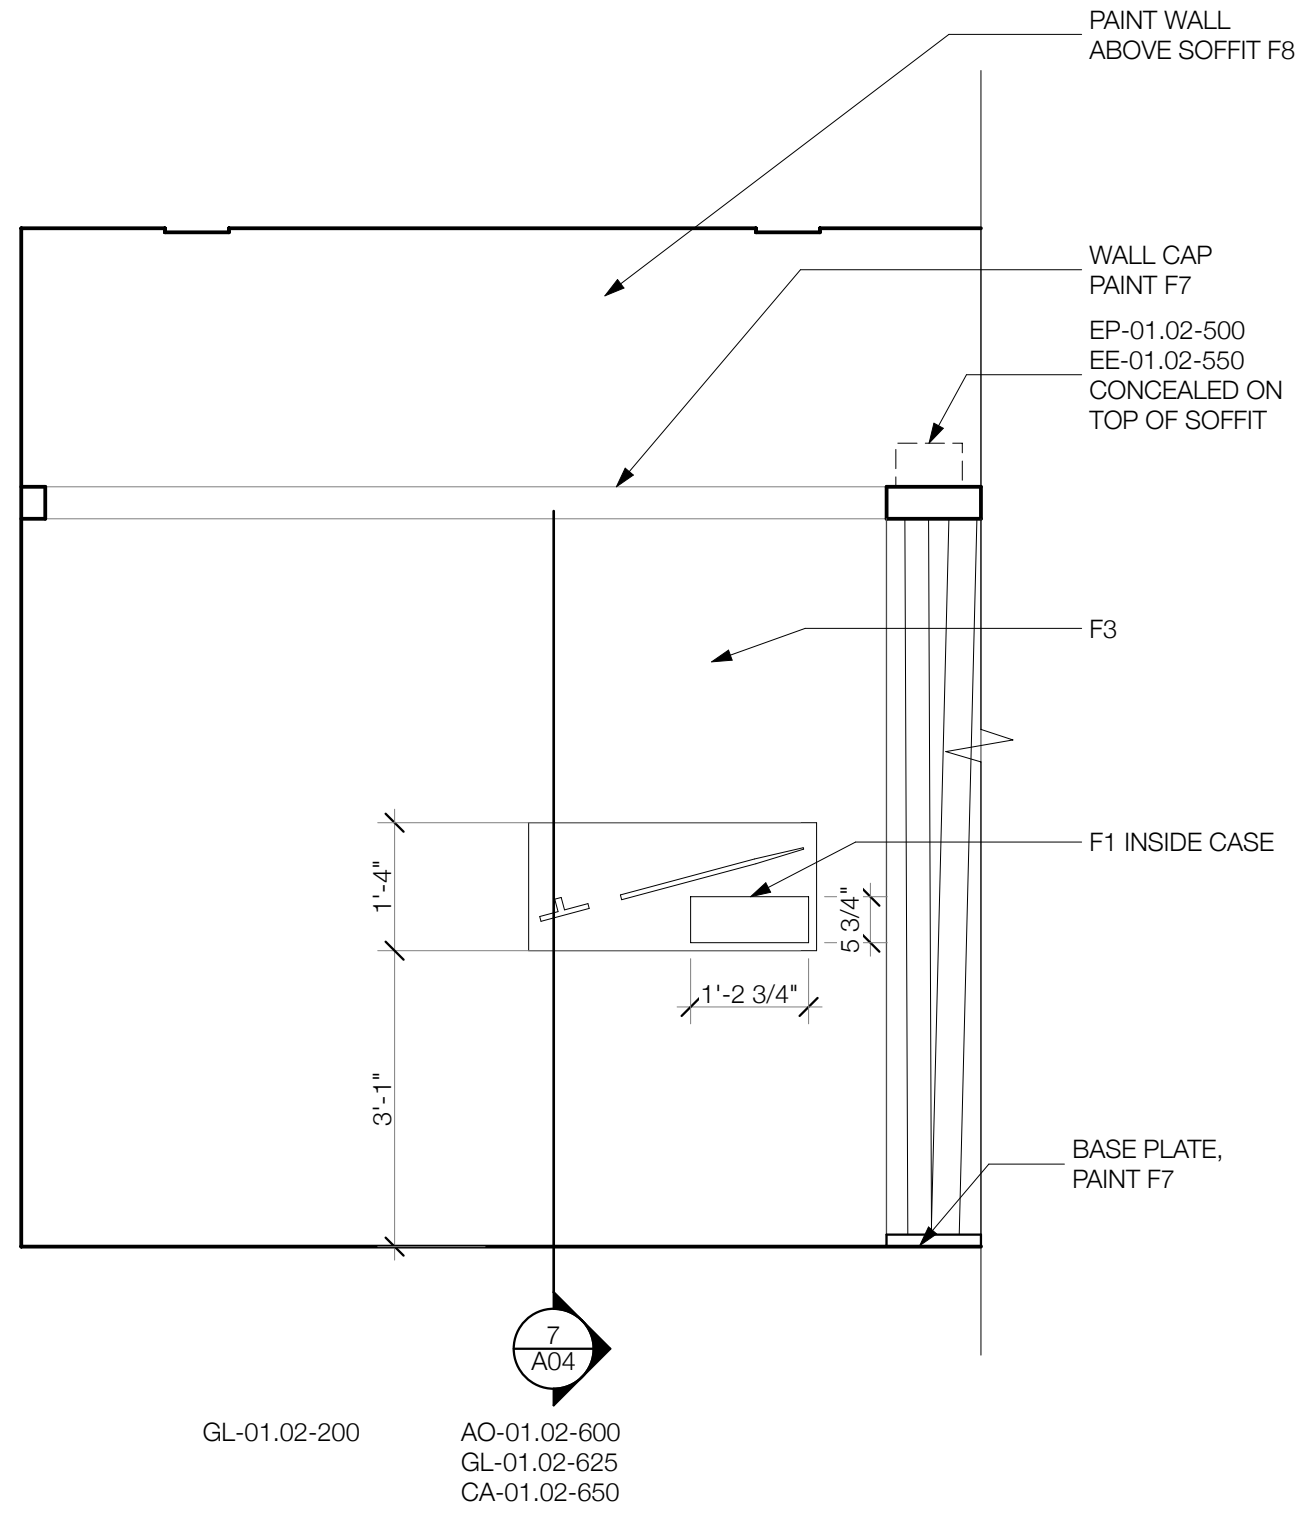

PIPE DISPLAY ELEVATION

SCALE: 1/2" = 1'-0"


3

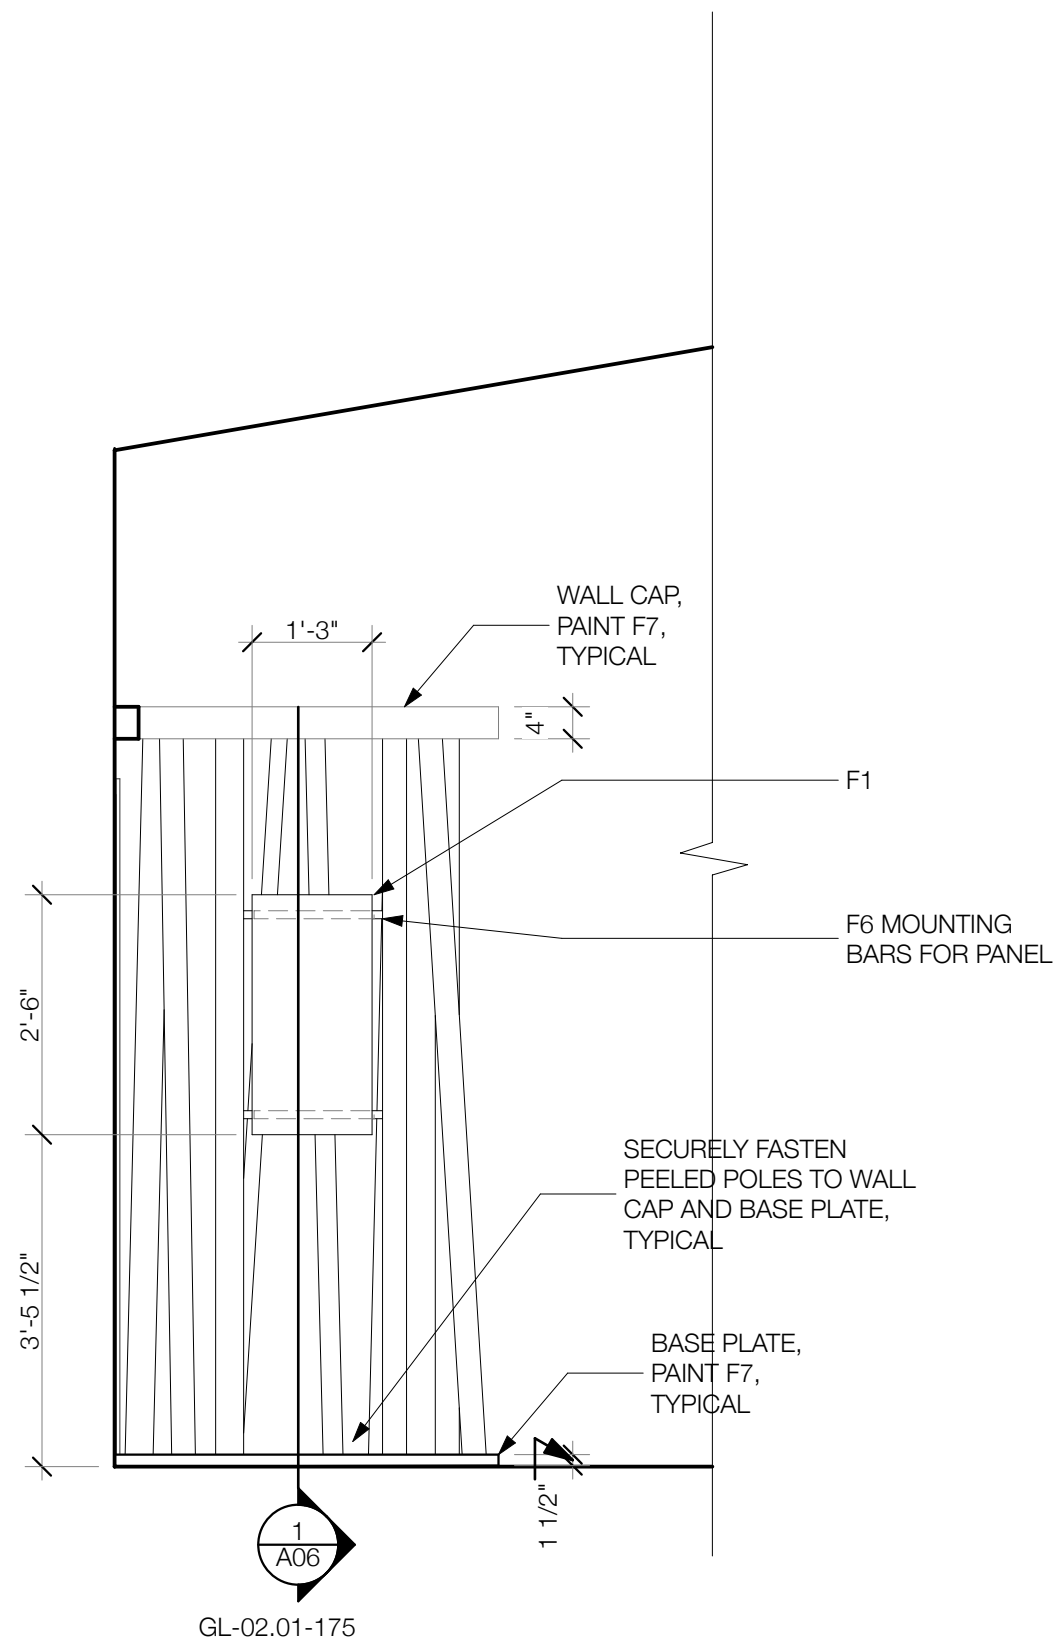

MEDICINE WHEEL PANEL ELEVATION

SCALE: 1/2" = 1'-0"

2

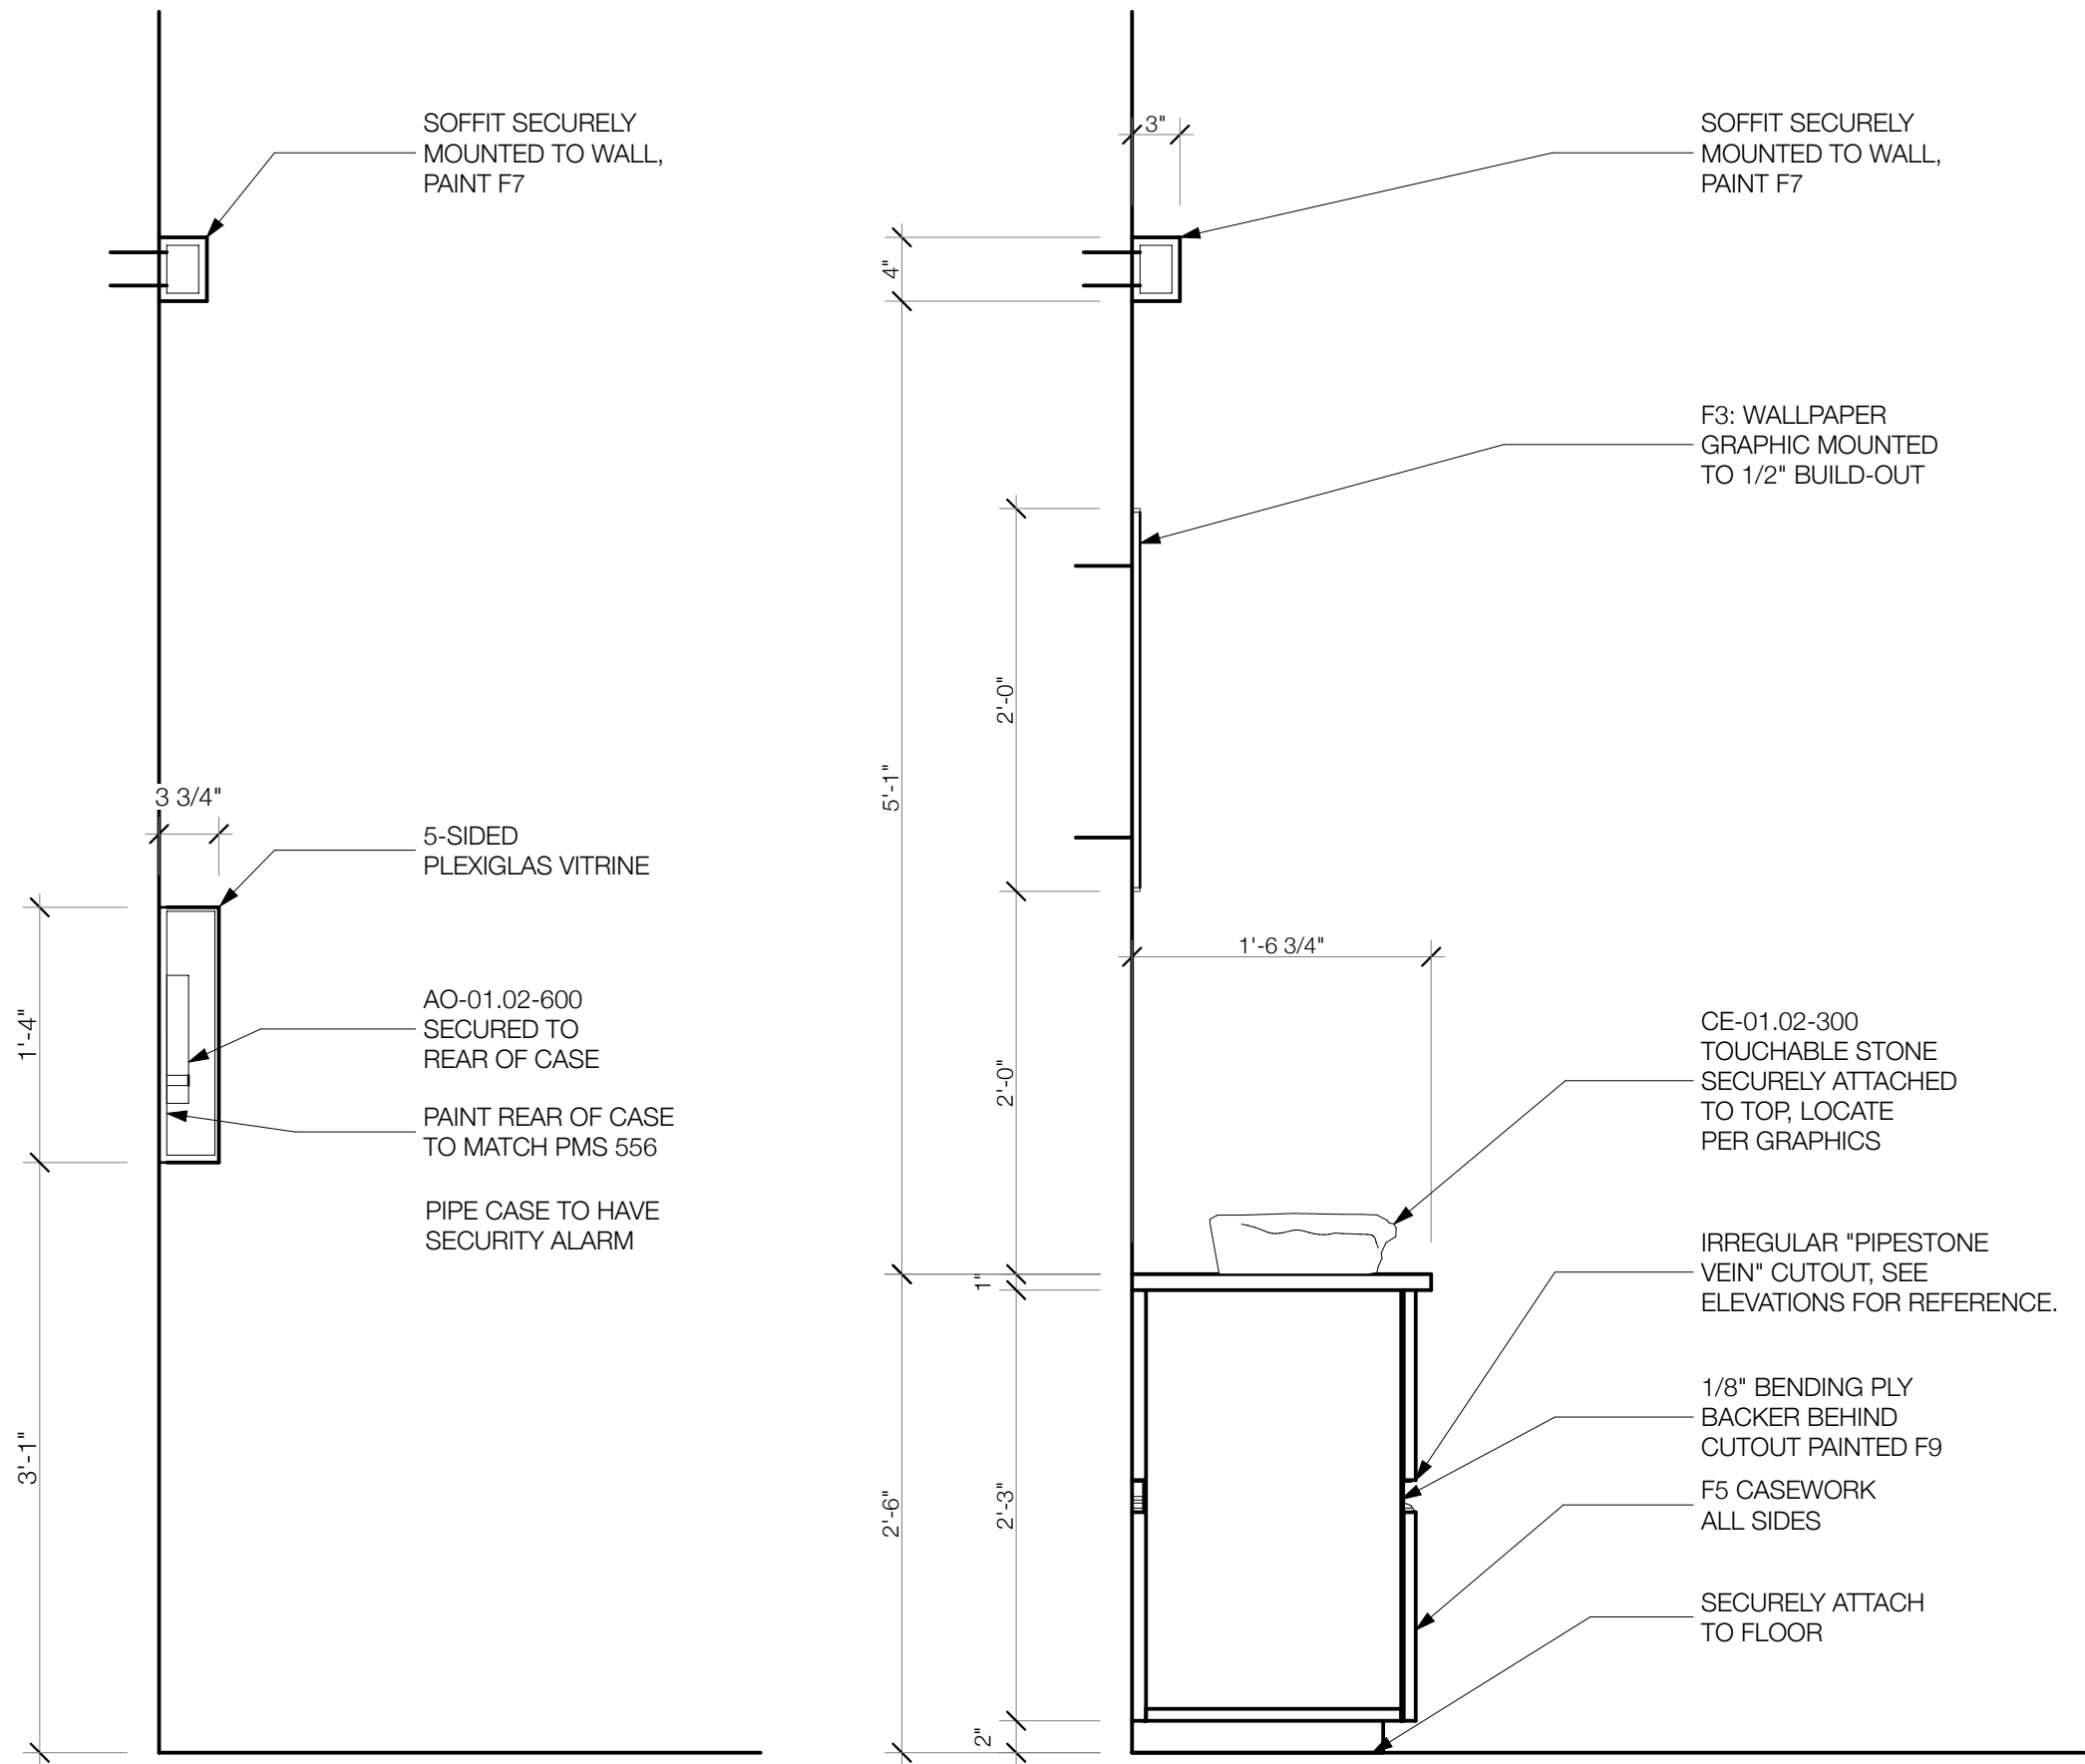

PIPE CASE SECTION


SCALE: 1" = 1'-0"

7

TOUCHABLE STONE SECTION

SCALE: 1" = 1'-0"


5

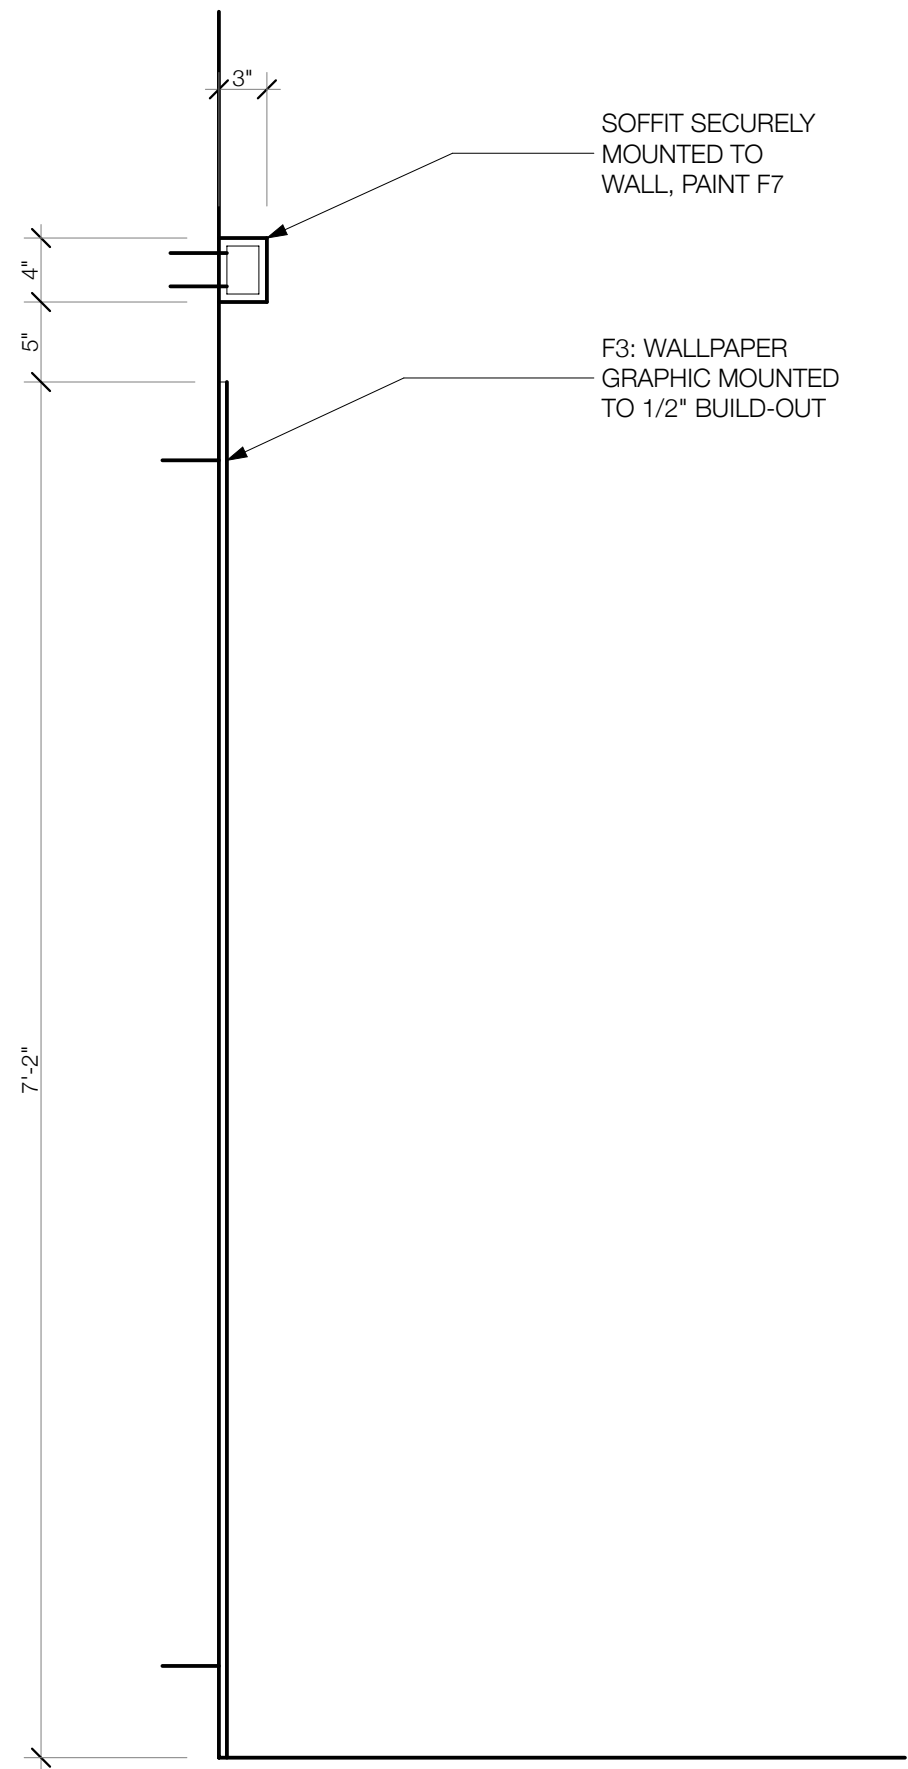

WALL-MOUNTED PANEL SECTION

SCALE: 1" = 1'-0"


4

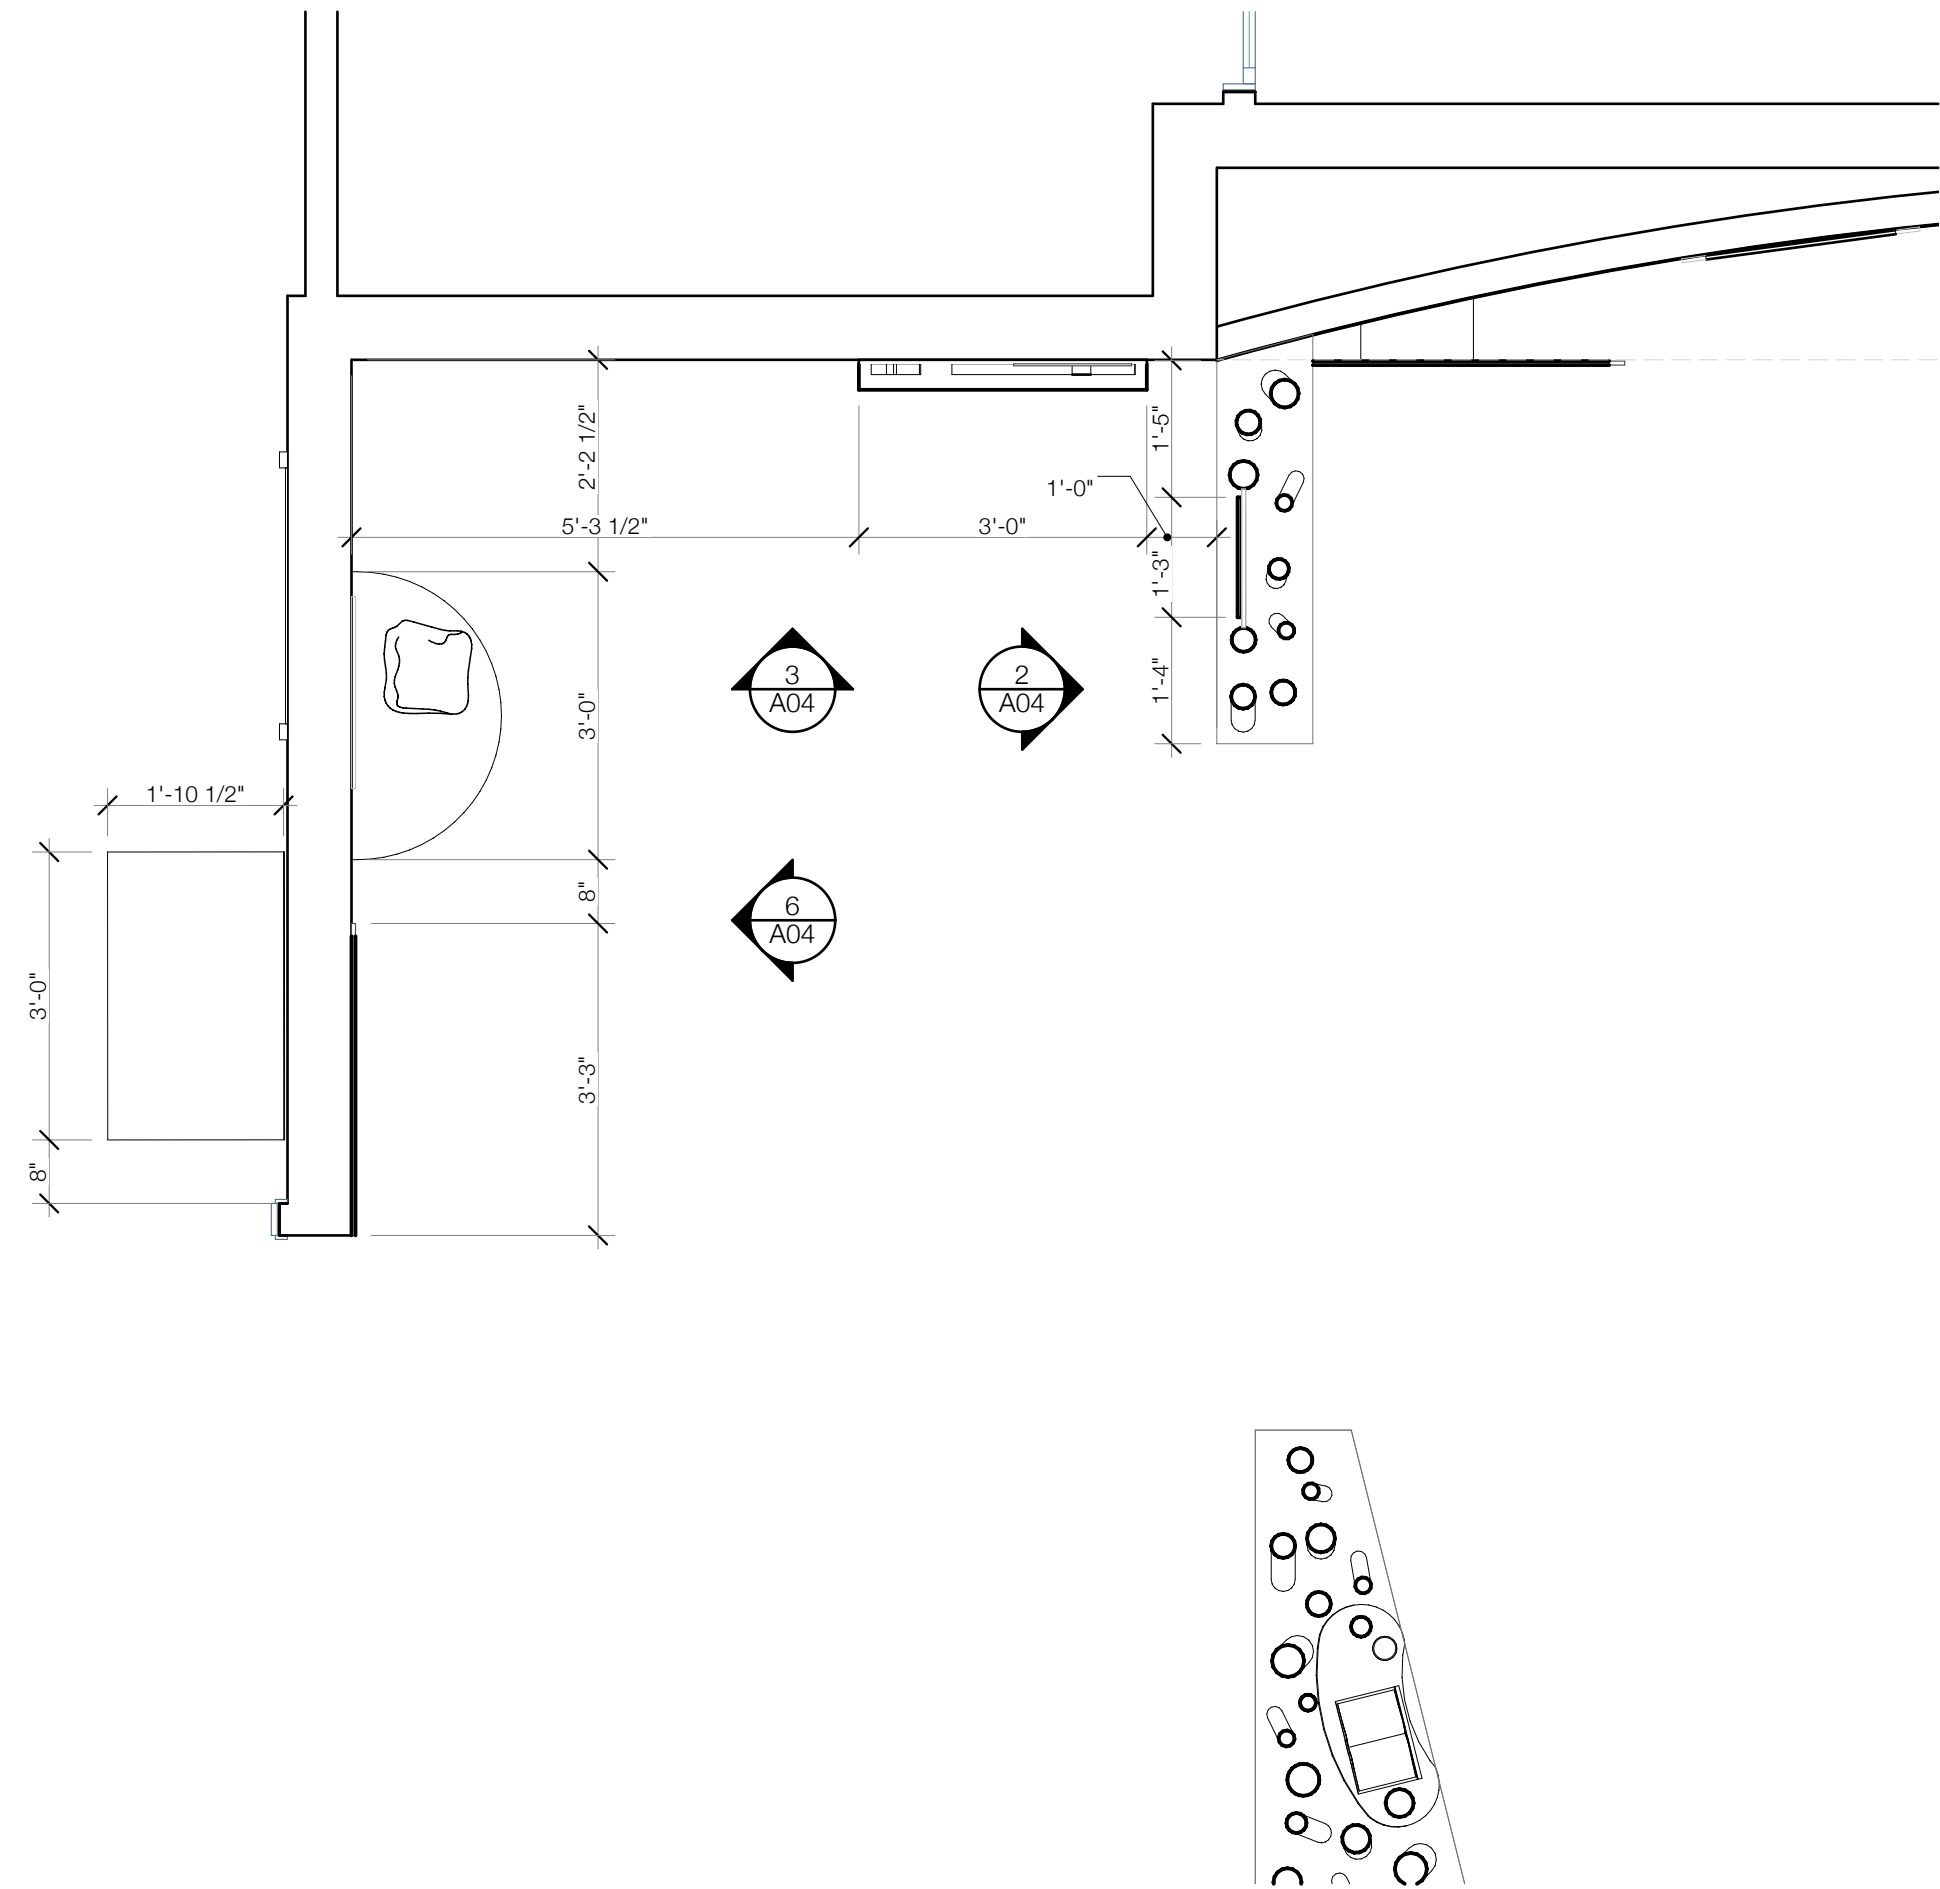

SCENE 01 INTRODUCTION PLAN

SCALE: 1/2" = 1'-0"


1

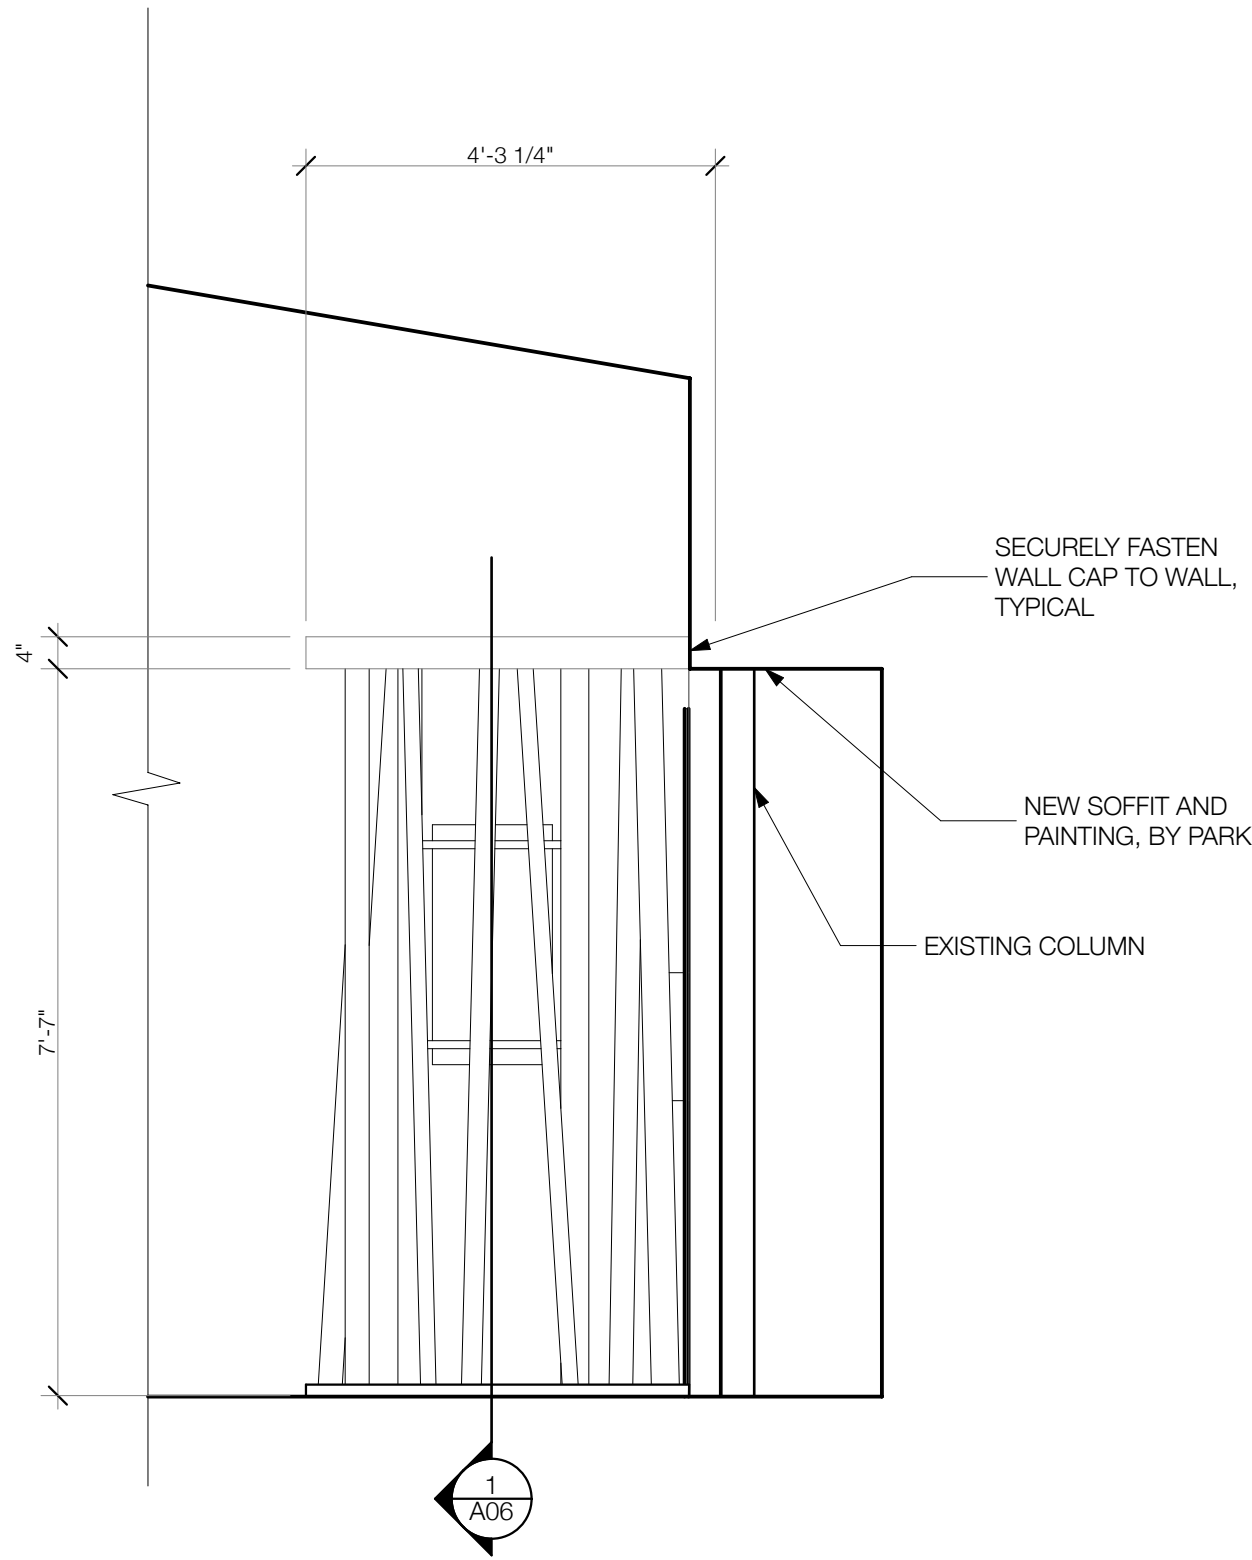

S02 PEELED POLE WALL ELEVATION

SCALE: 1/2" = 1'-0"


3

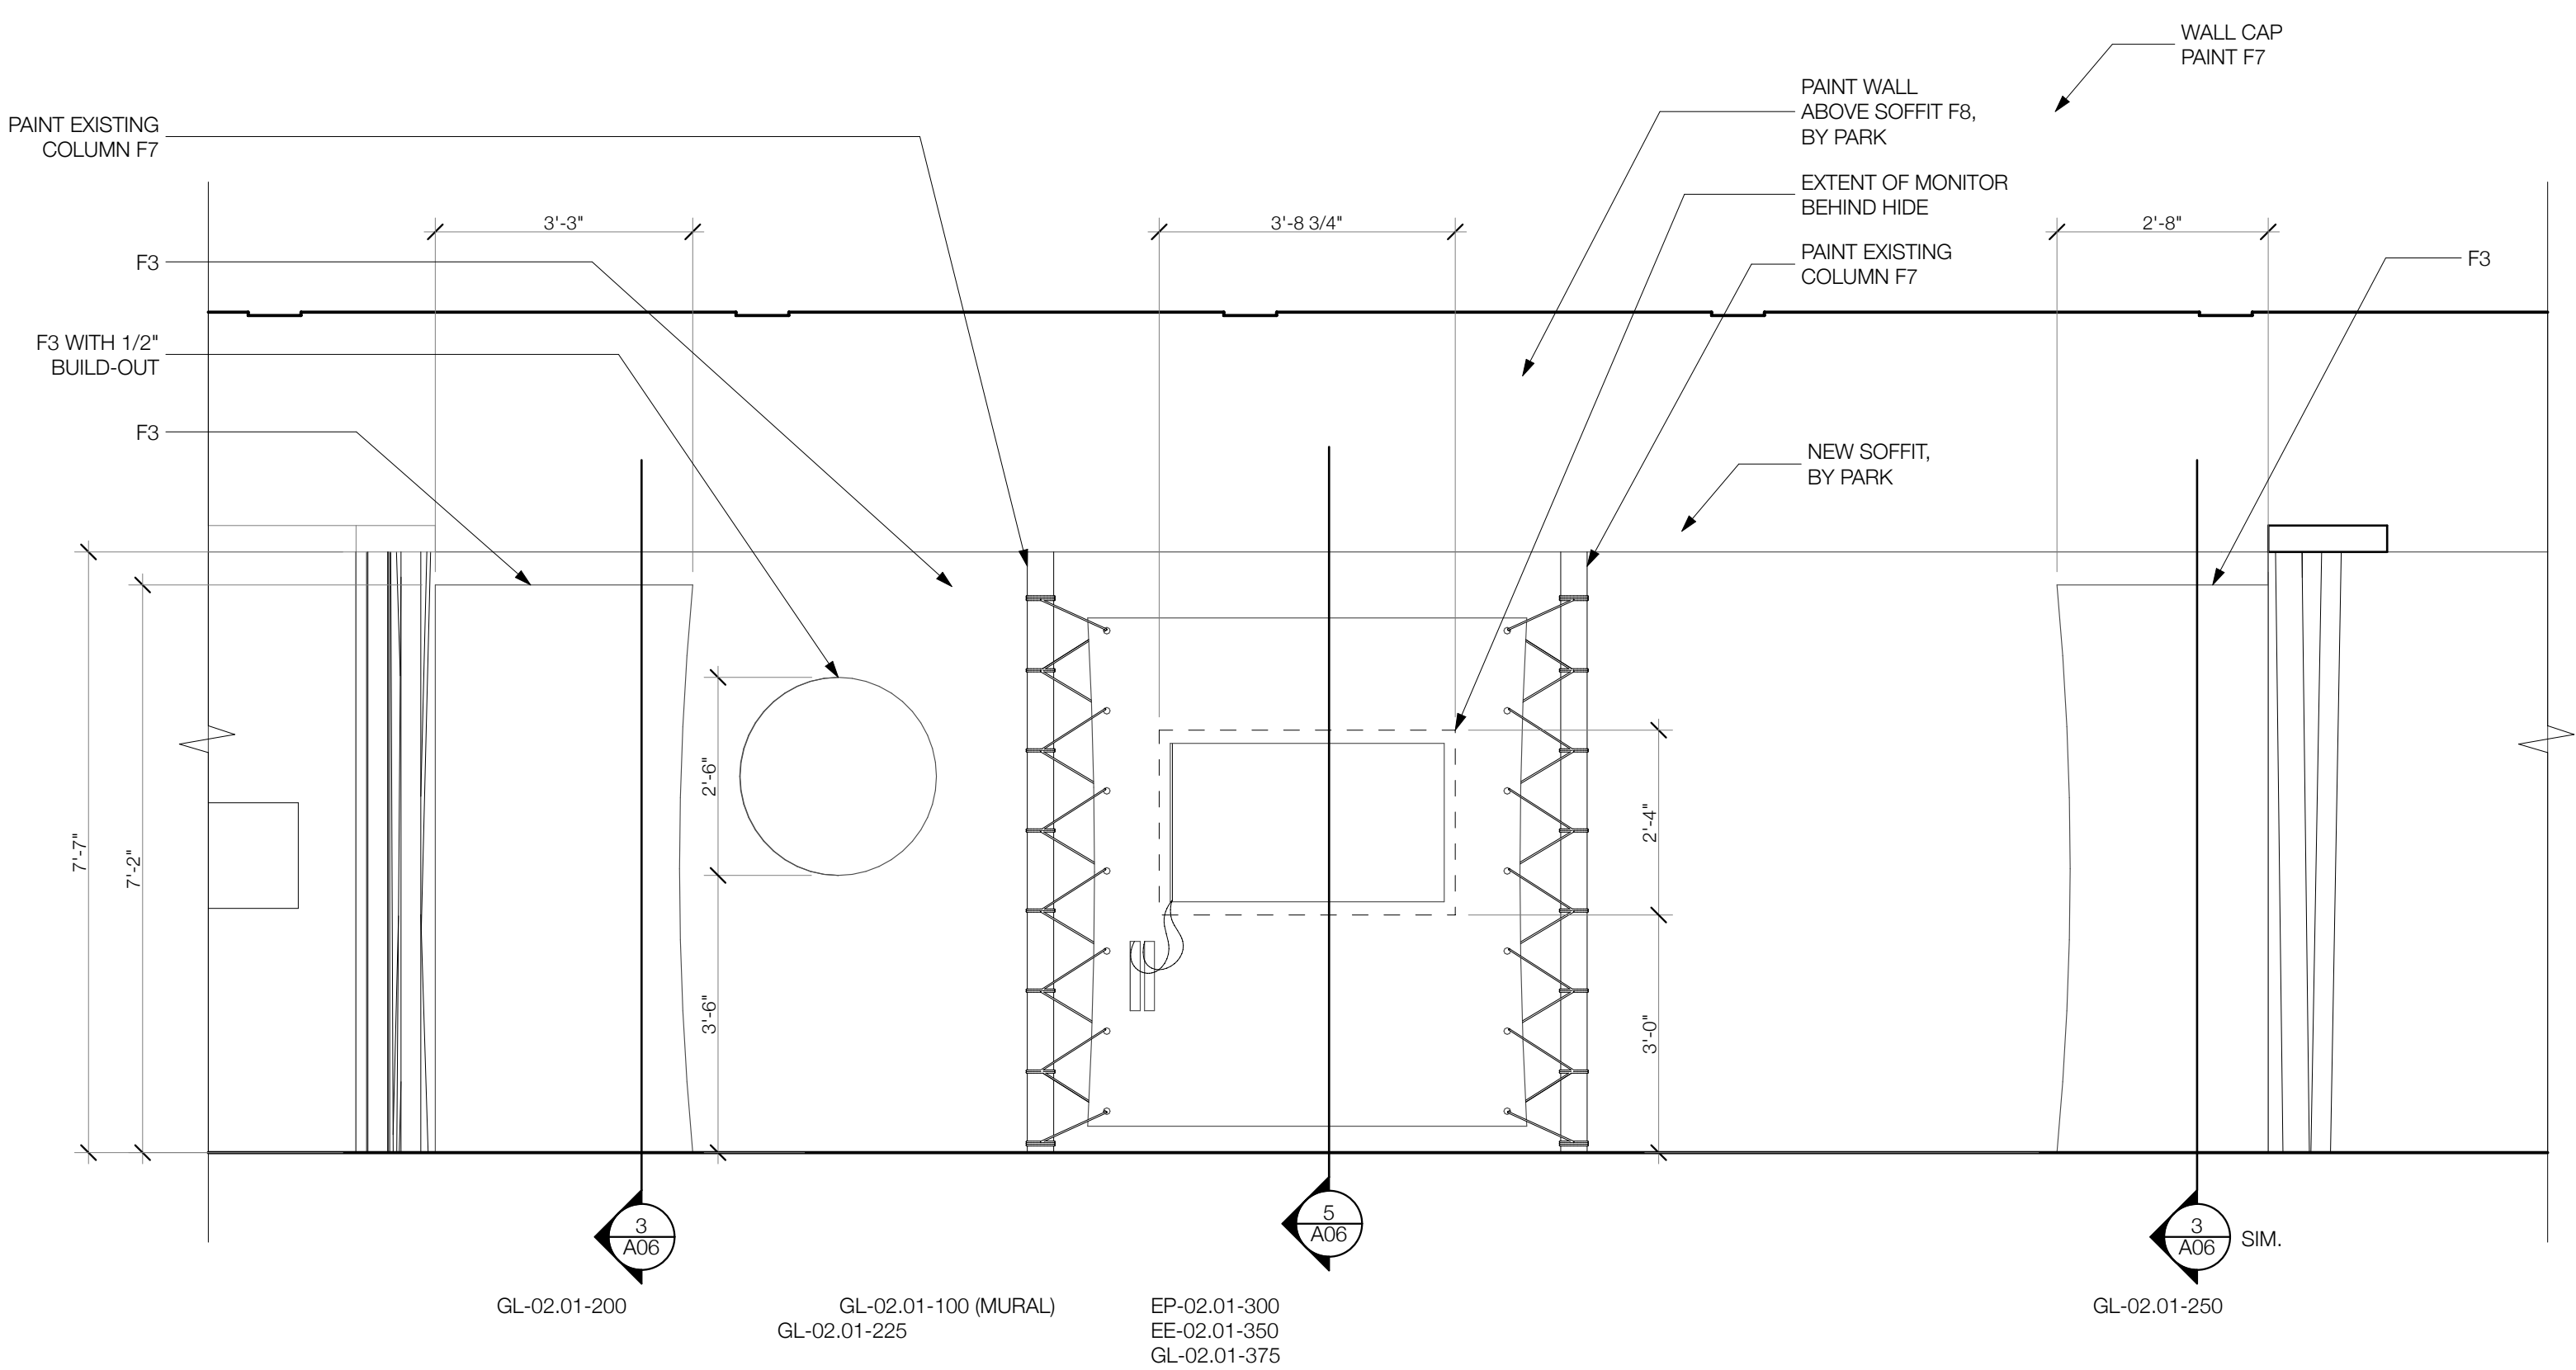

PRAIRIE ELEVATION

SCALE: 1/2" = 1'-0"

2

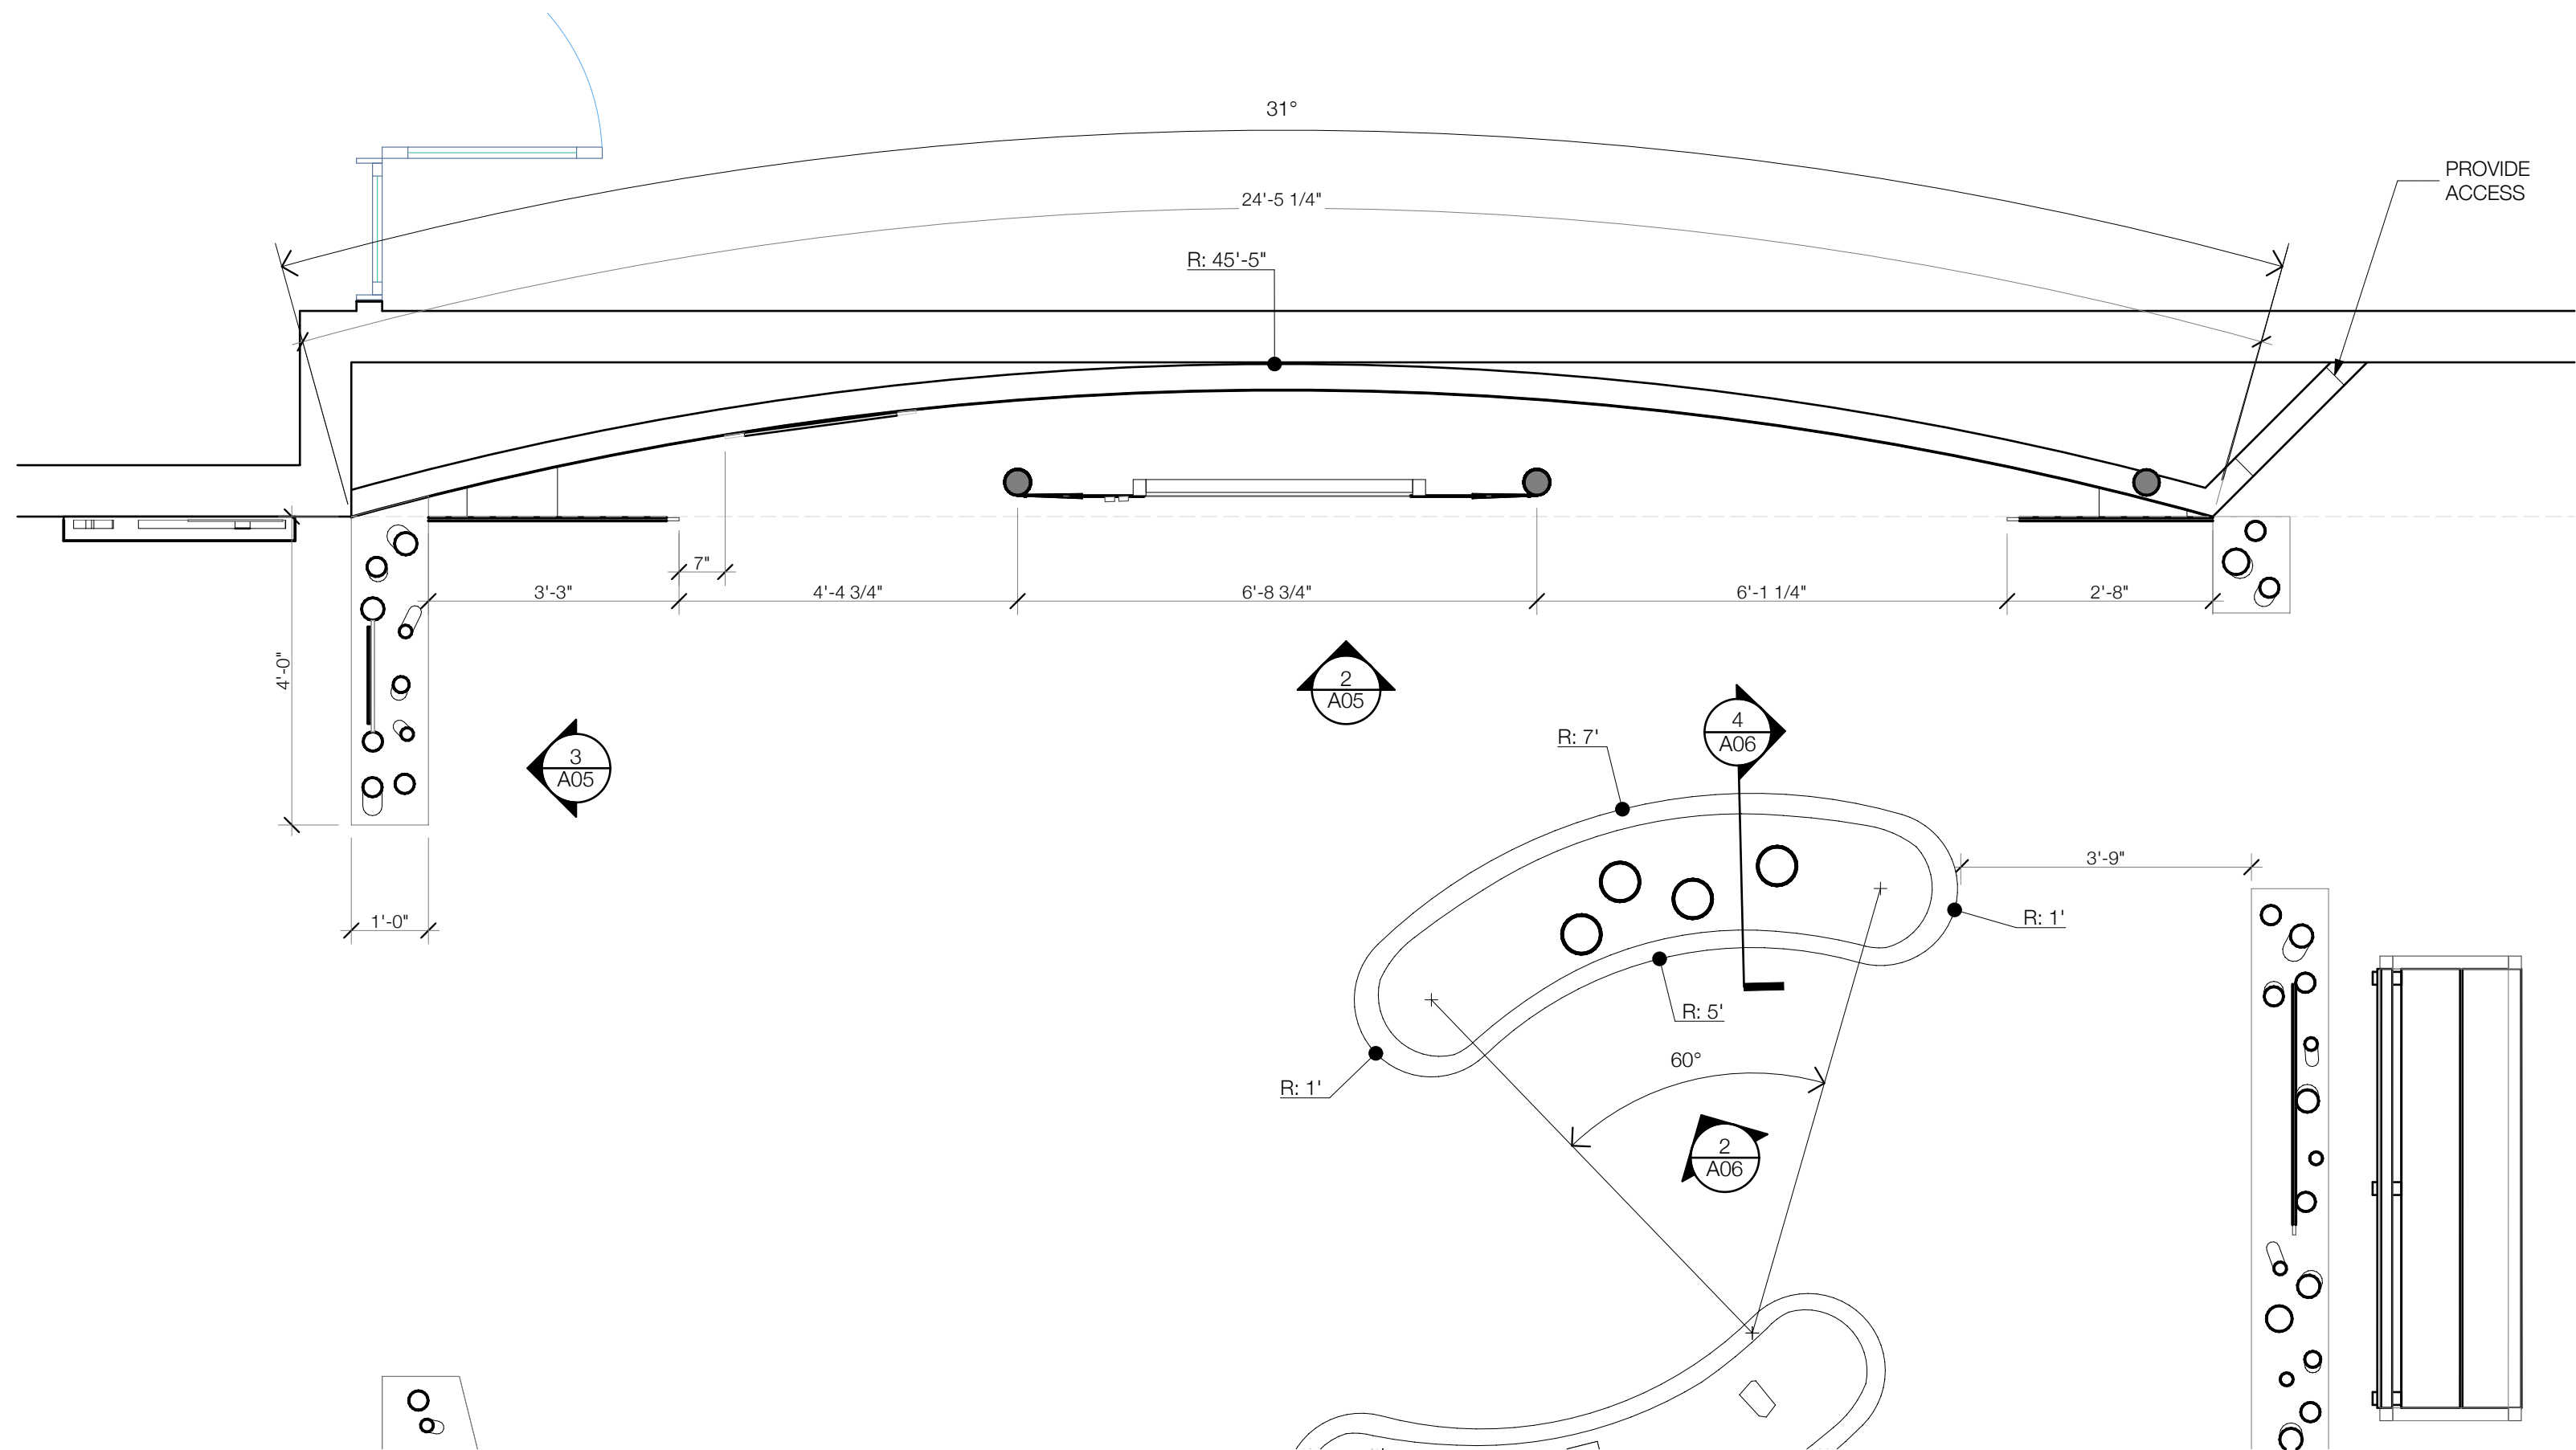

SCENE 02 SUSTAINING PRAIRIE PLAN

SCALE: 1/2" = 1'-0"

1



SCENE 02
DETAILS

Title:

DD2

Revision #:

6/27/18


Date:

PIPESTONE NATIONAL MONUMENT
VISITOR CENTER EXHIBITS


These documents have been created to show the designers' intent only. Written dimensions shall take precedence over scaled dimensions. Contractors shall verify and be responsible for all dimensions and conditions on the job, and this office must be notified of any variations from the dimensions and conditions shown by these drawings. Shop details must be submitted to this office before beginning fabrication. All ideas, designs, and arrangements indicated on these drawings are the property of EDX and are intended for the sole use of the client noted.

A06


SHEET 6 OF 14

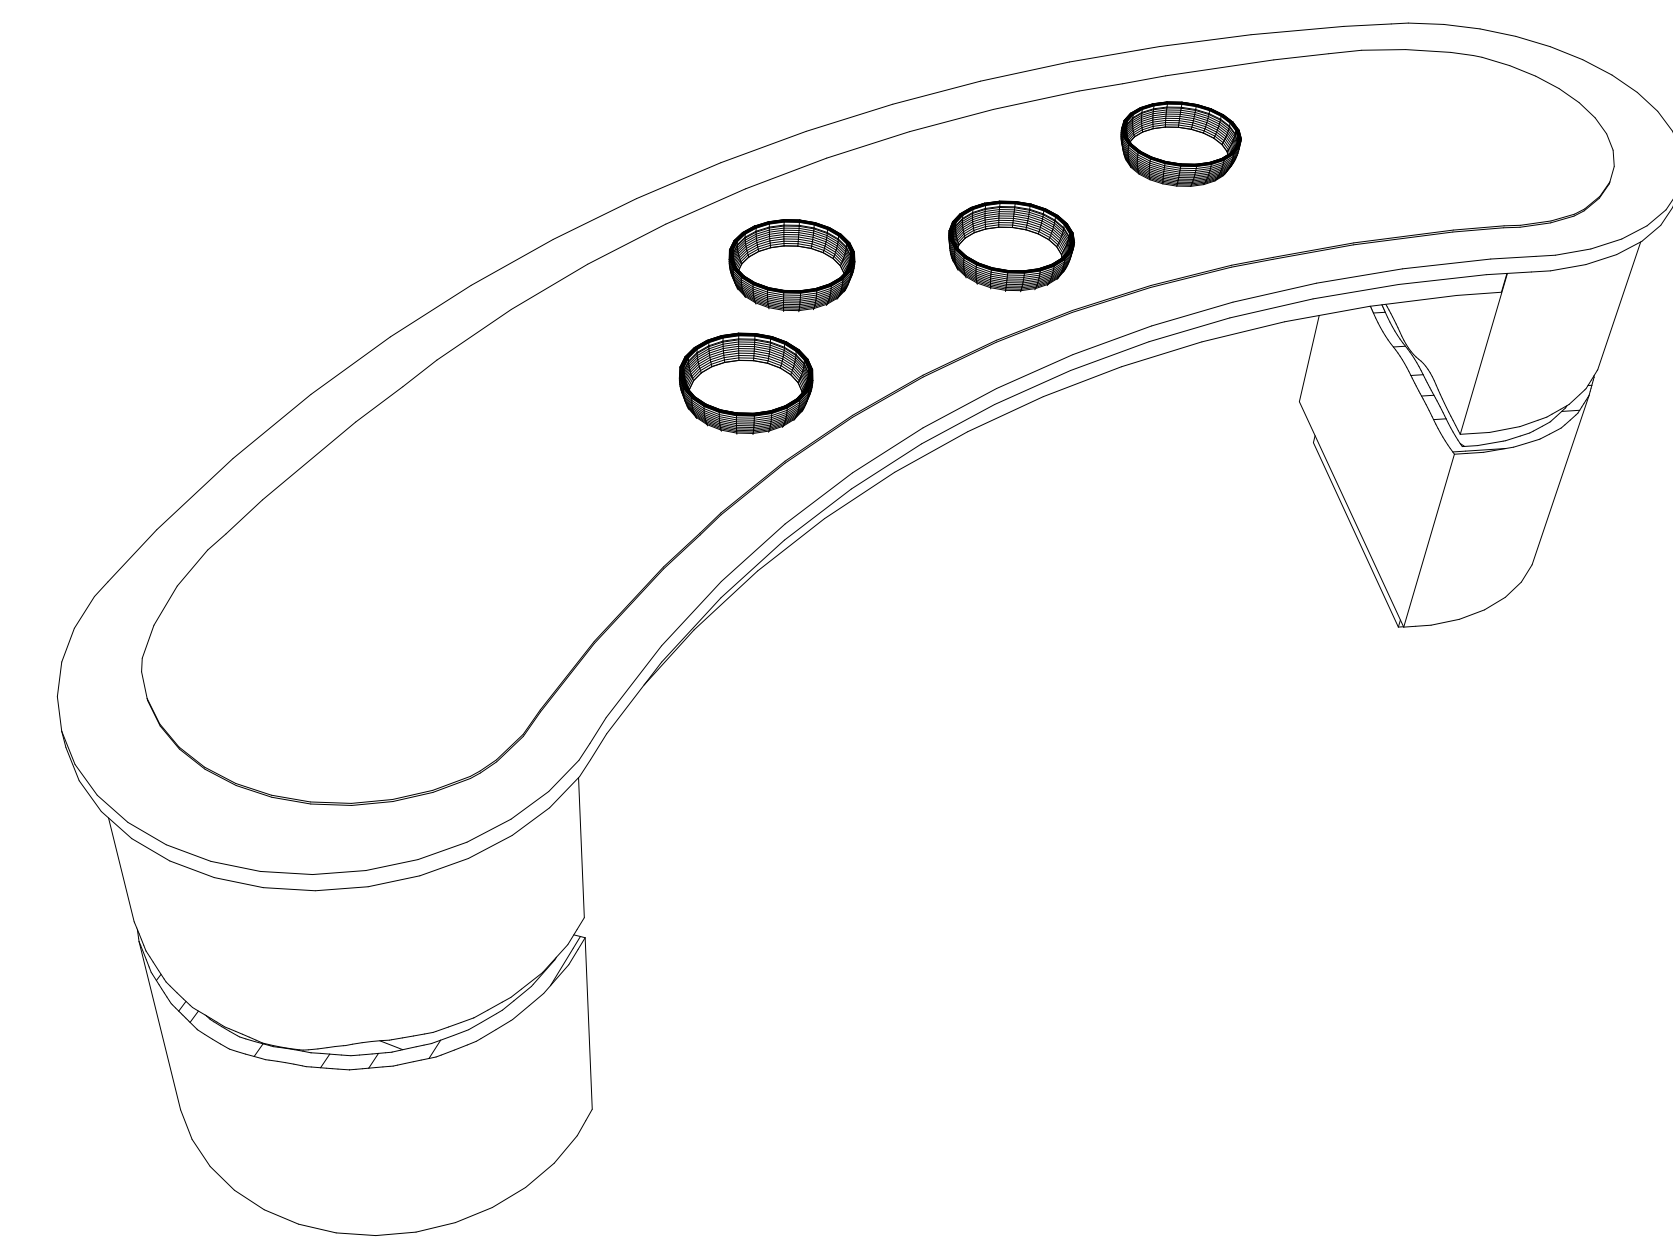BOWL TABLE AXONOMETRY
SCALE: 1/8" = 1'-0"


6

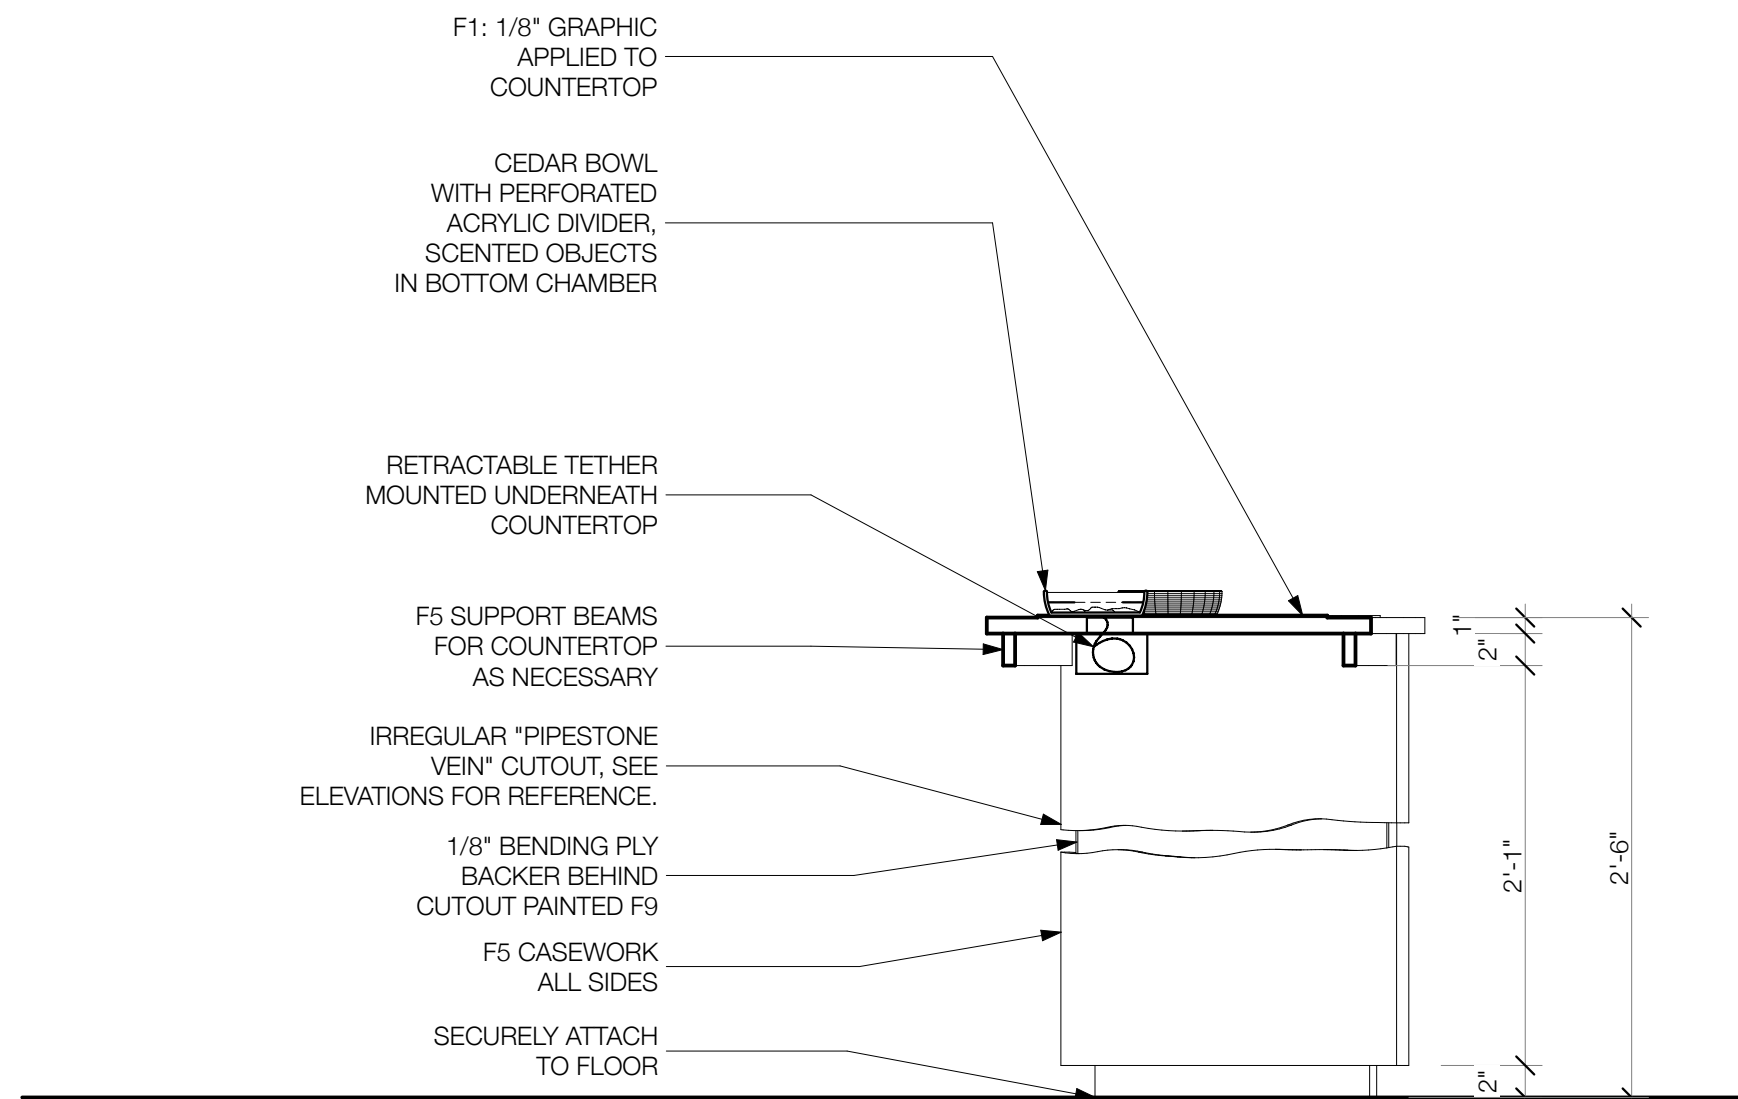BOWL TABLE SECTION
SCALE: 1" = 1'-0"


4

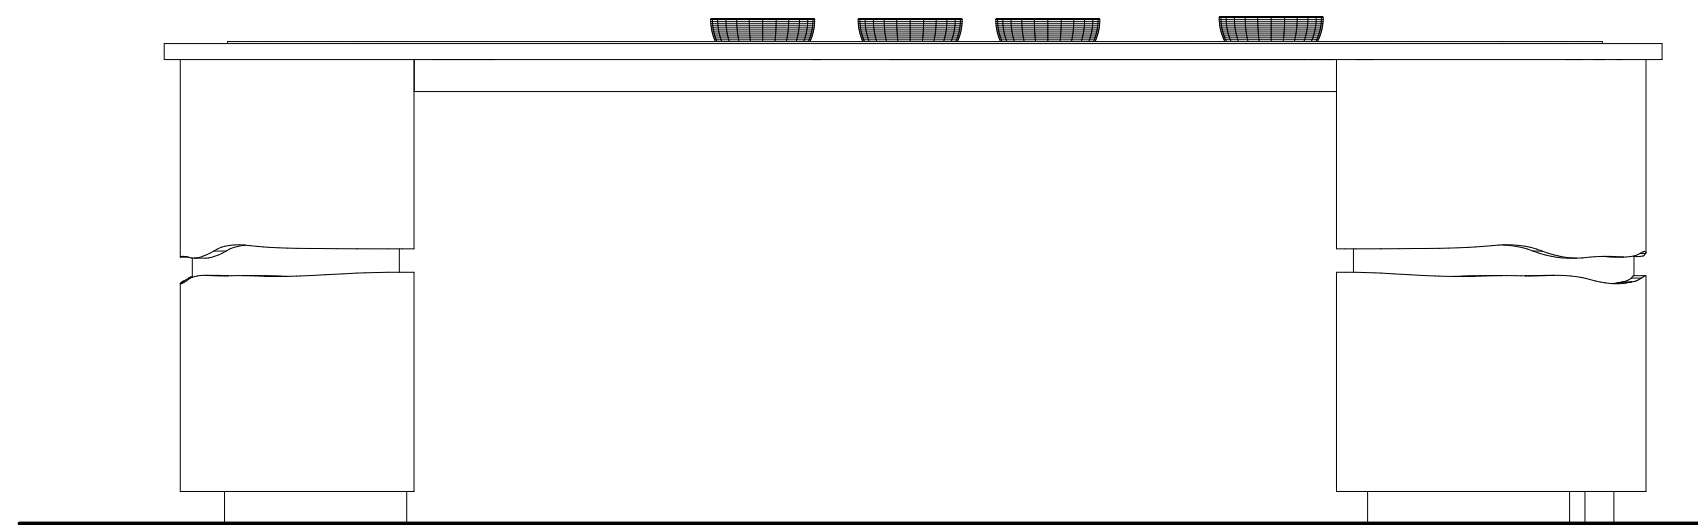GL-02.02-200, 250, 300, 350, 380, 390
GL-02.02-225, 275, 325, 375, 385, 395
GL-02.02-100BOWL TABLE ELEVATION
SCALE: 1" = 1'-0"


2

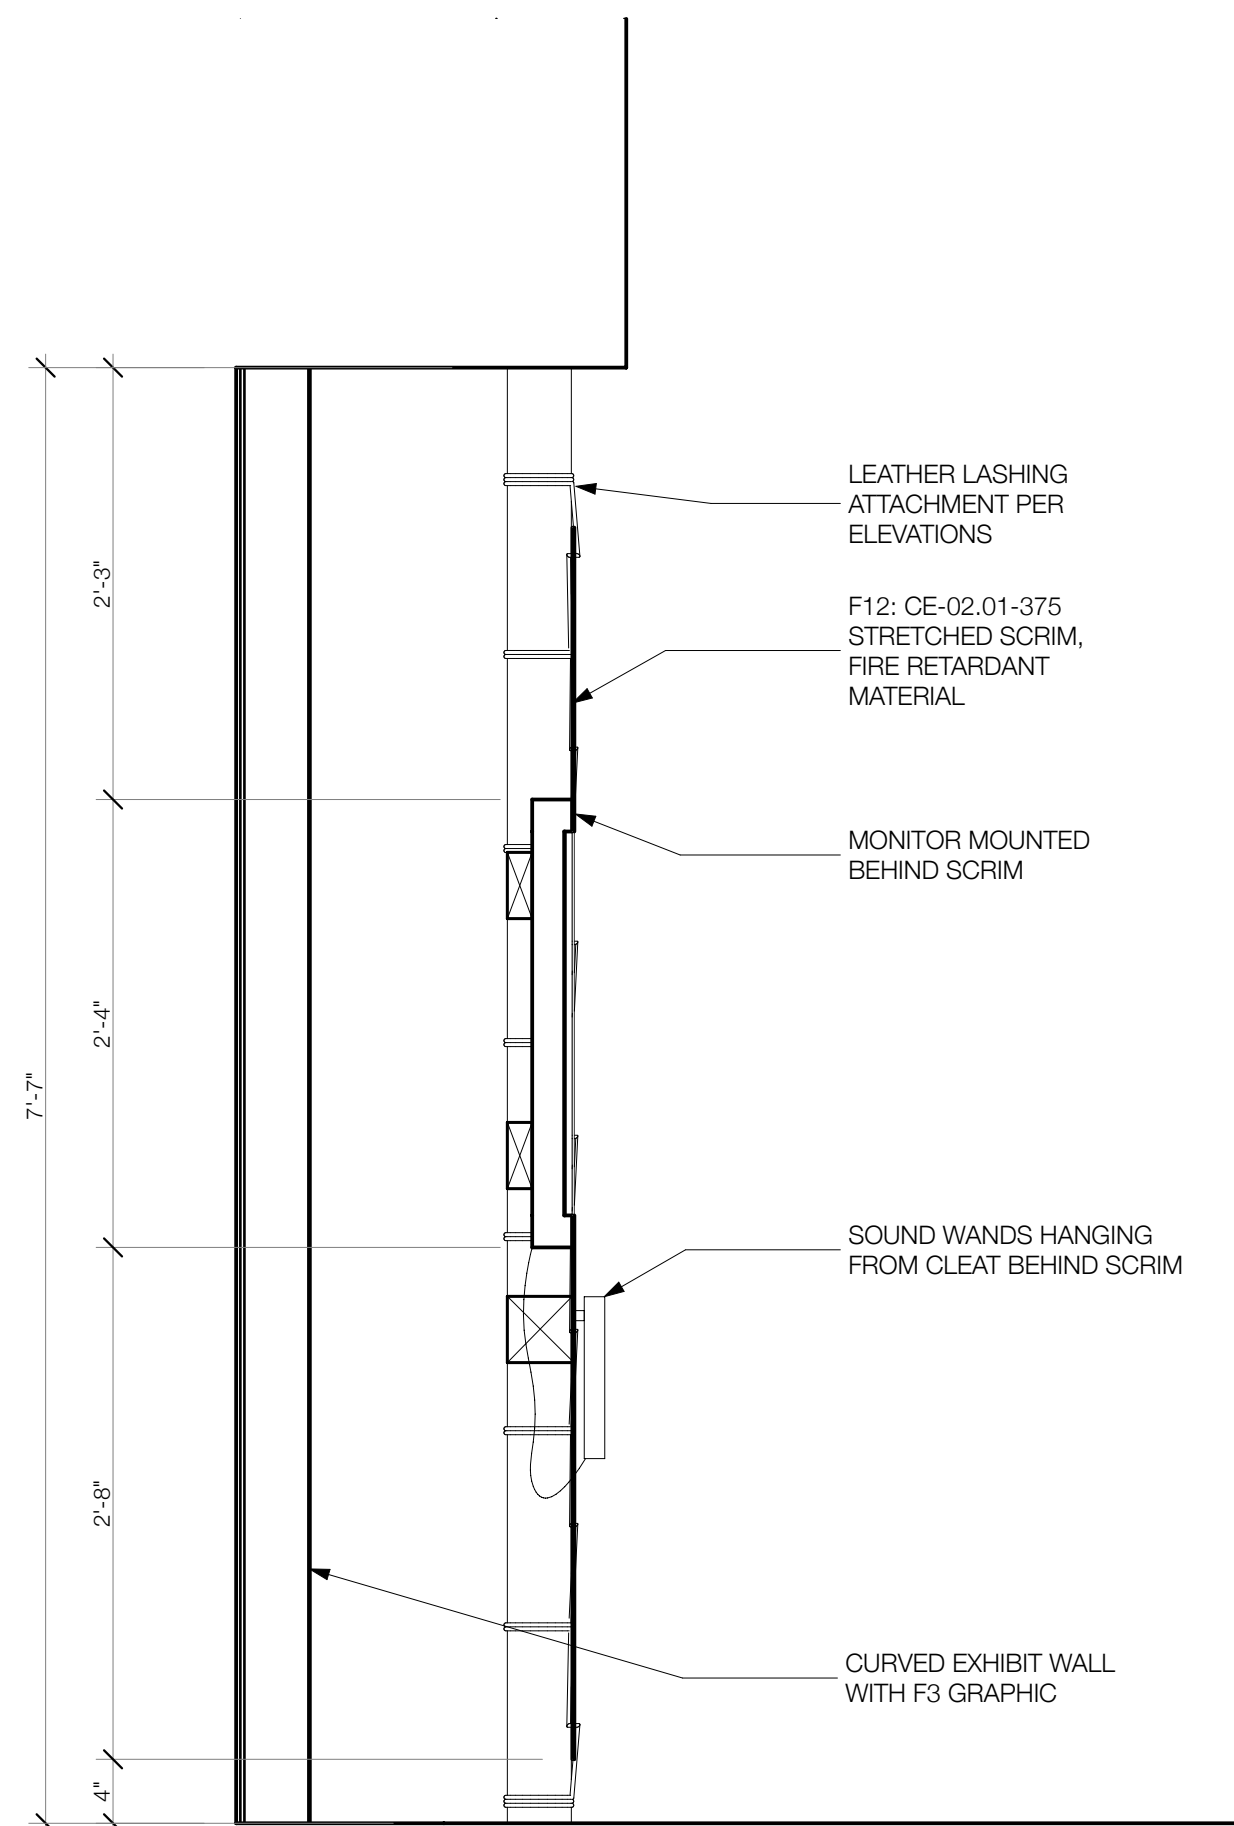MONITOR AND HANGING SCRIM SECTION
SCALE: 1" = 1'-0"

5

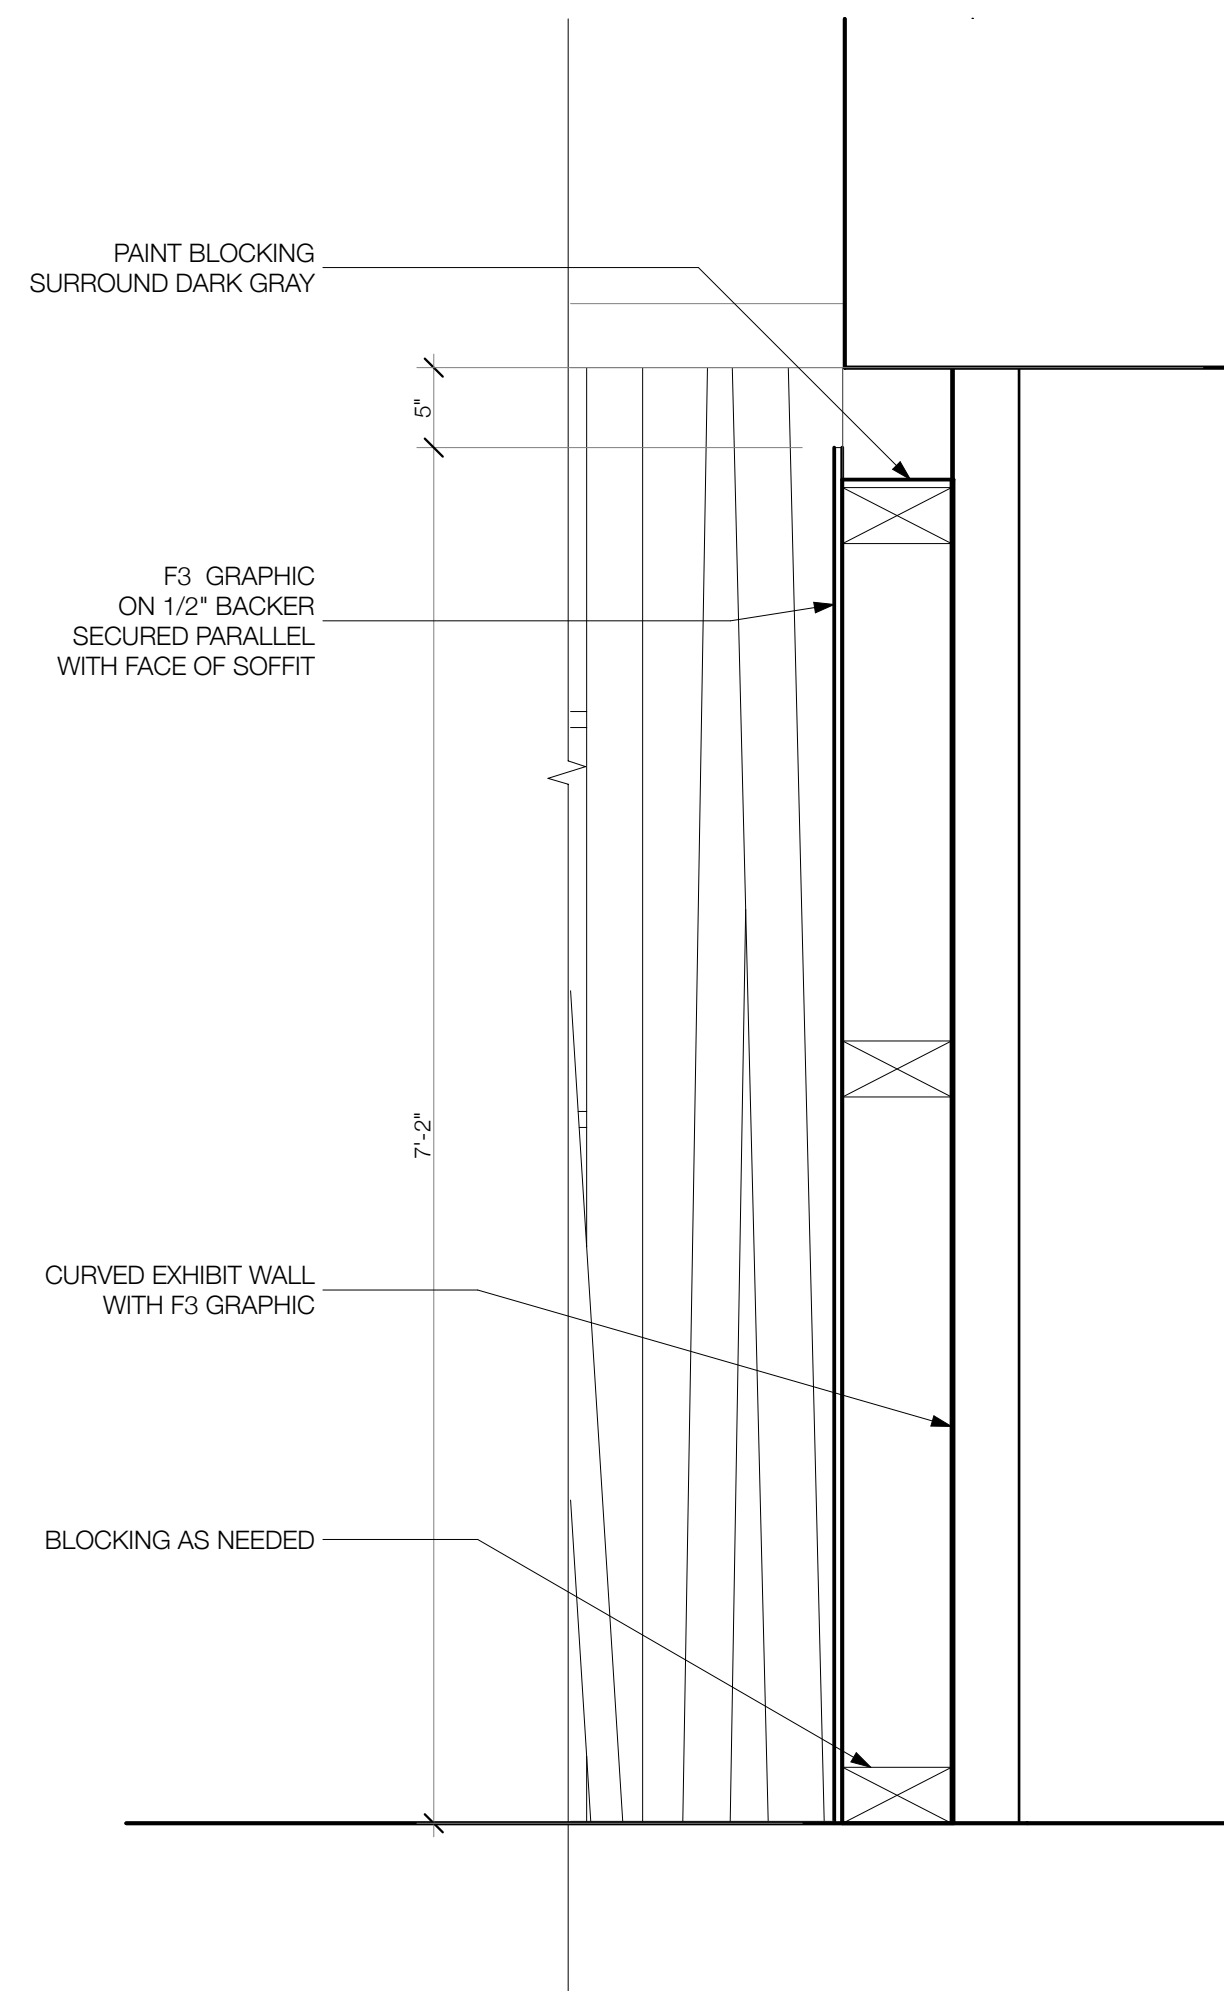TOPIC PANEL SECTION
SCALE: 1" = 1'-0"

3

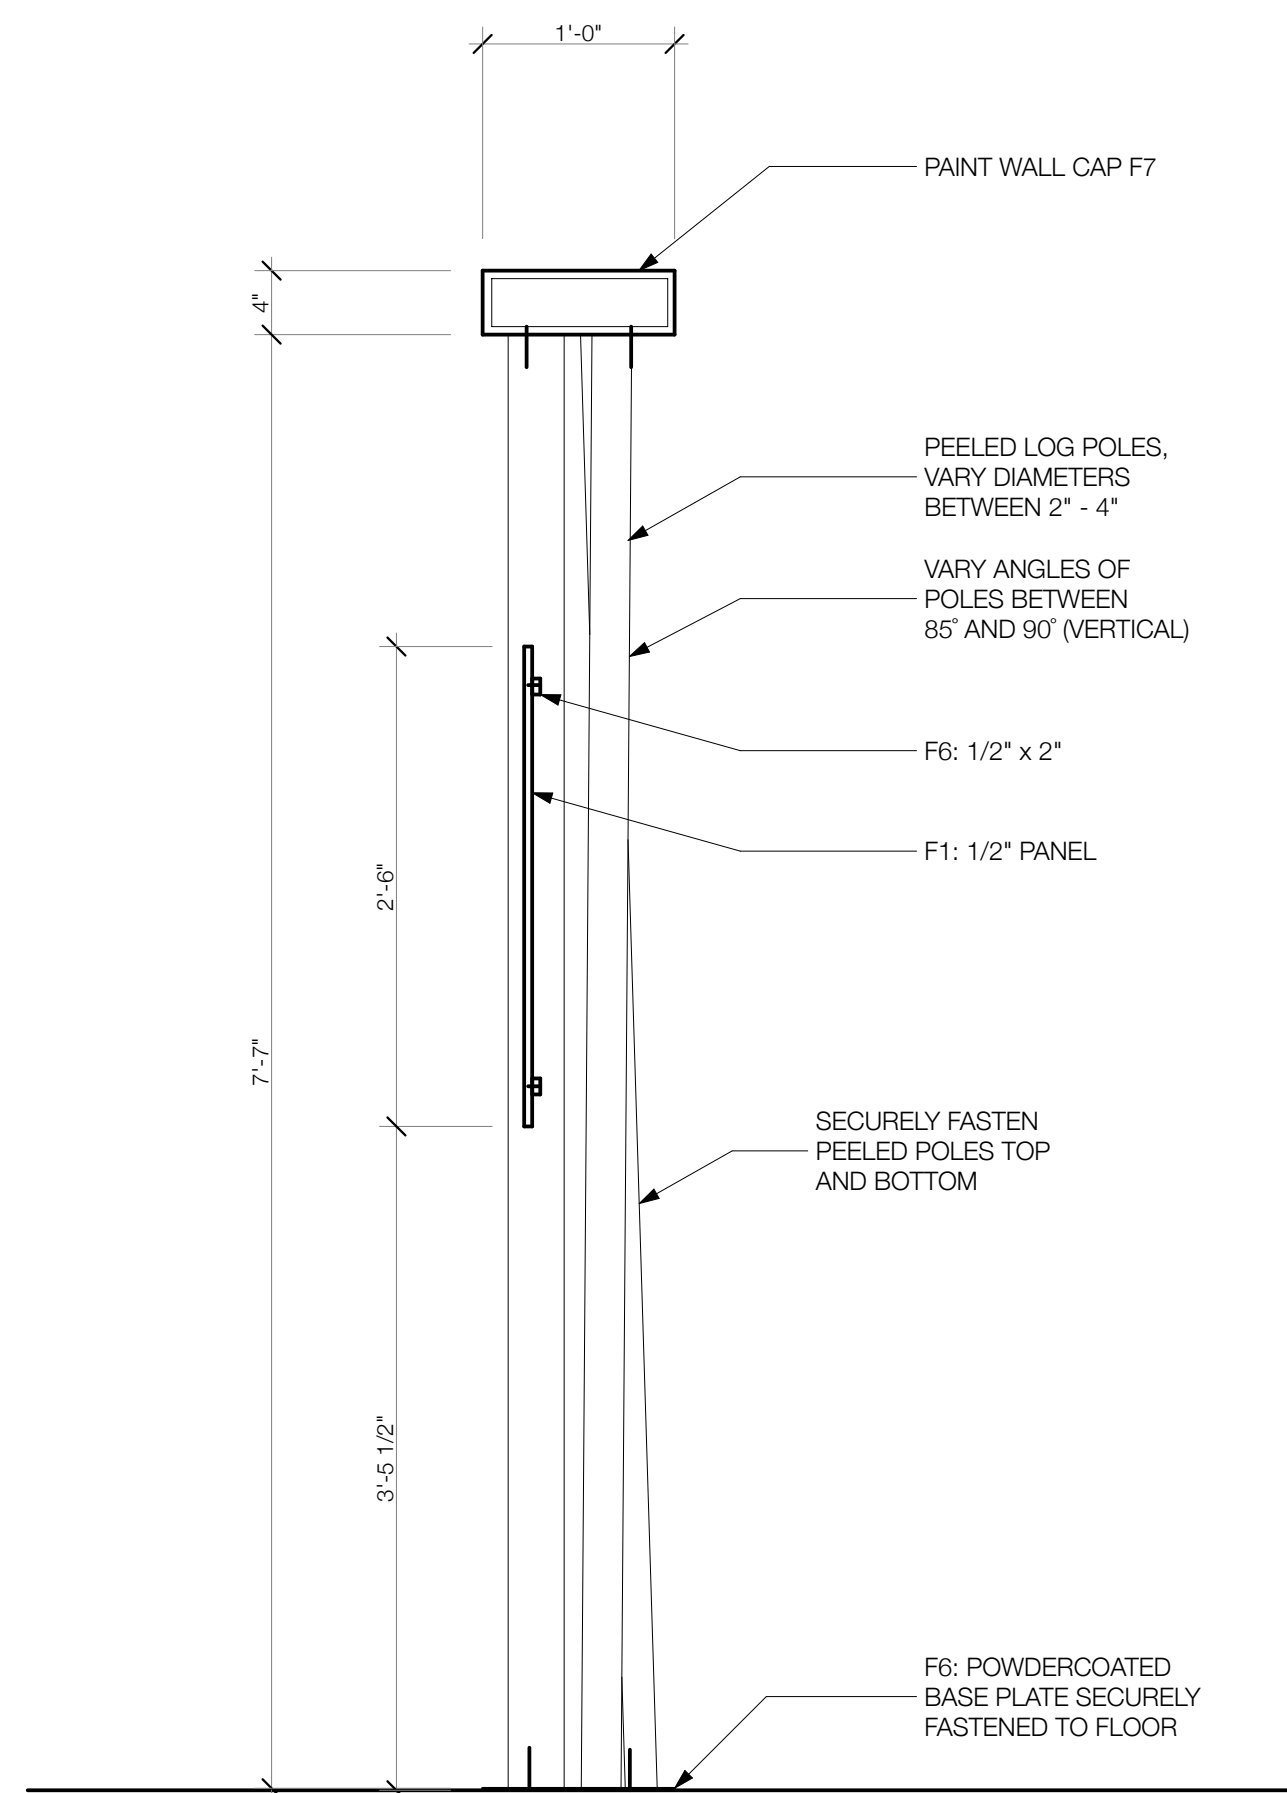PEELED POLE WALL SECTION
SCALE: 1" = 1'-0"


1

PIPES ONE NATIONAL MONUMENT
VISITOR CENTER EXHIBITS

These documents have been
 sent to show the designers'
 tent only. Written dimensions
 shall take precedence over
 scaled dimensions.
 Contractors shall verify and be
 responsible for all dimensions
 and conditions on the job, and
 this office must be notified of
 any variations from the
 dimensions and conditions
 shown by these drawings.
 Shop details must be
 submitted to this office before
 beginning fabrication. All ideas,
 designs, and arrangements
 indicated on these drawings
 are the property of EDX and
 are intended for the sole use of
 the client noted.


A07

SHEET 7 OF 14

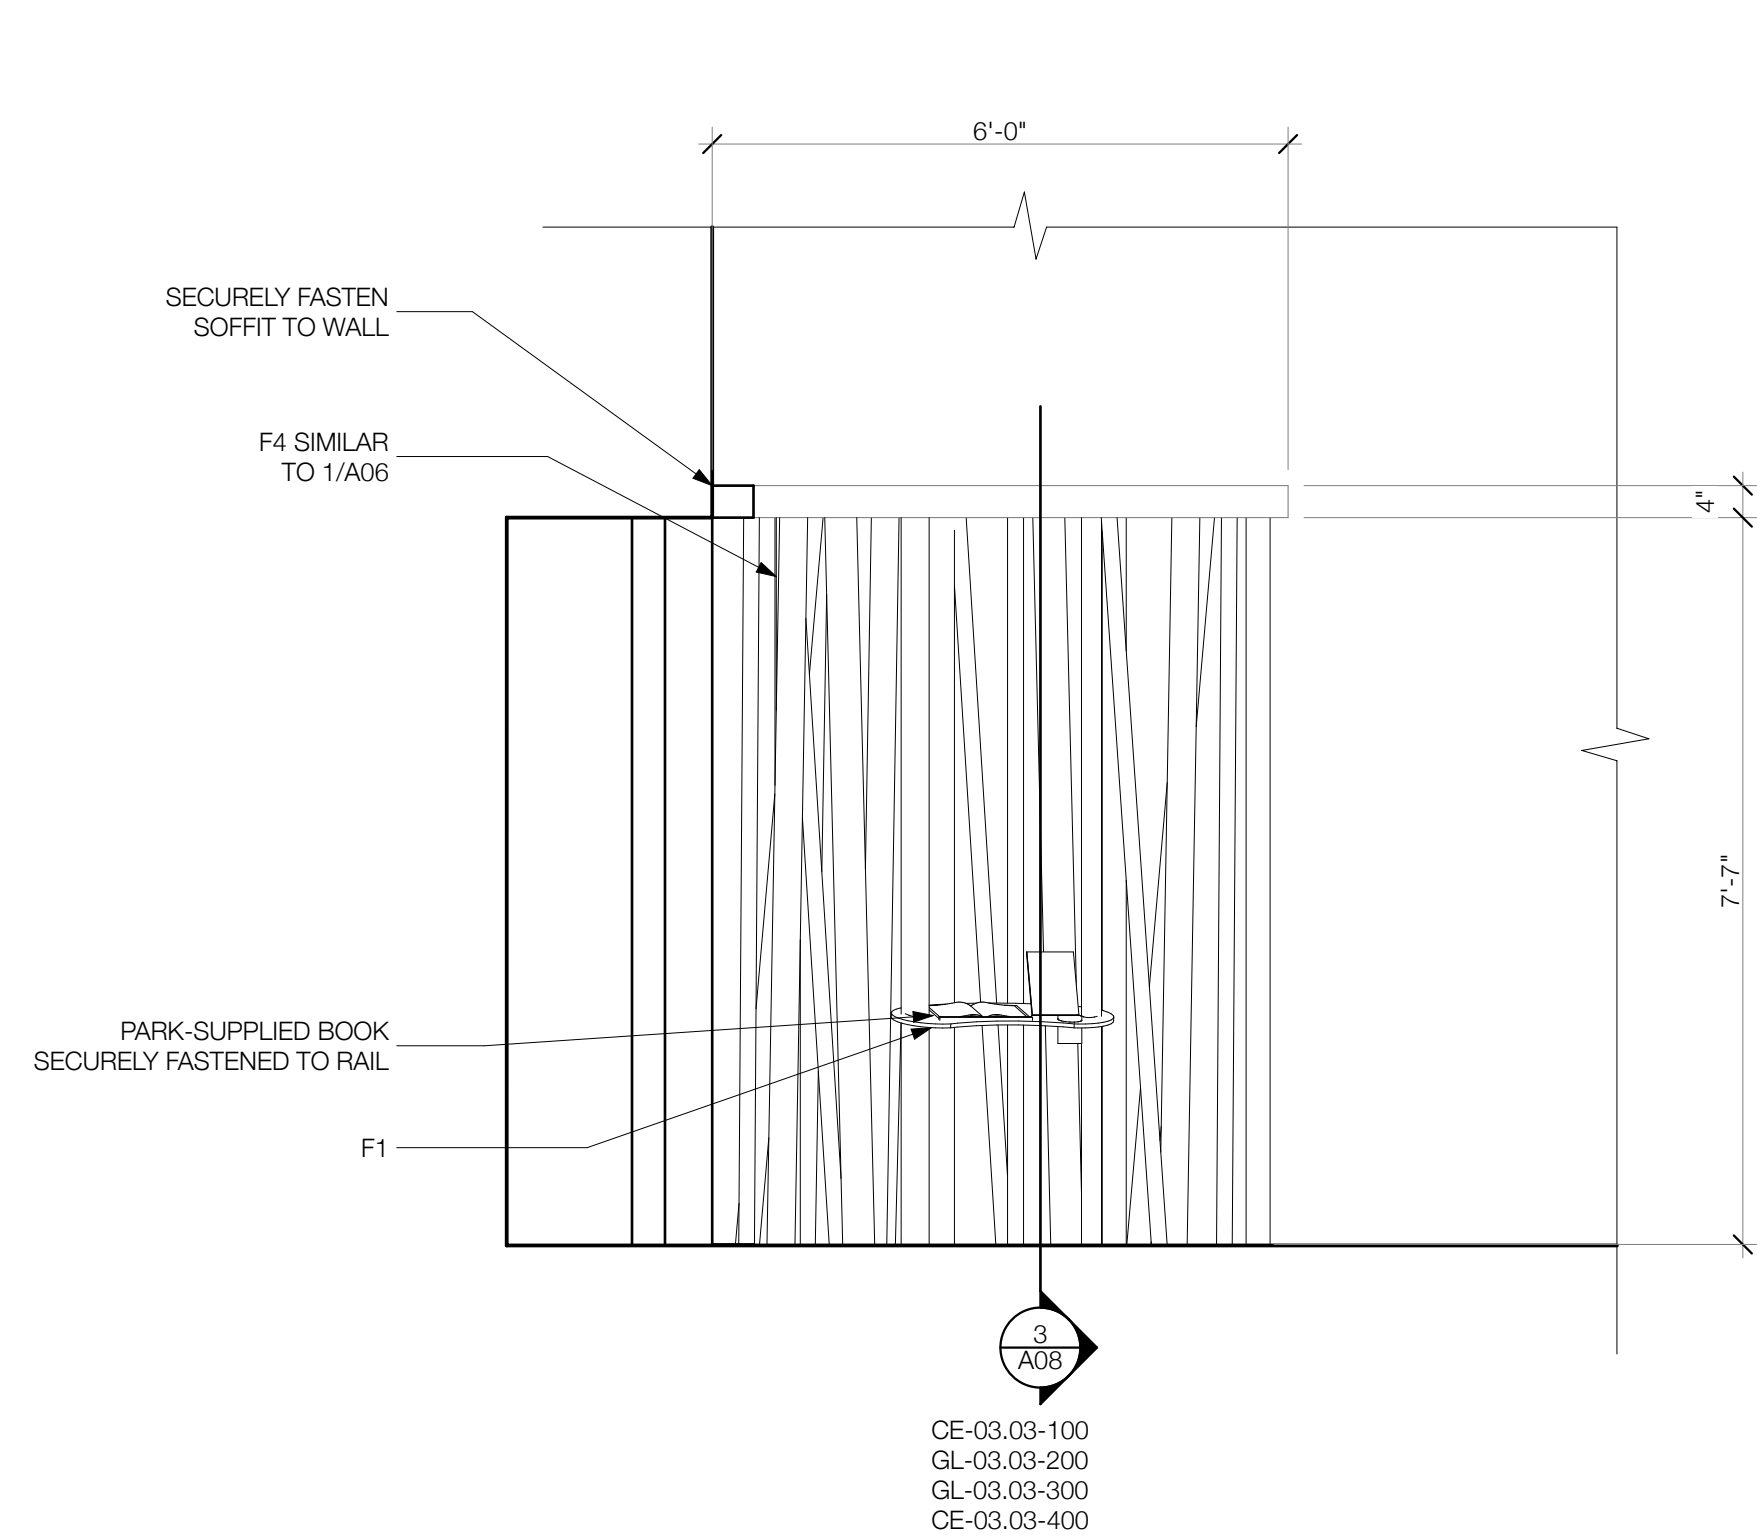


RESPONSE STATION ELEVATION
SCALE: 1/2" = 1'-0"

③

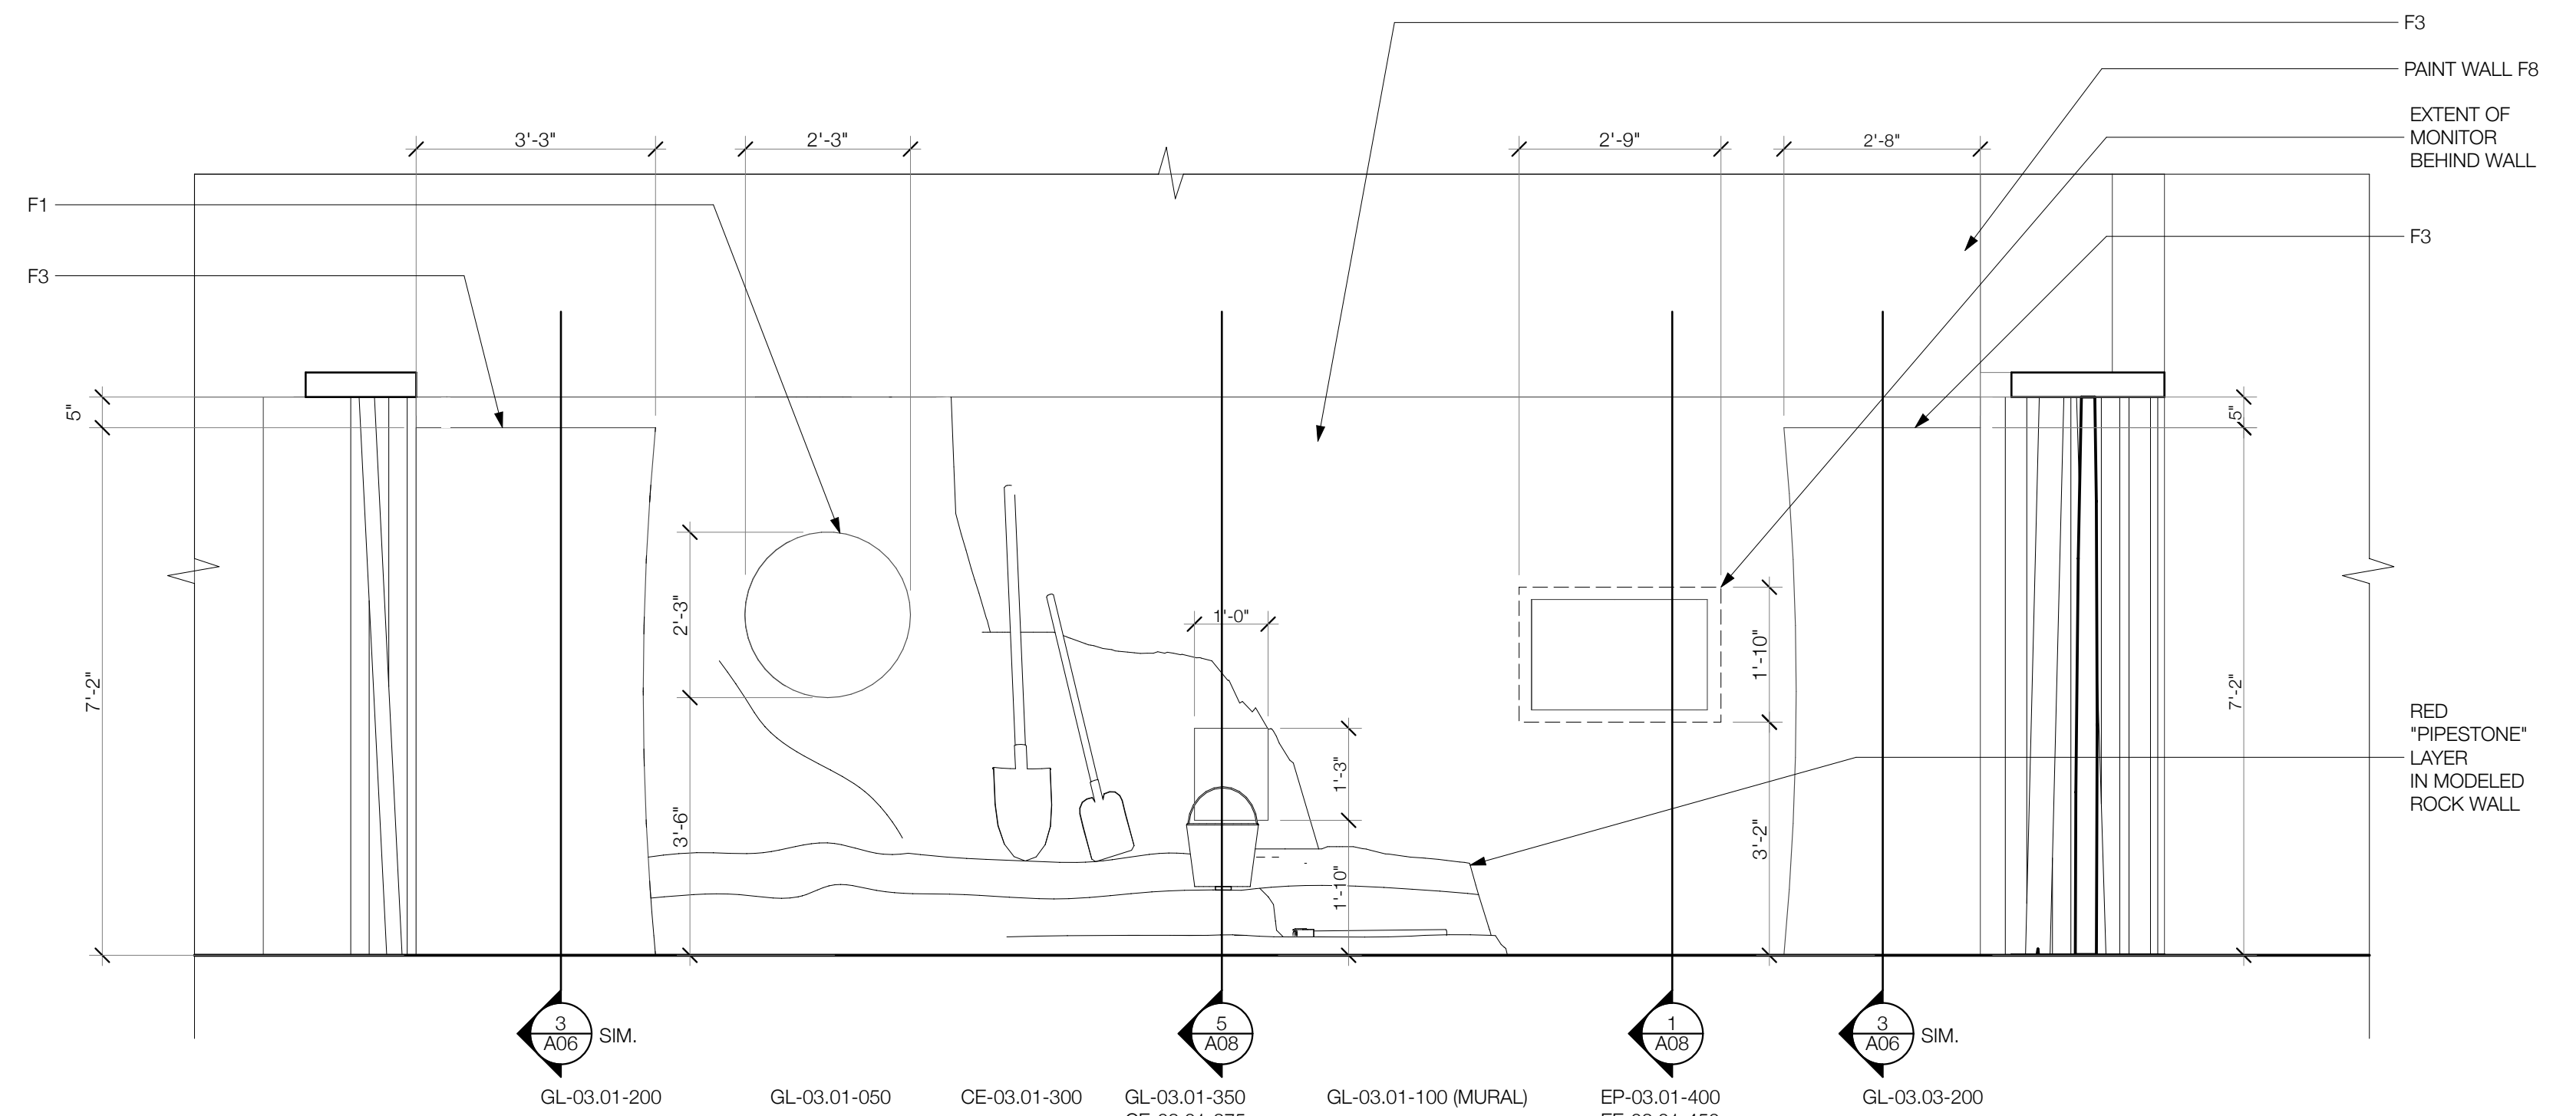

ROCK WALL ELEVATION
SCALE: 1/2" = 1'-0"

②

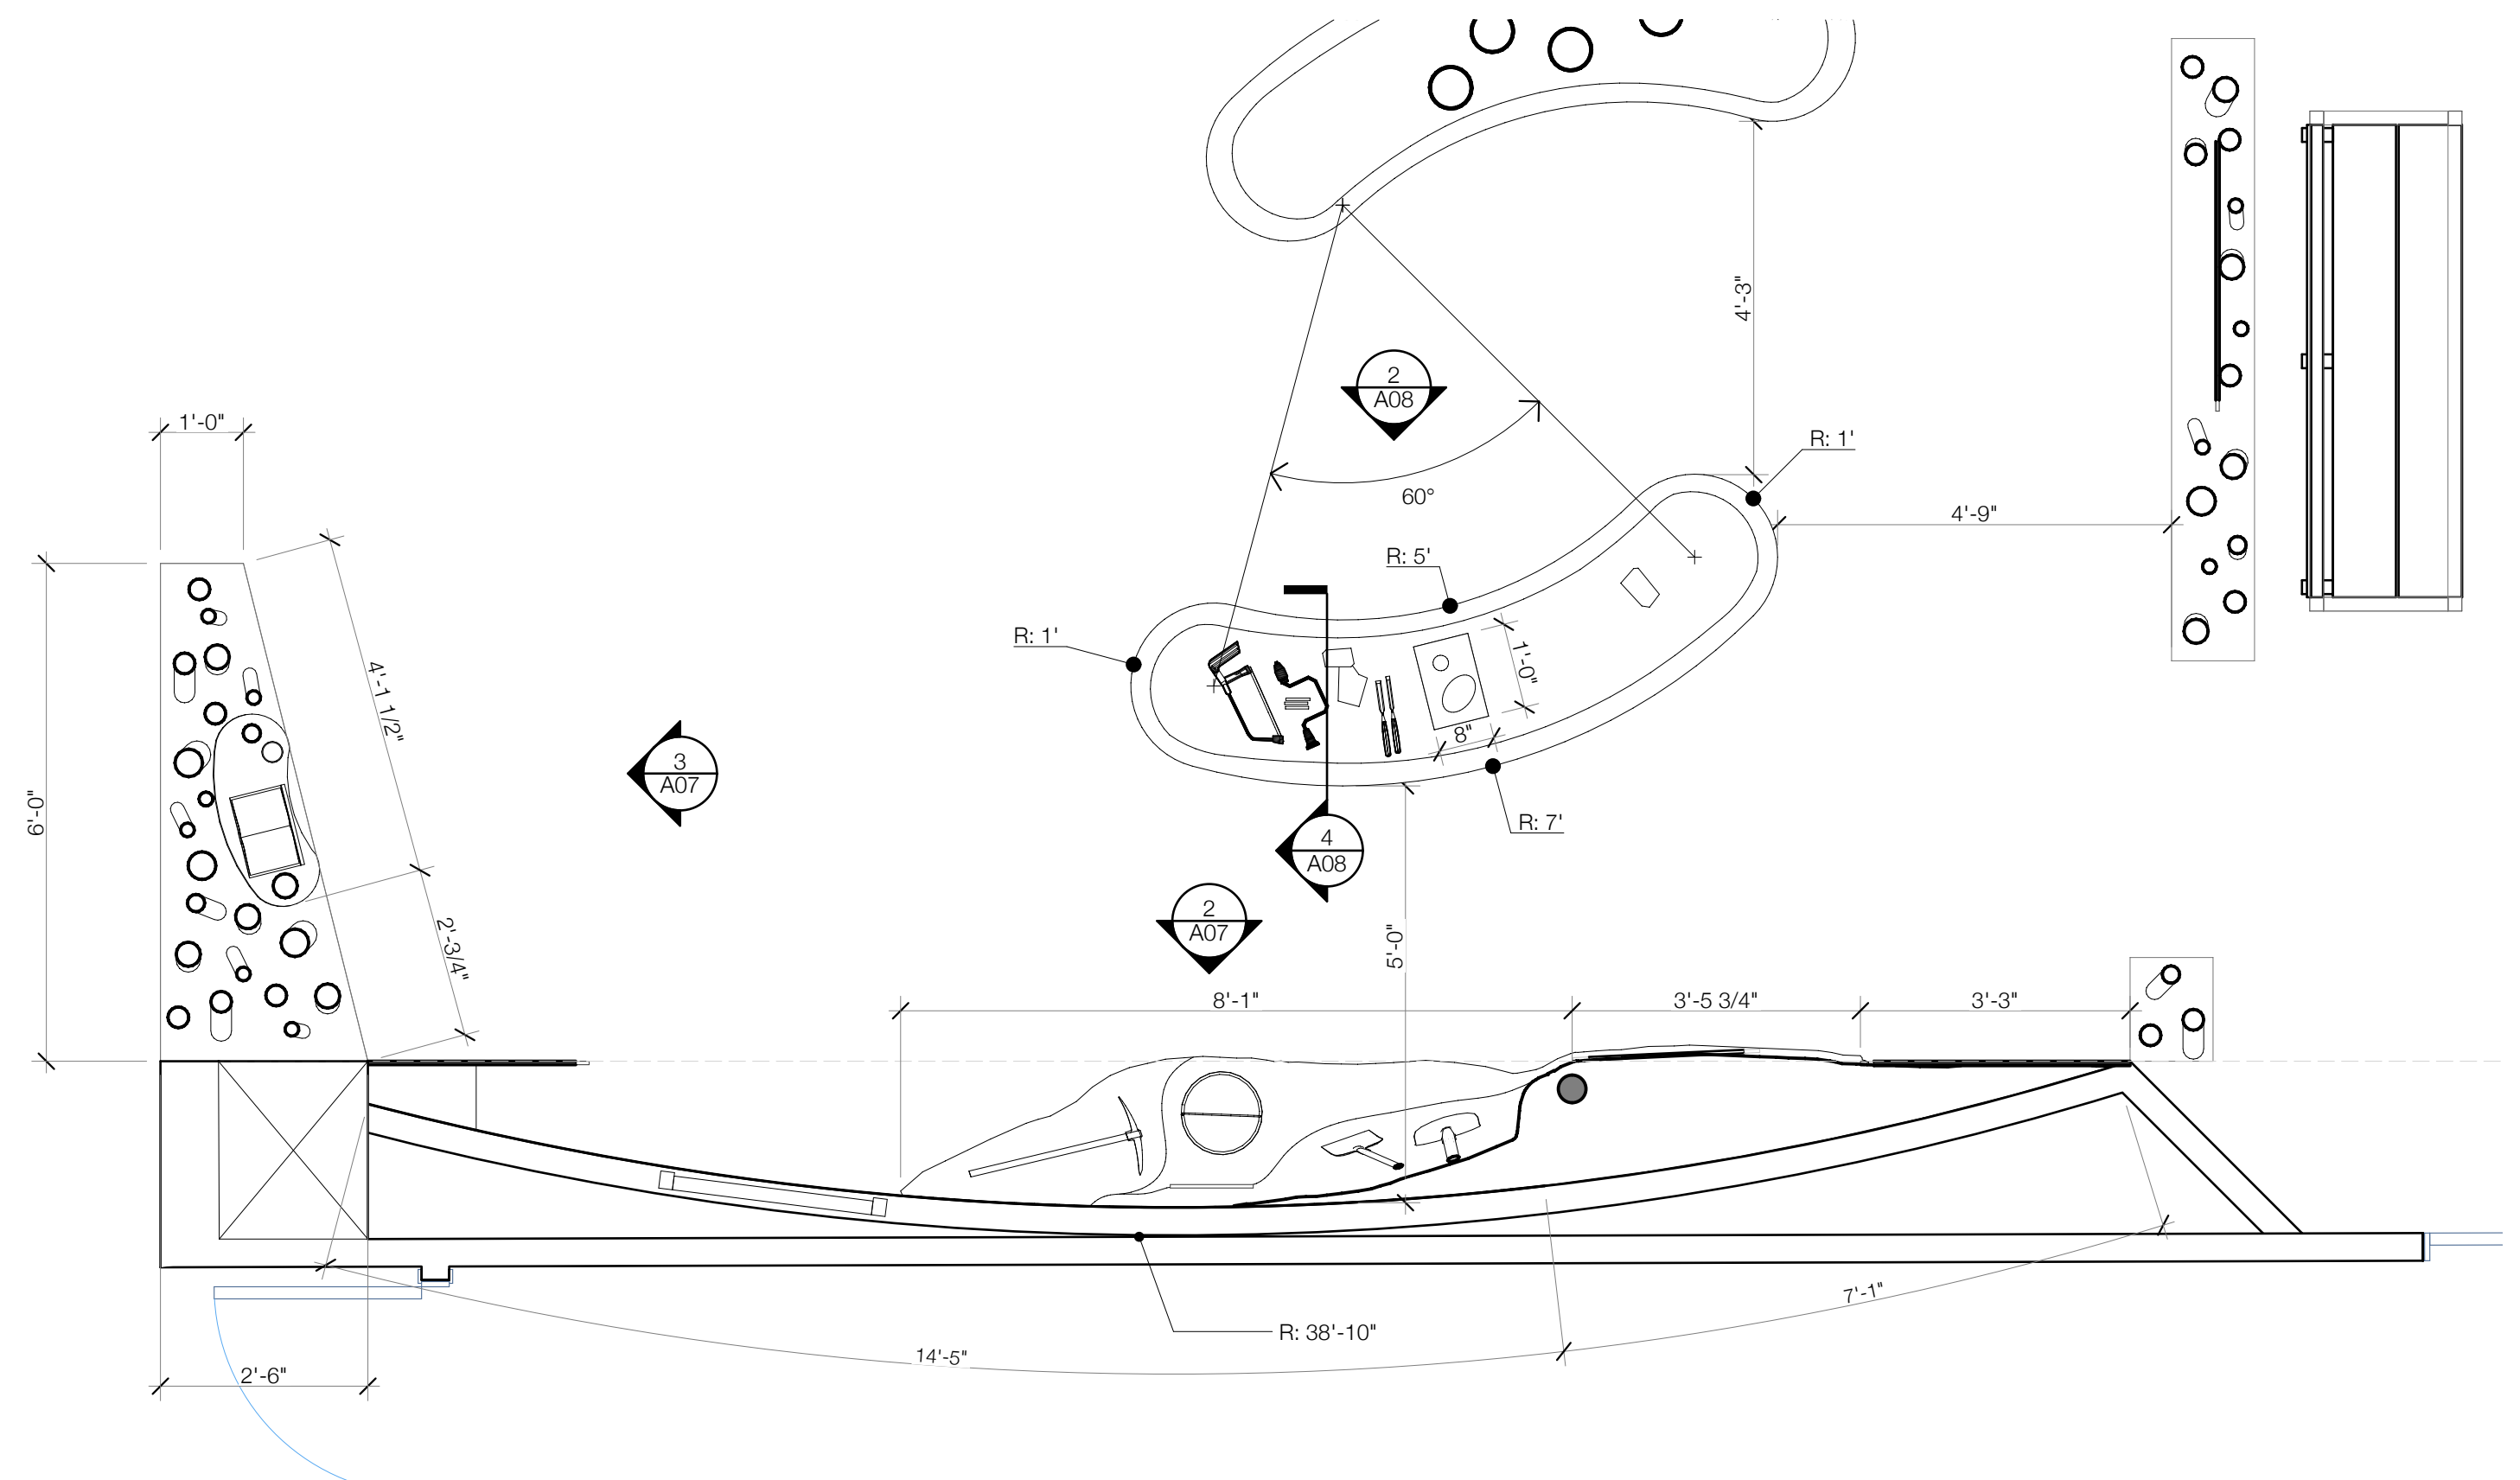

SCENE 03 QUARRYING AND CARVING PLAN

1



SCENE 03
DETAILS

Title:

DD2

Revision #:

6/14/18


Date:

PIPESTONE NATIONAL MONUMENT
VISITOR CENTER EXHIBITS


These documents have been created to show the designers' intent only. Written dimensions shall take precedence over scaled dimensions. Contractors shall verify and be responsible for all dimensions and conditions on the job, and this office must be notified of any variations from the dimensions and conditions shown by these drawings. Shop details must be submitted to this office before beginning fabrication. All ideas, designs, and arrangements indicated on these drawings are the property of EDX and are intended for the sole use of the client noted.

A08


SHEET 8 OF 14

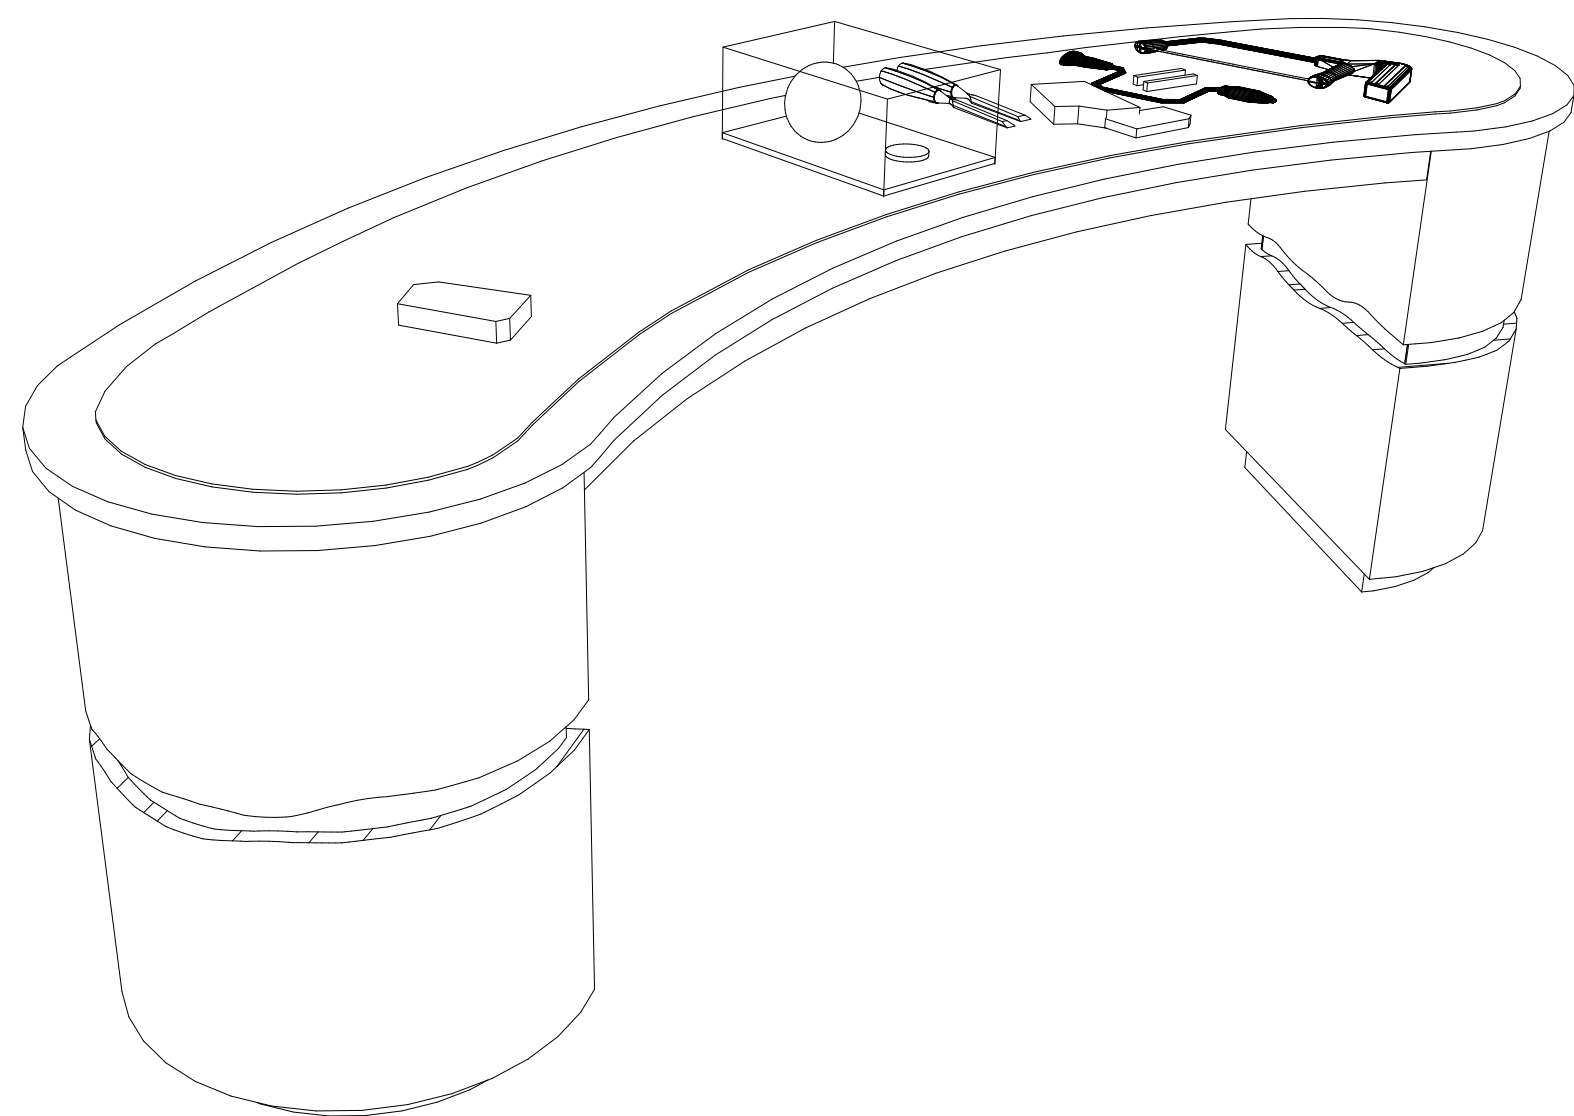CARVING TABLE AXONOMETRY
SCALE: 1:80


6

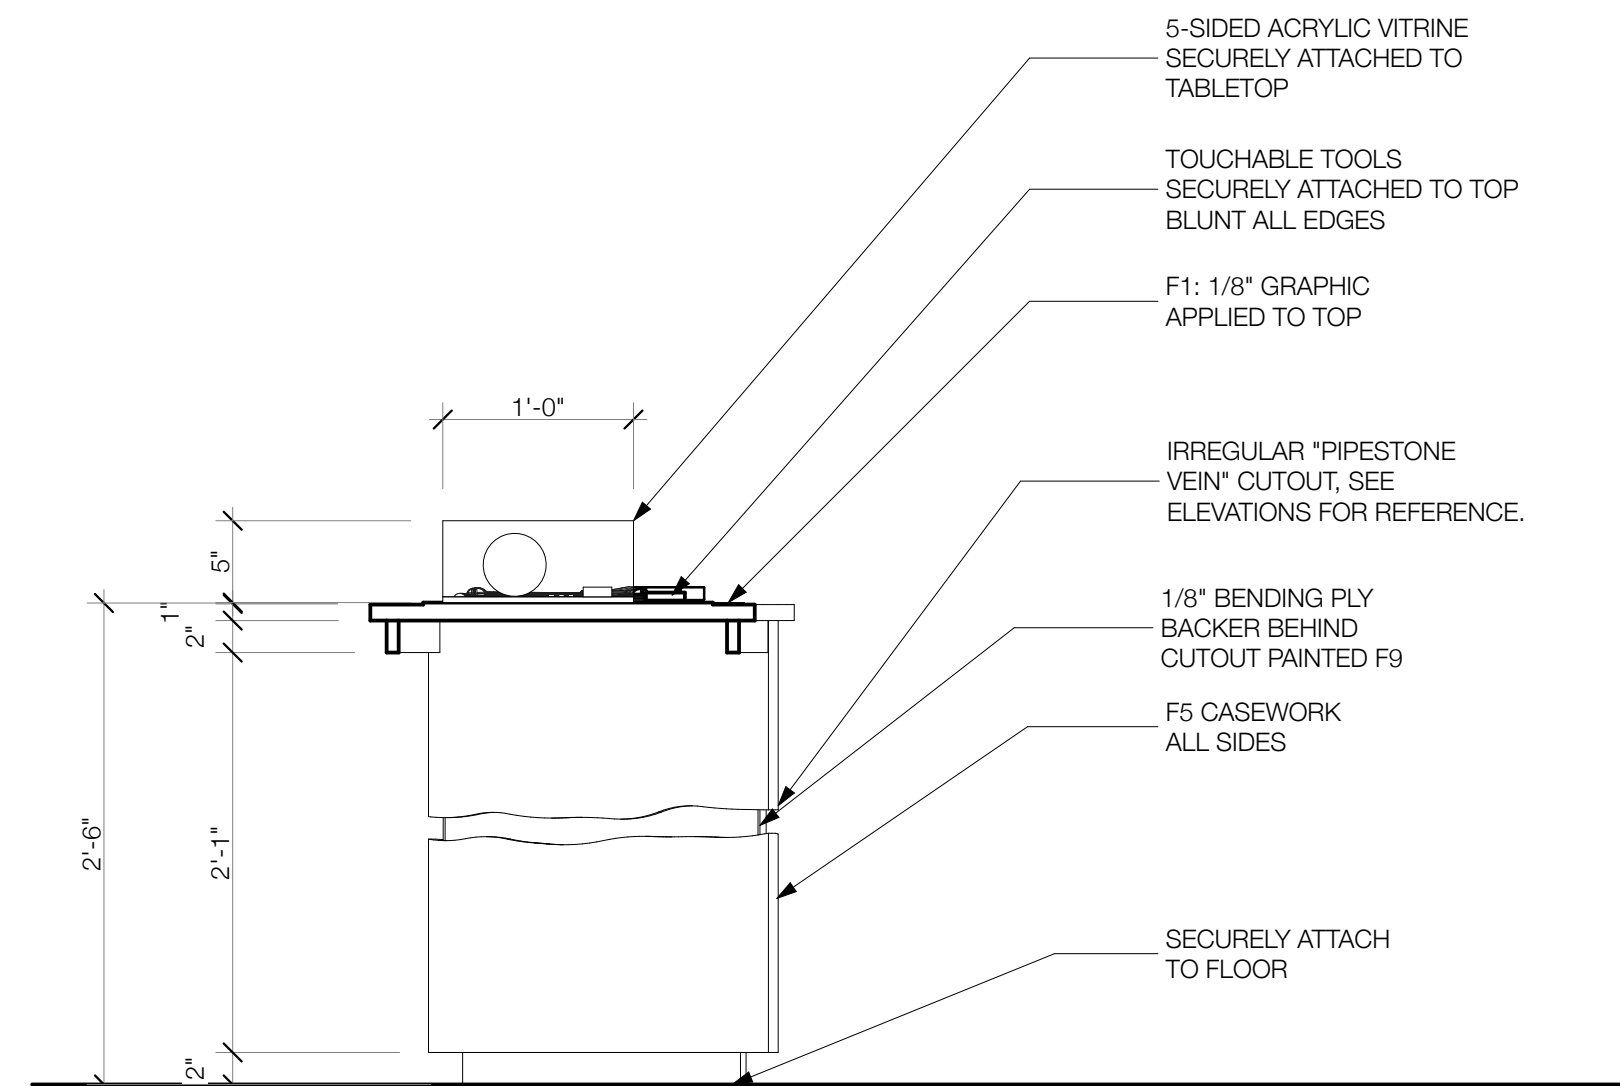CARVING TABLE SECTION
SCALE: 1" = 1'-0"


4

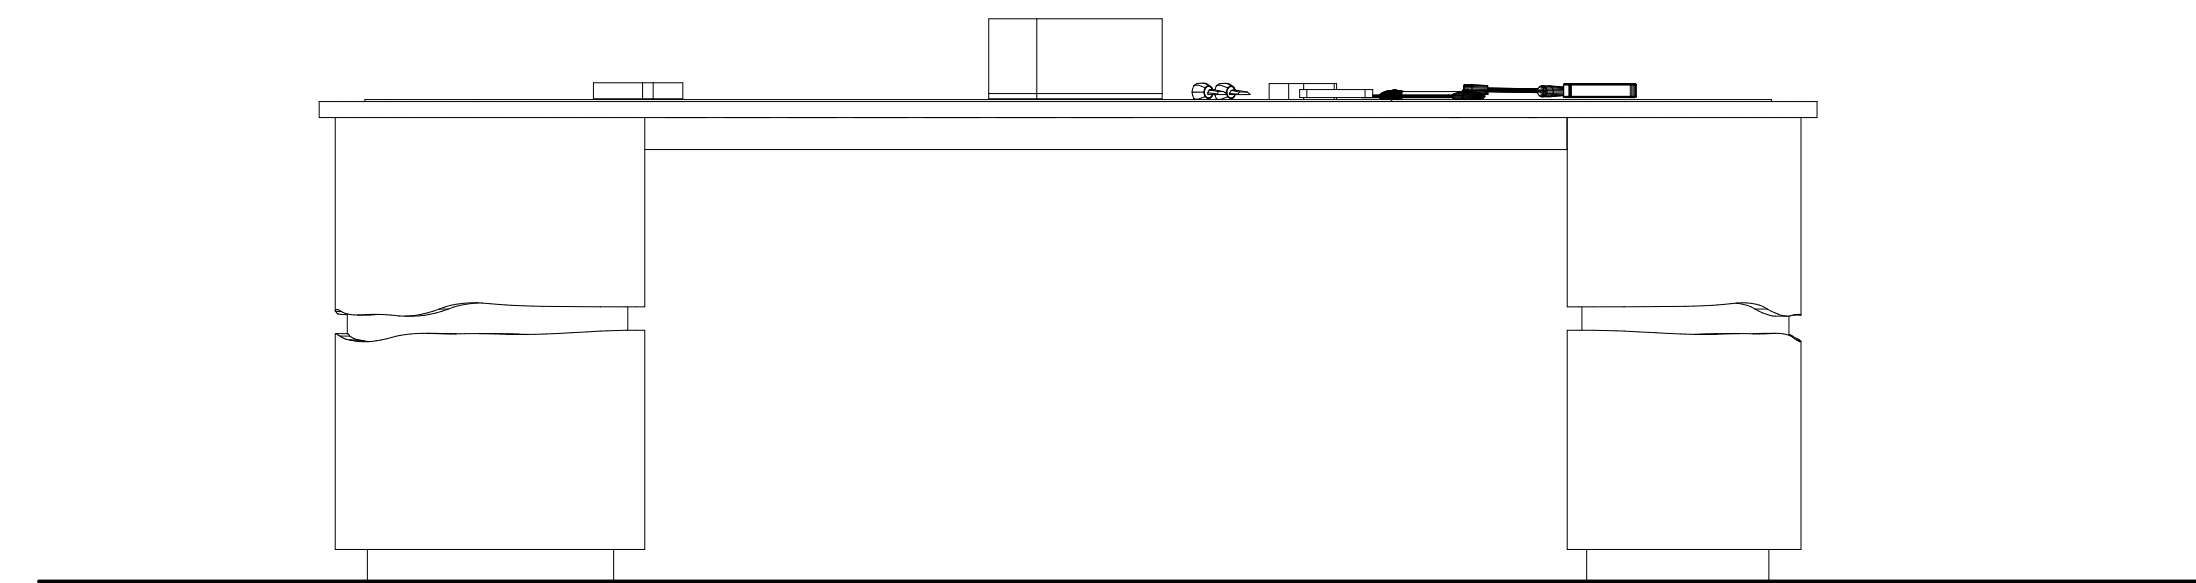CARVING TABLE ELEVATION
SCALE: 1" = 1'-0"


2

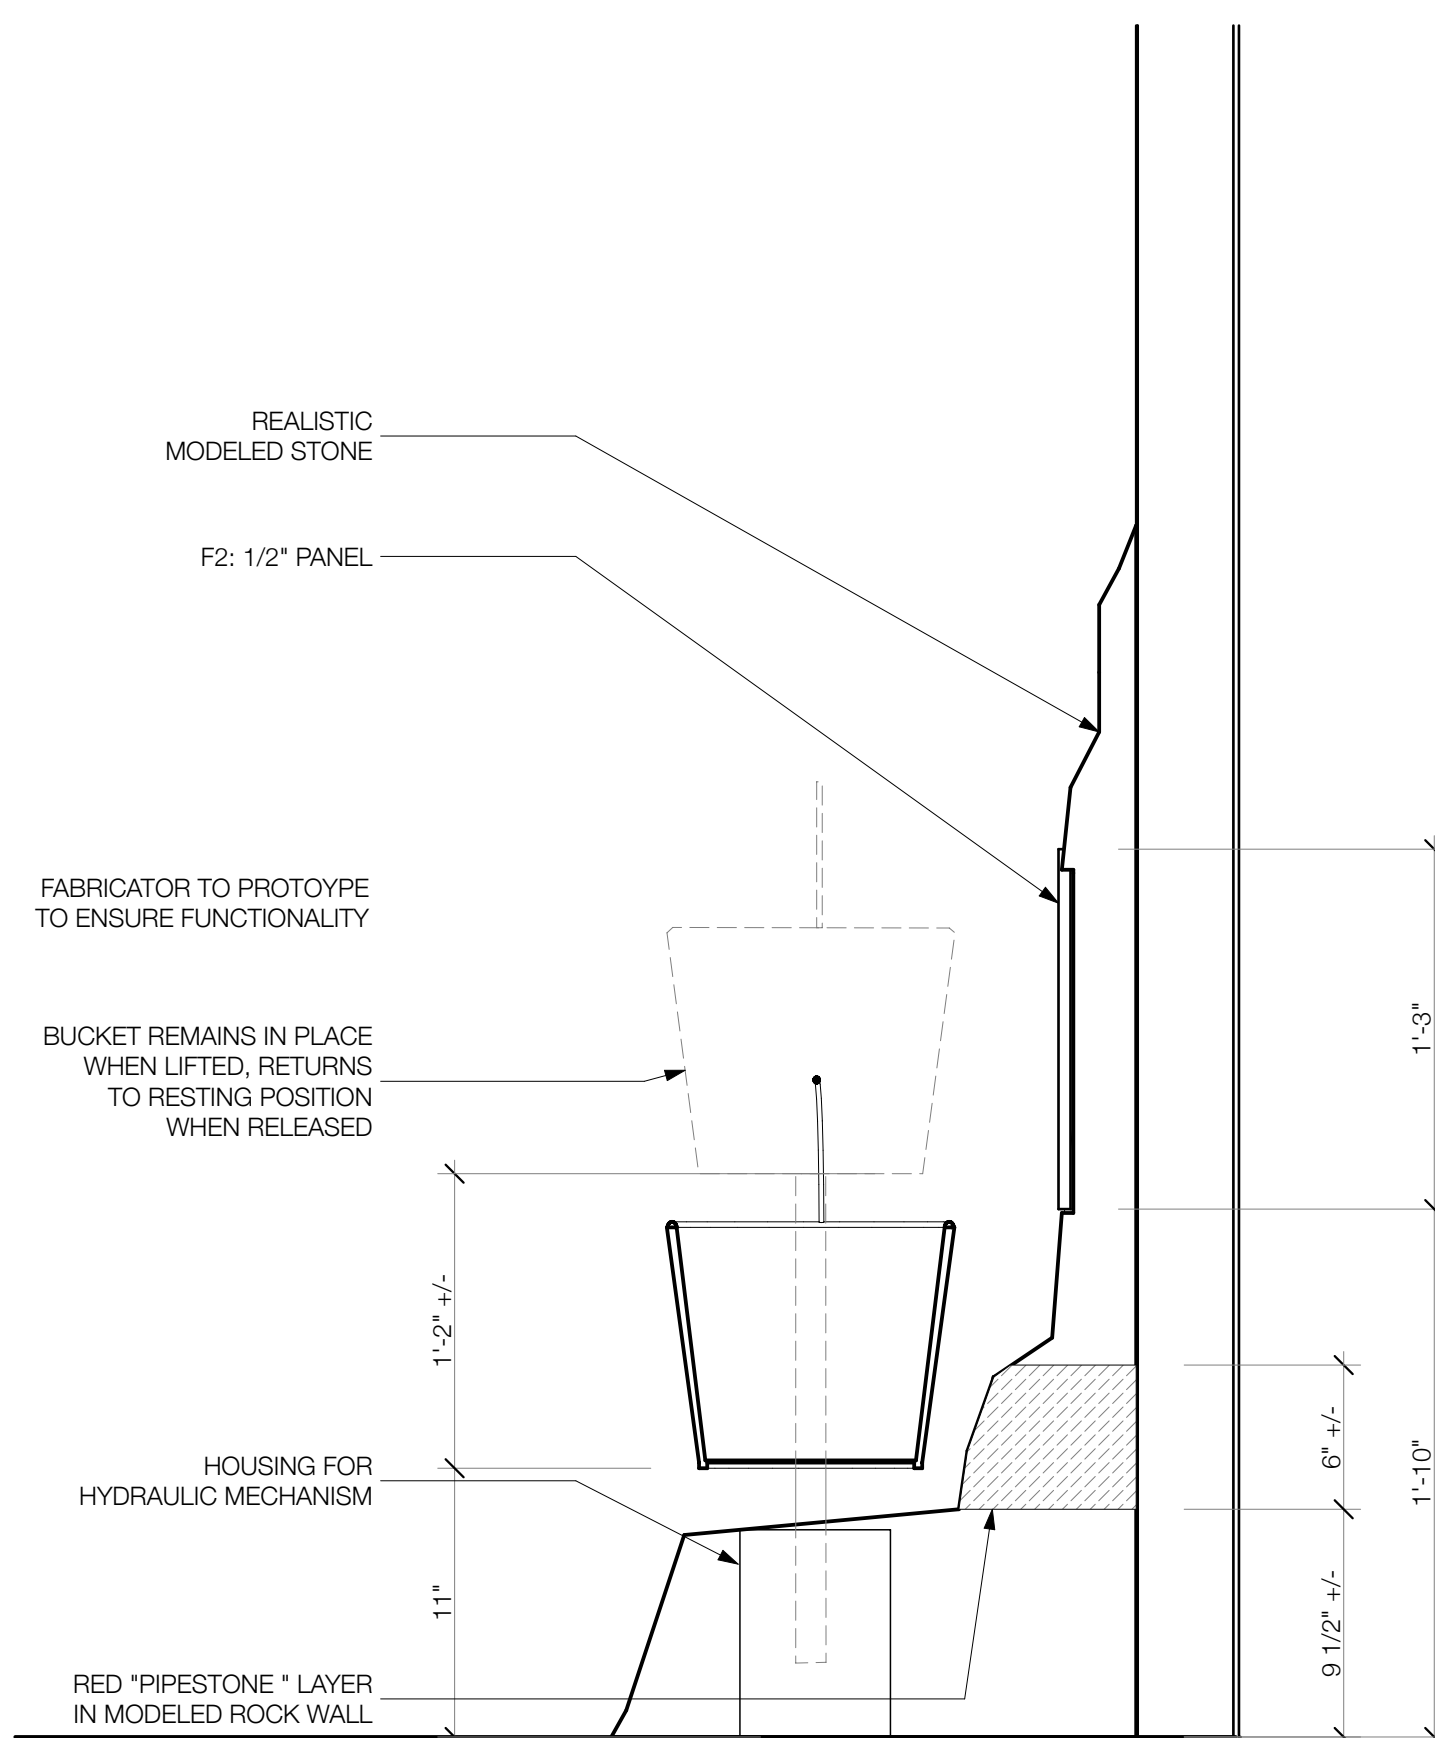LIFTING BUCKET DETAIL
SCALE: 1 1/2" = 1'-0"

5

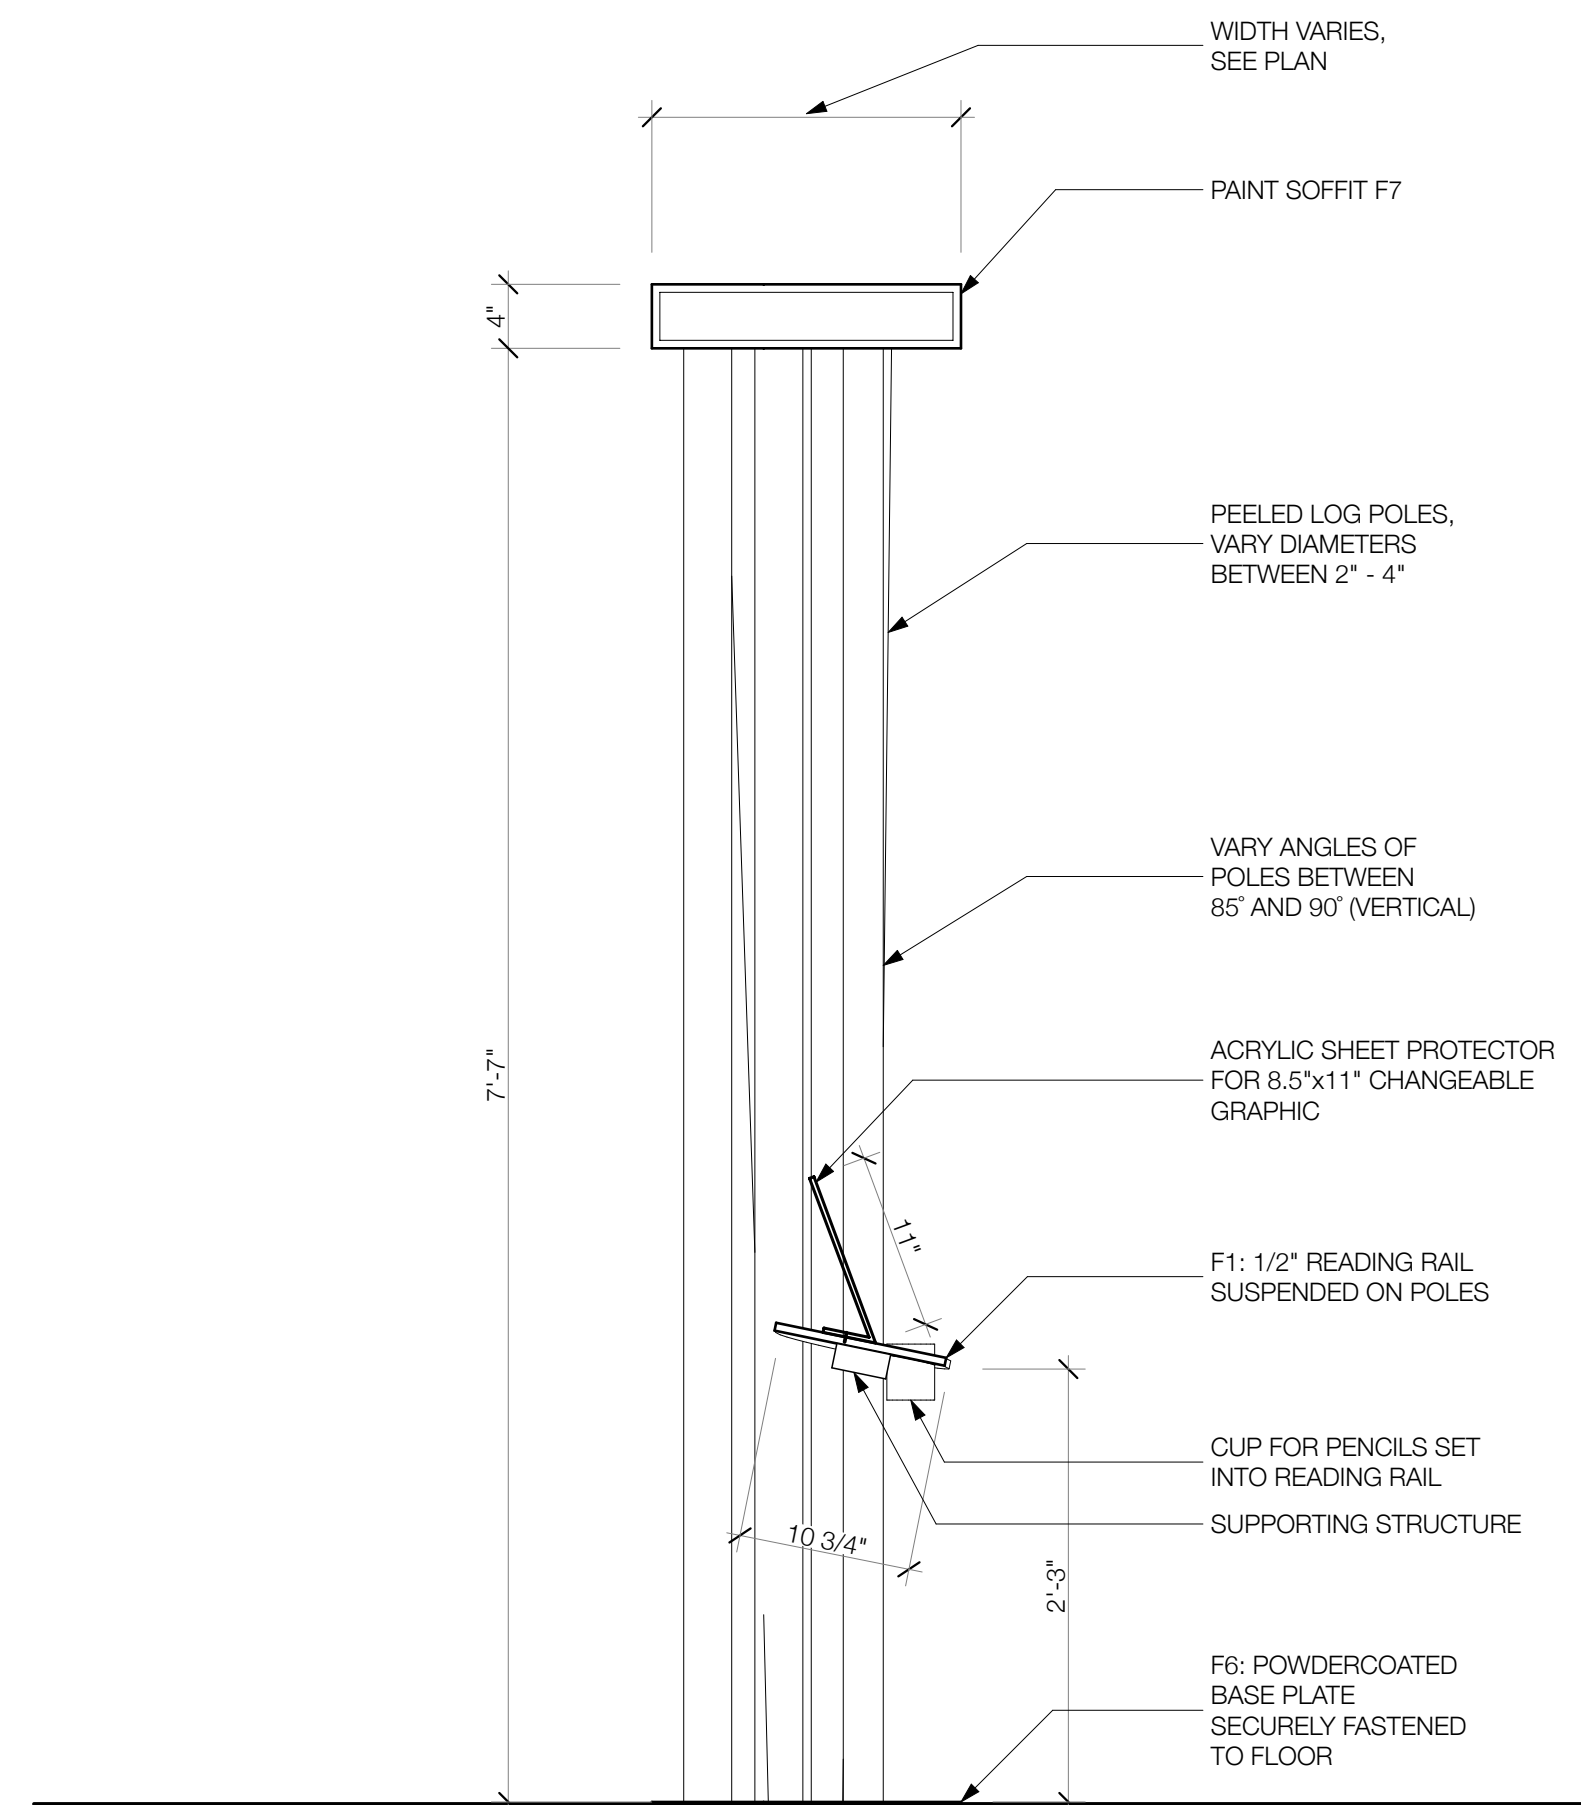RESPONSE STATION READING RAIL SECTION
SCALE: 1" = 1'-0"

3

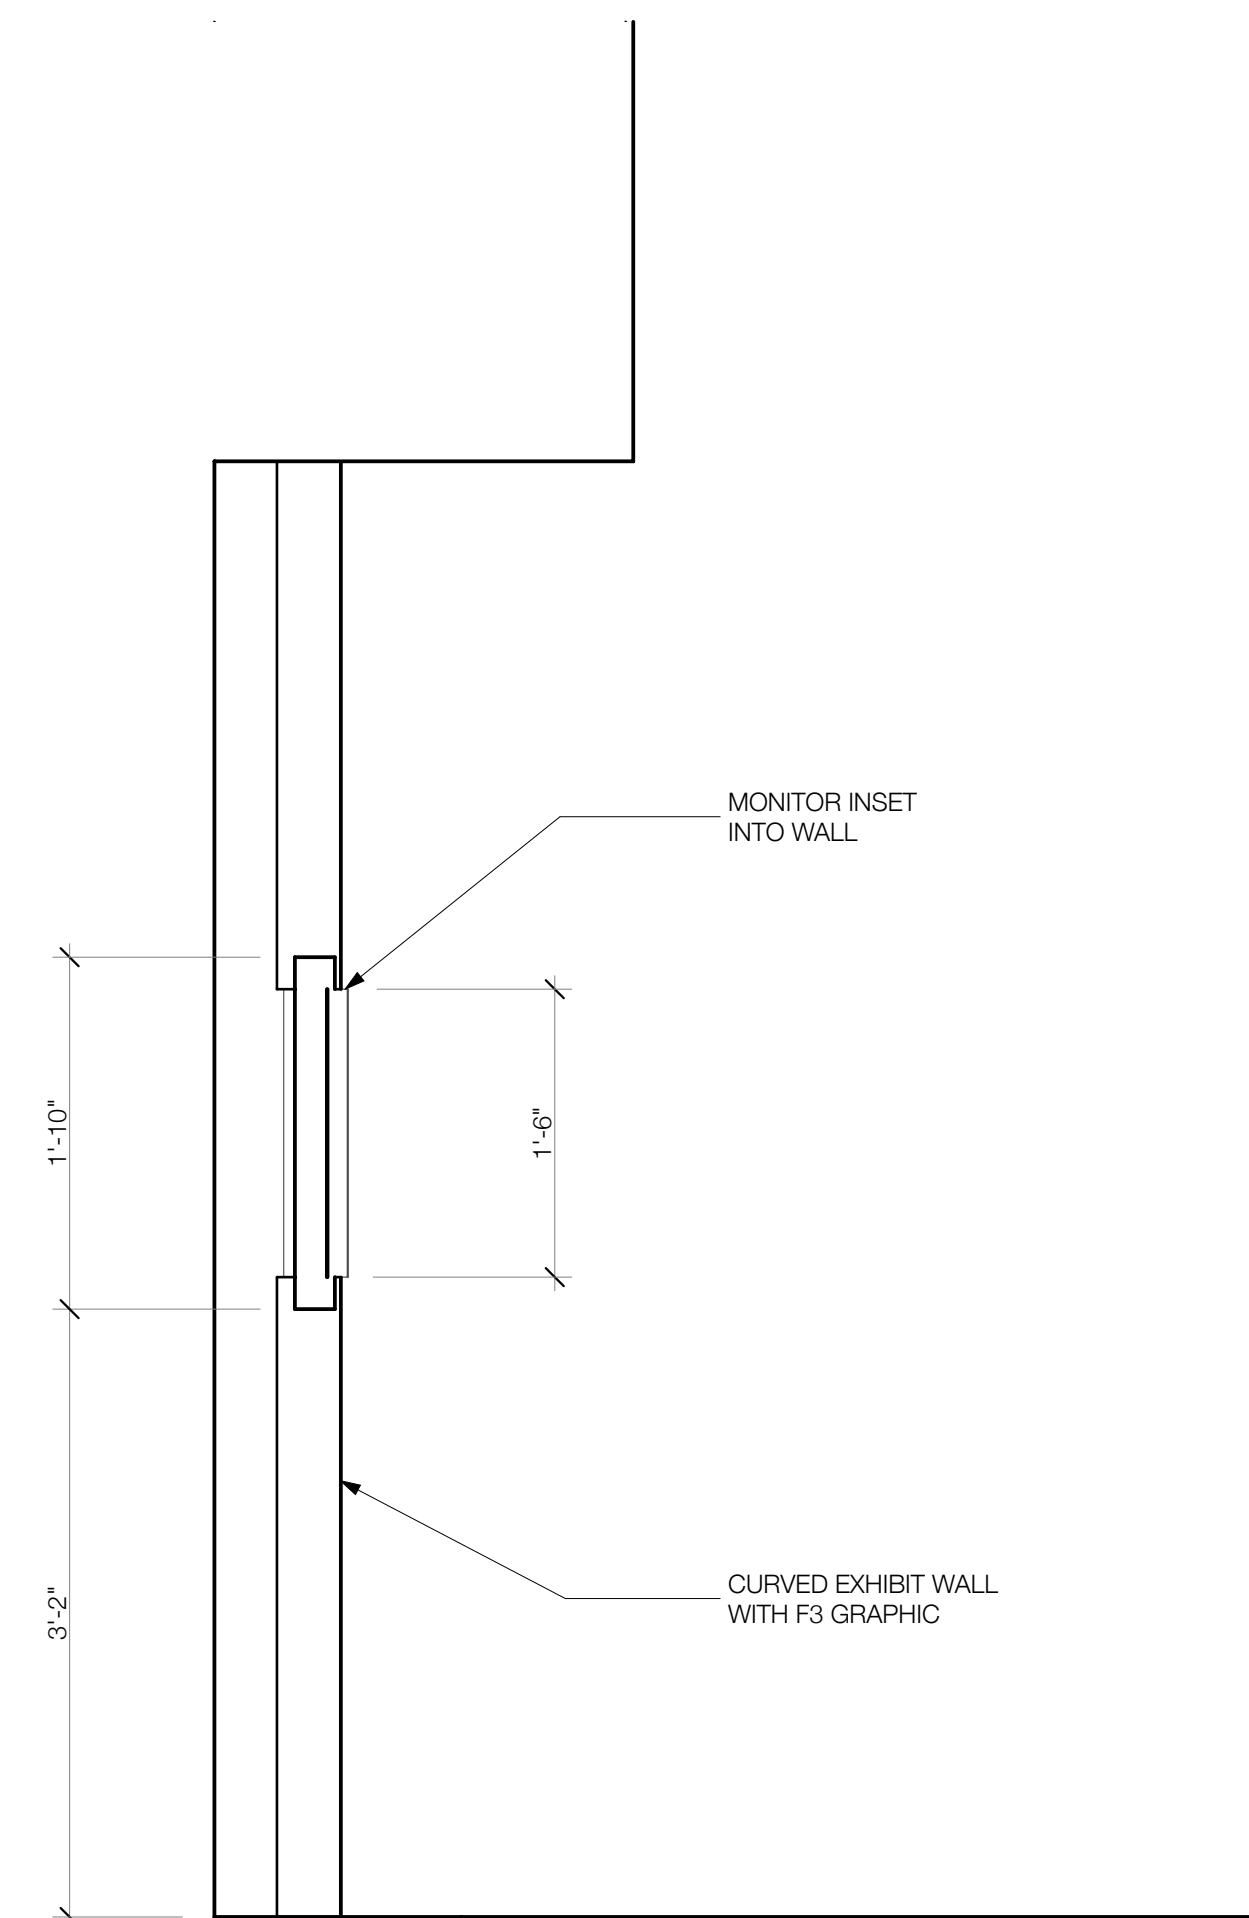MONITOR IN WALL SECTION
SCALE: 1" = 1'-0"




1

PIPESTONE NATIONAL MONUMENT
VISITOR CENTER EXHIBITS

These documents have been created to show the designers' intent only. Written dimensions shall take precedence over scaled dimensions. Contractors shall verify and be responsible for all dimensions and conditions on the job, and this office must be notified of any variations from the dimensions and conditions shown by these drawings. Shop details must be submitted to this office before beginning fabrication. All ideas, designs, and arrangements indicated on these drawings are the property of EDX and are intended for the sole use of the client noted.

A09

SHEET 9 OF 14

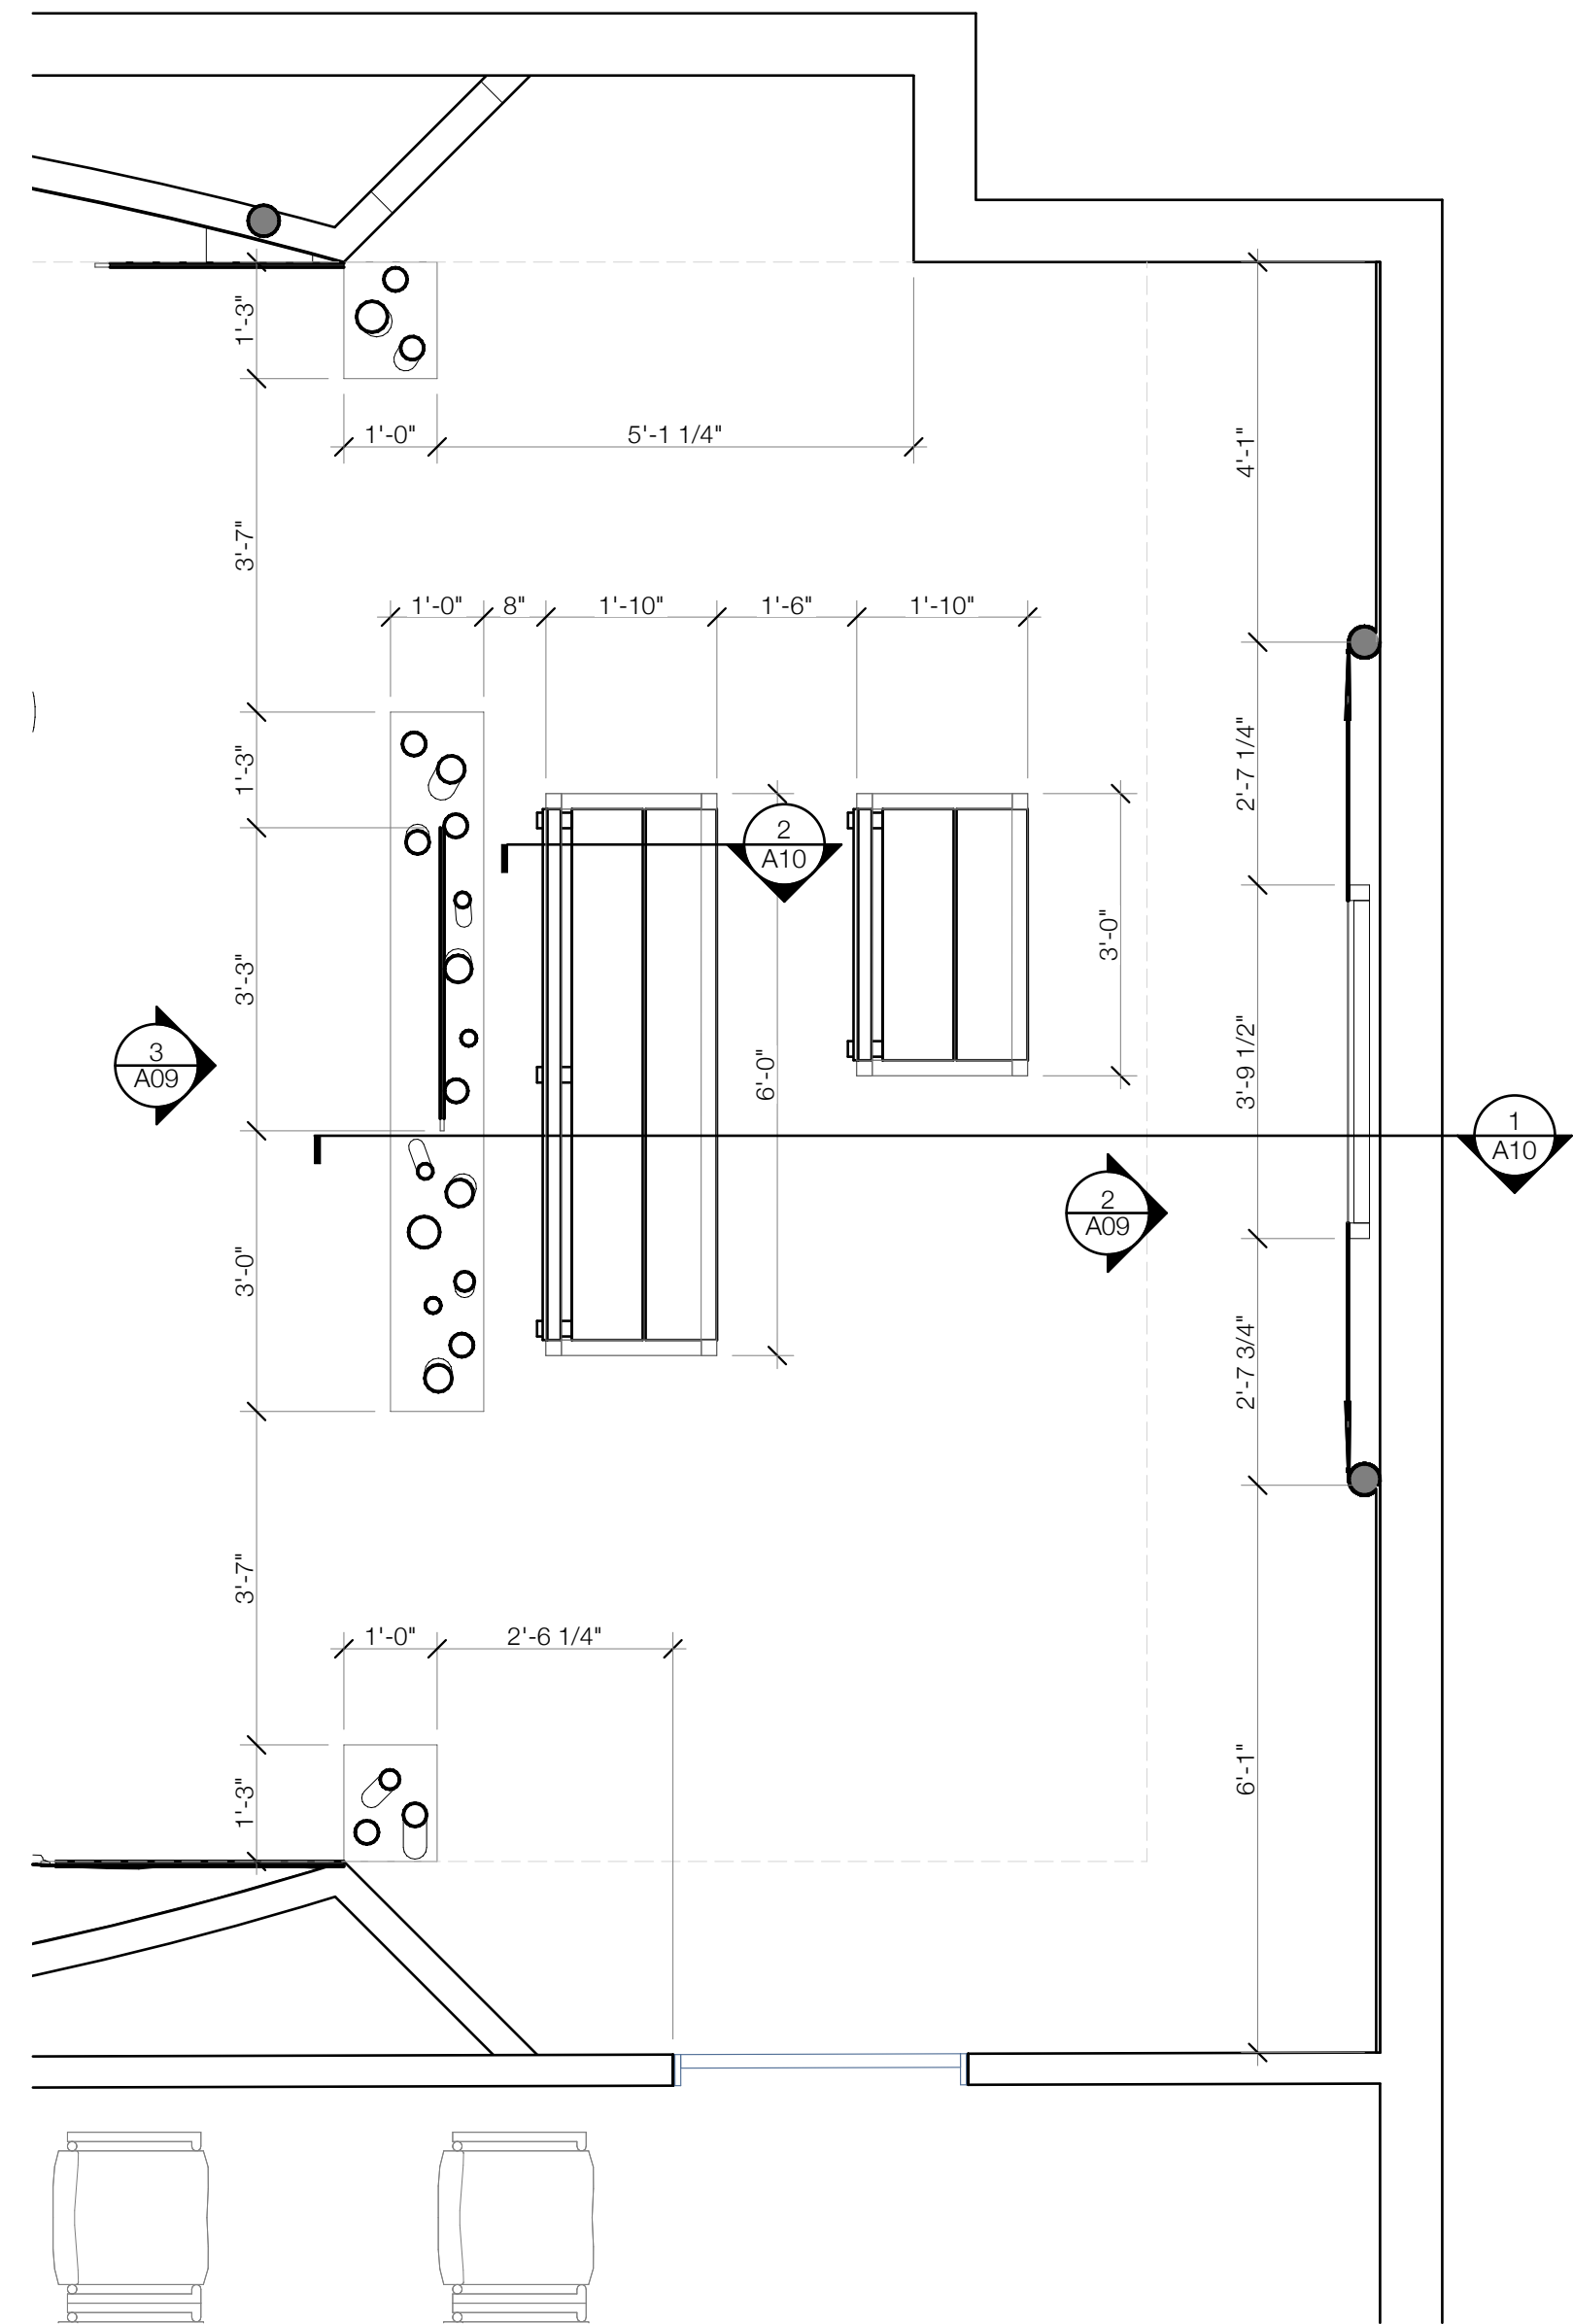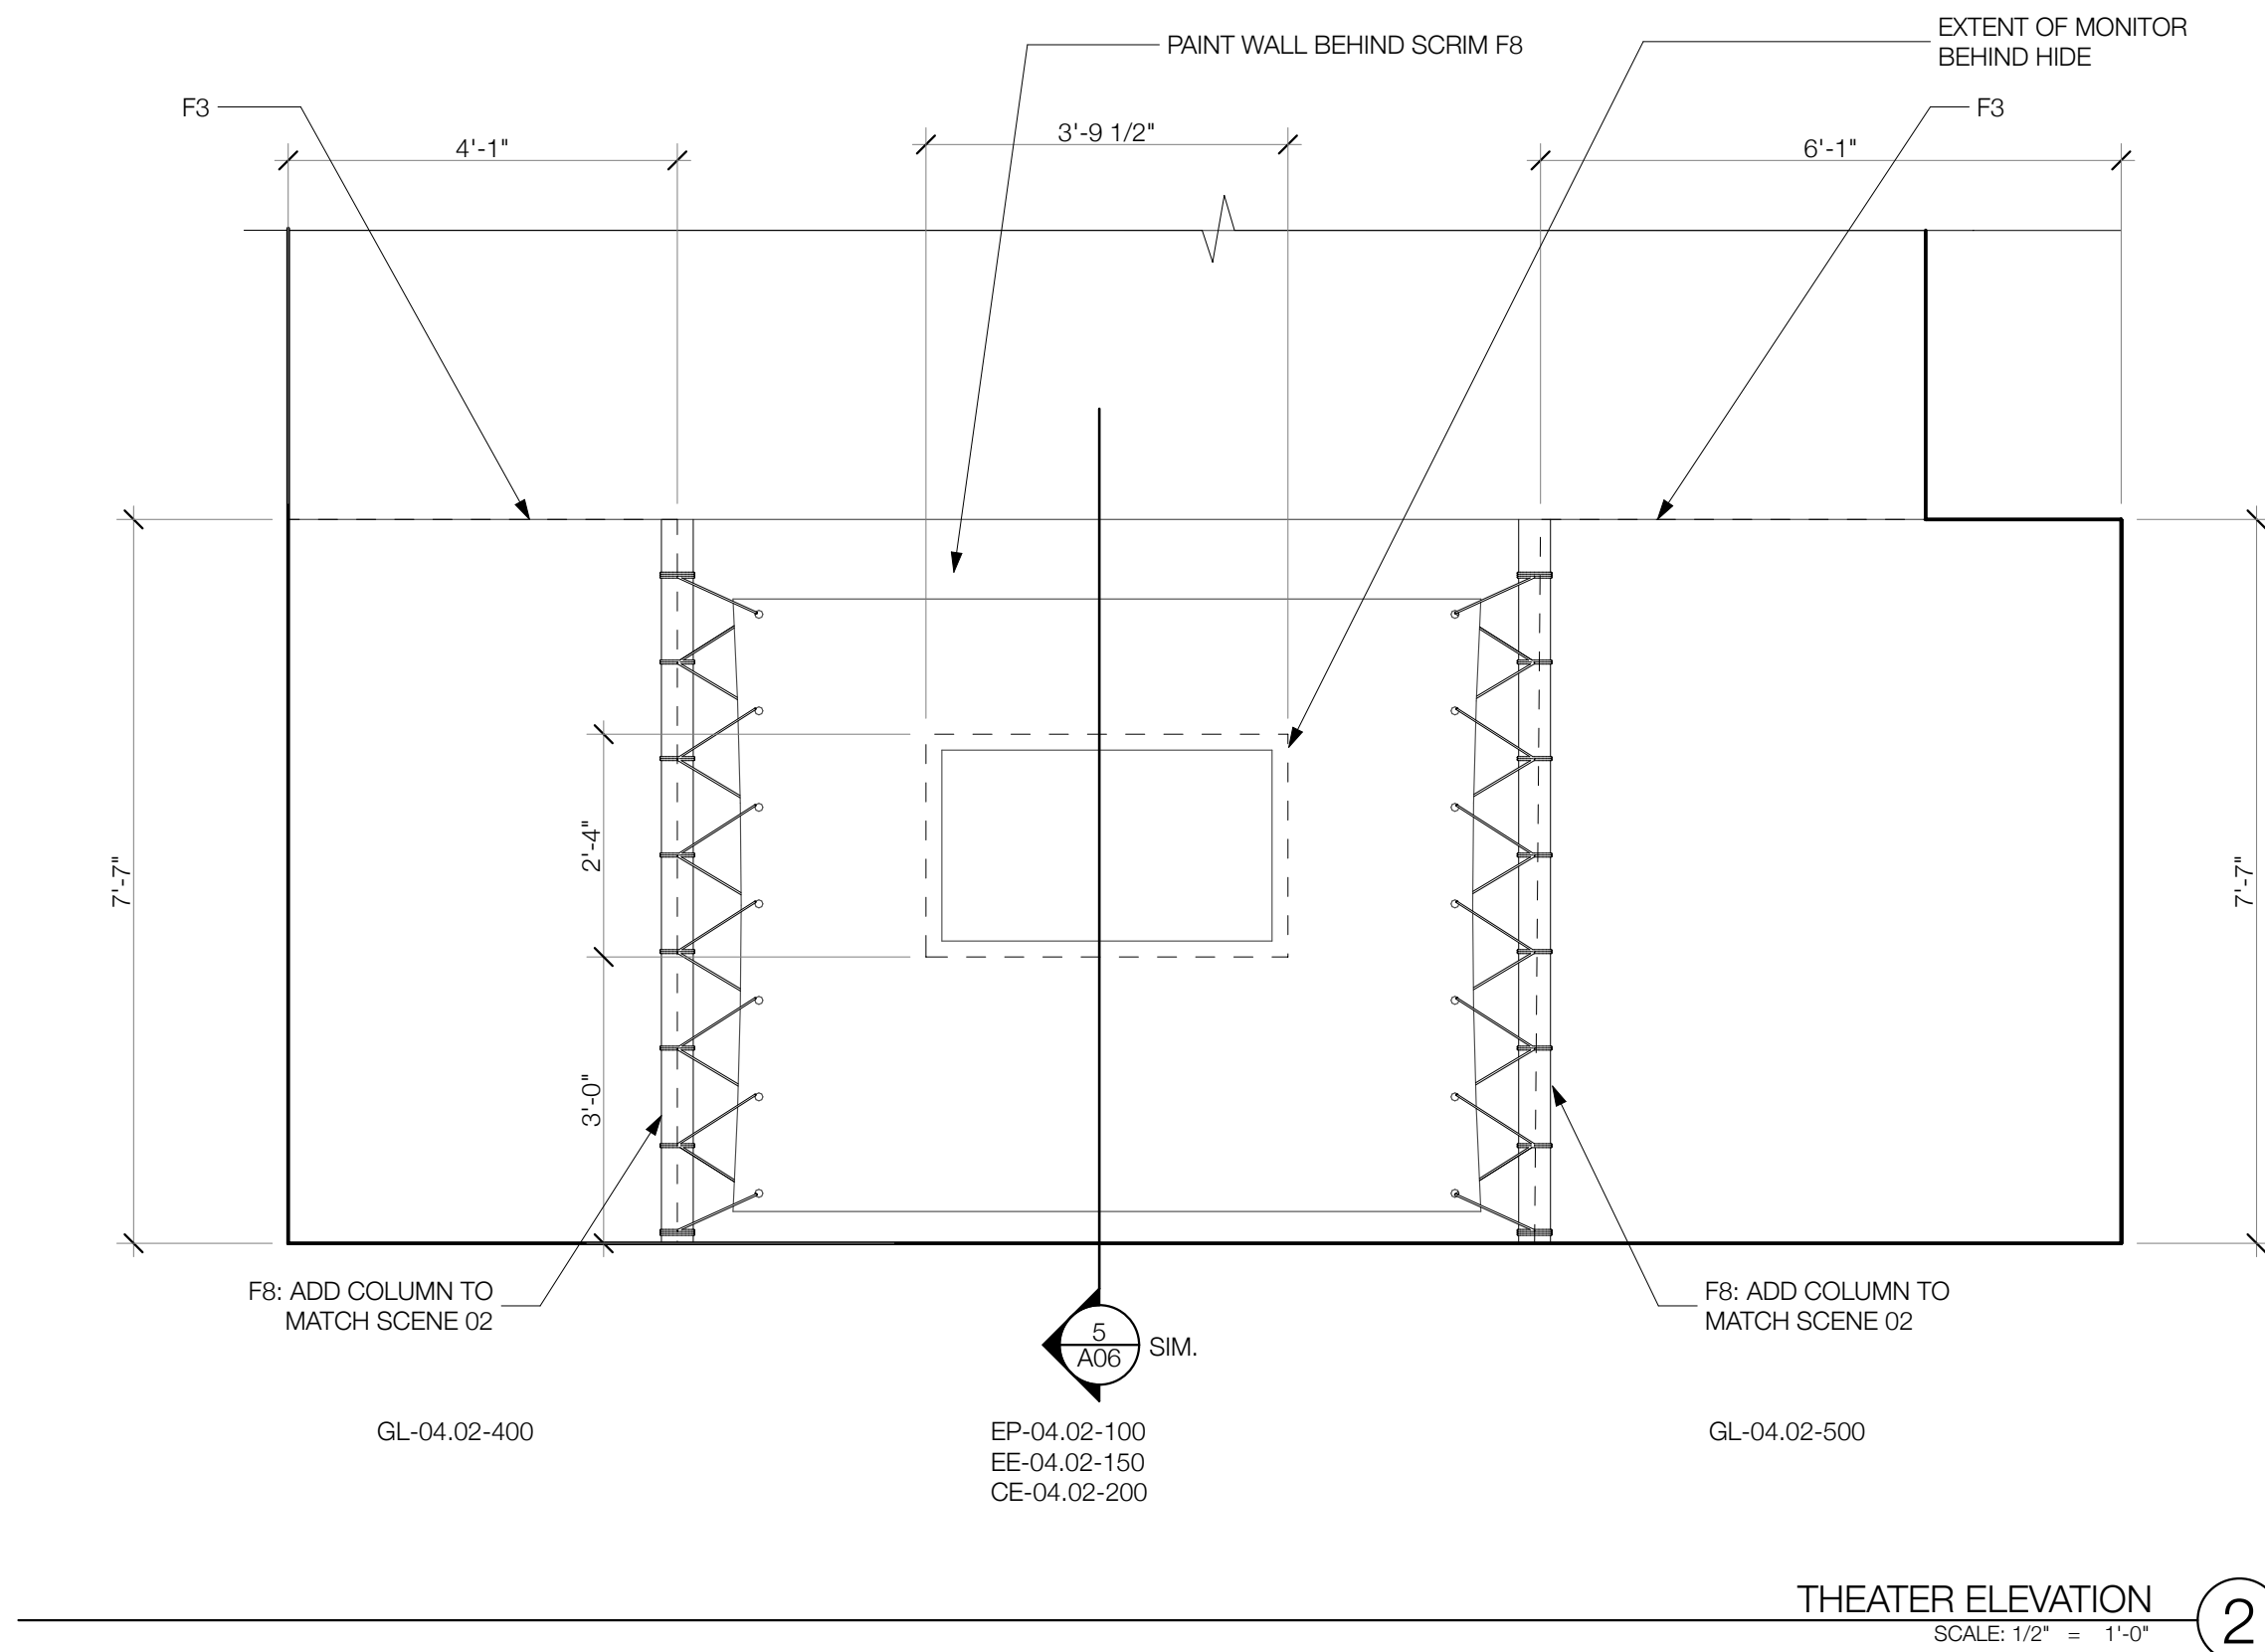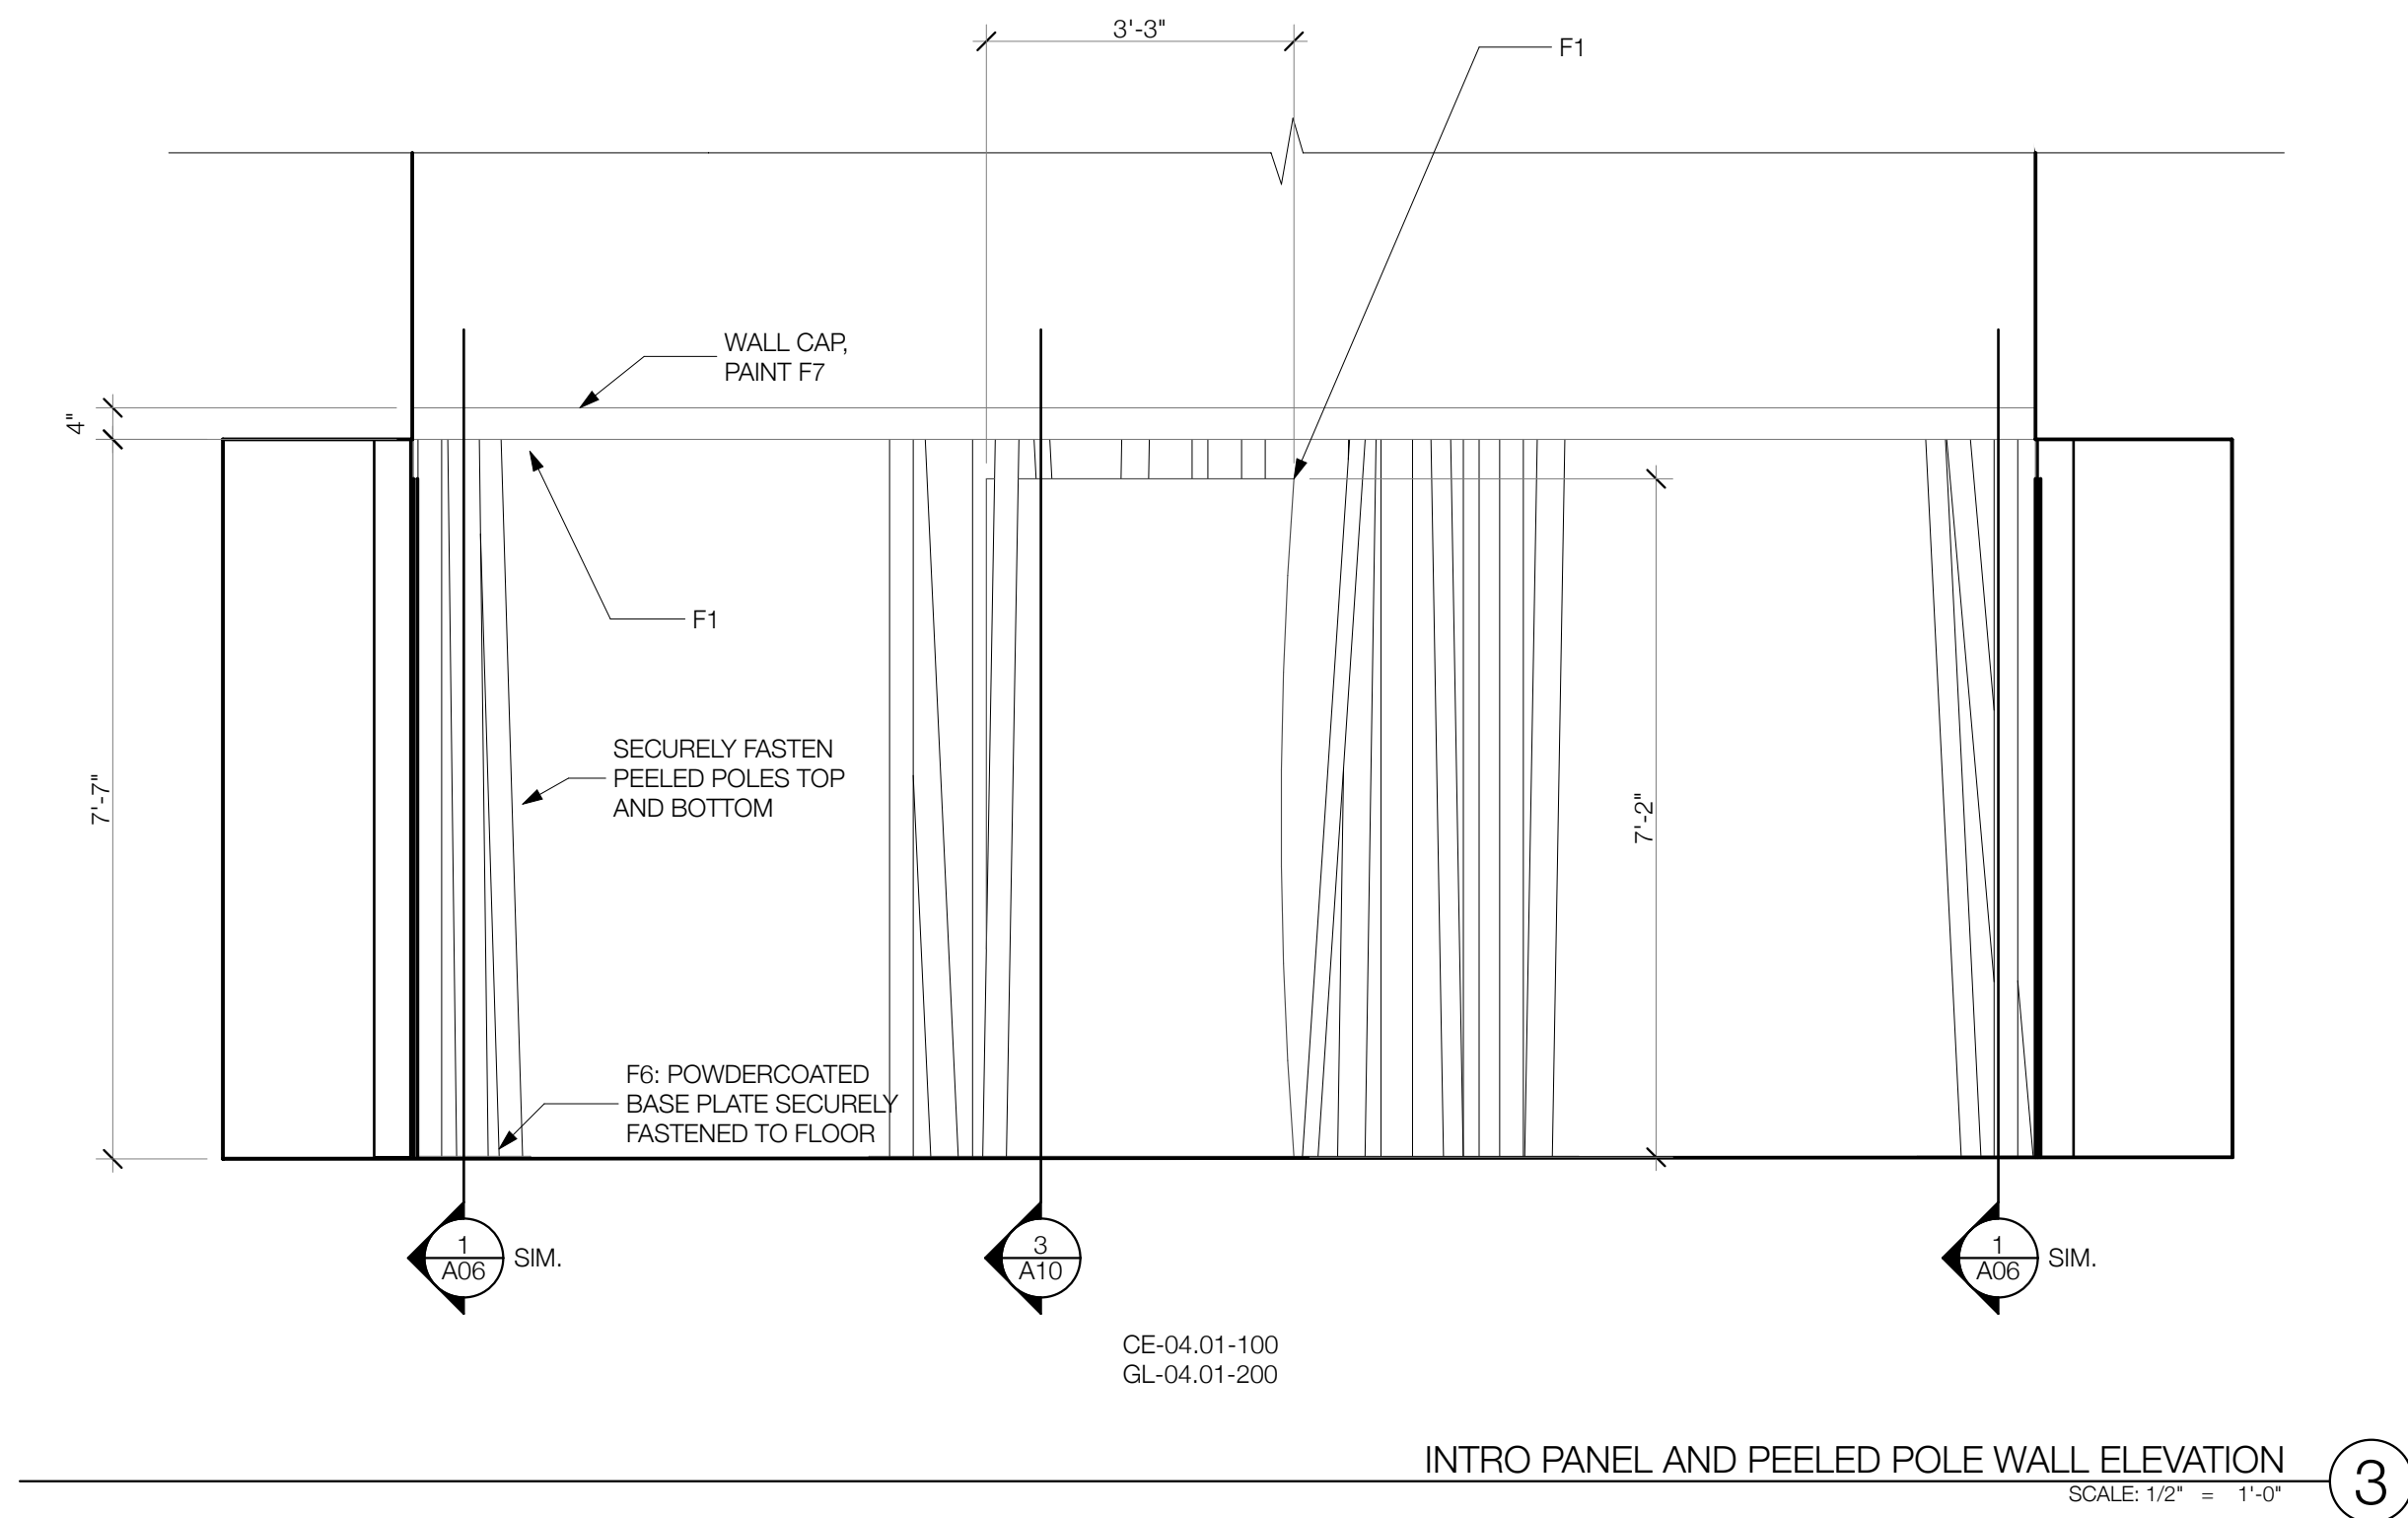

SCENE 04 MAKING PRAYERS PLAN

SCALE: 1/2" = 1'-0"

1



SCENE 04
DETAILS

Title:

DD2

Revision #:

6/14/18


Date:

PIPESTONE NATIONAL MONUMENT
VISITOR CENTER EXHIBITS


These documents have been created to show the designers' intent only. Written dimensions shall take precedence over scaled dimensions. Contractors shall verify and be responsible for all dimensions and conditions on the job, and this office must be notified of any variations from the dimensions and conditions shown by these drawings. Shop details must be submitted to this office before beginning fabrication. All ideas, designs, and arrangements indicated on these drawings are the property of EDX and are intended for the sole use of the client noted.

A10


SHEET 10 OF 14

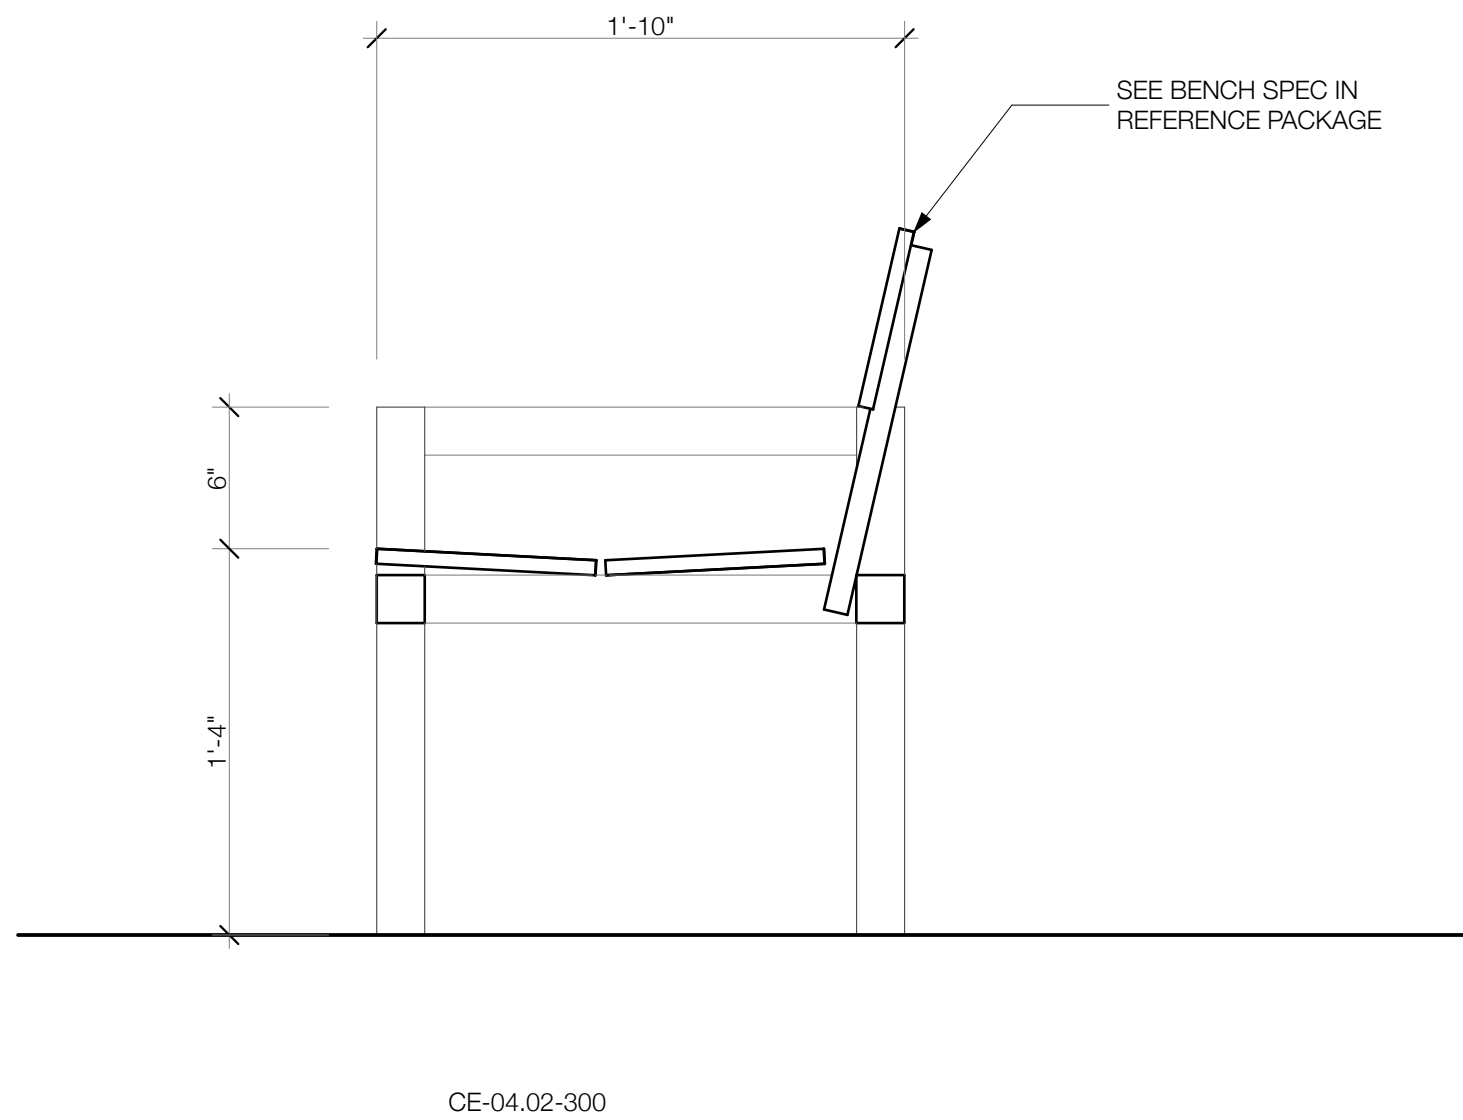


THEATER BENCH SECTION
SCALE: 1 1/2" = 1'-0" 2

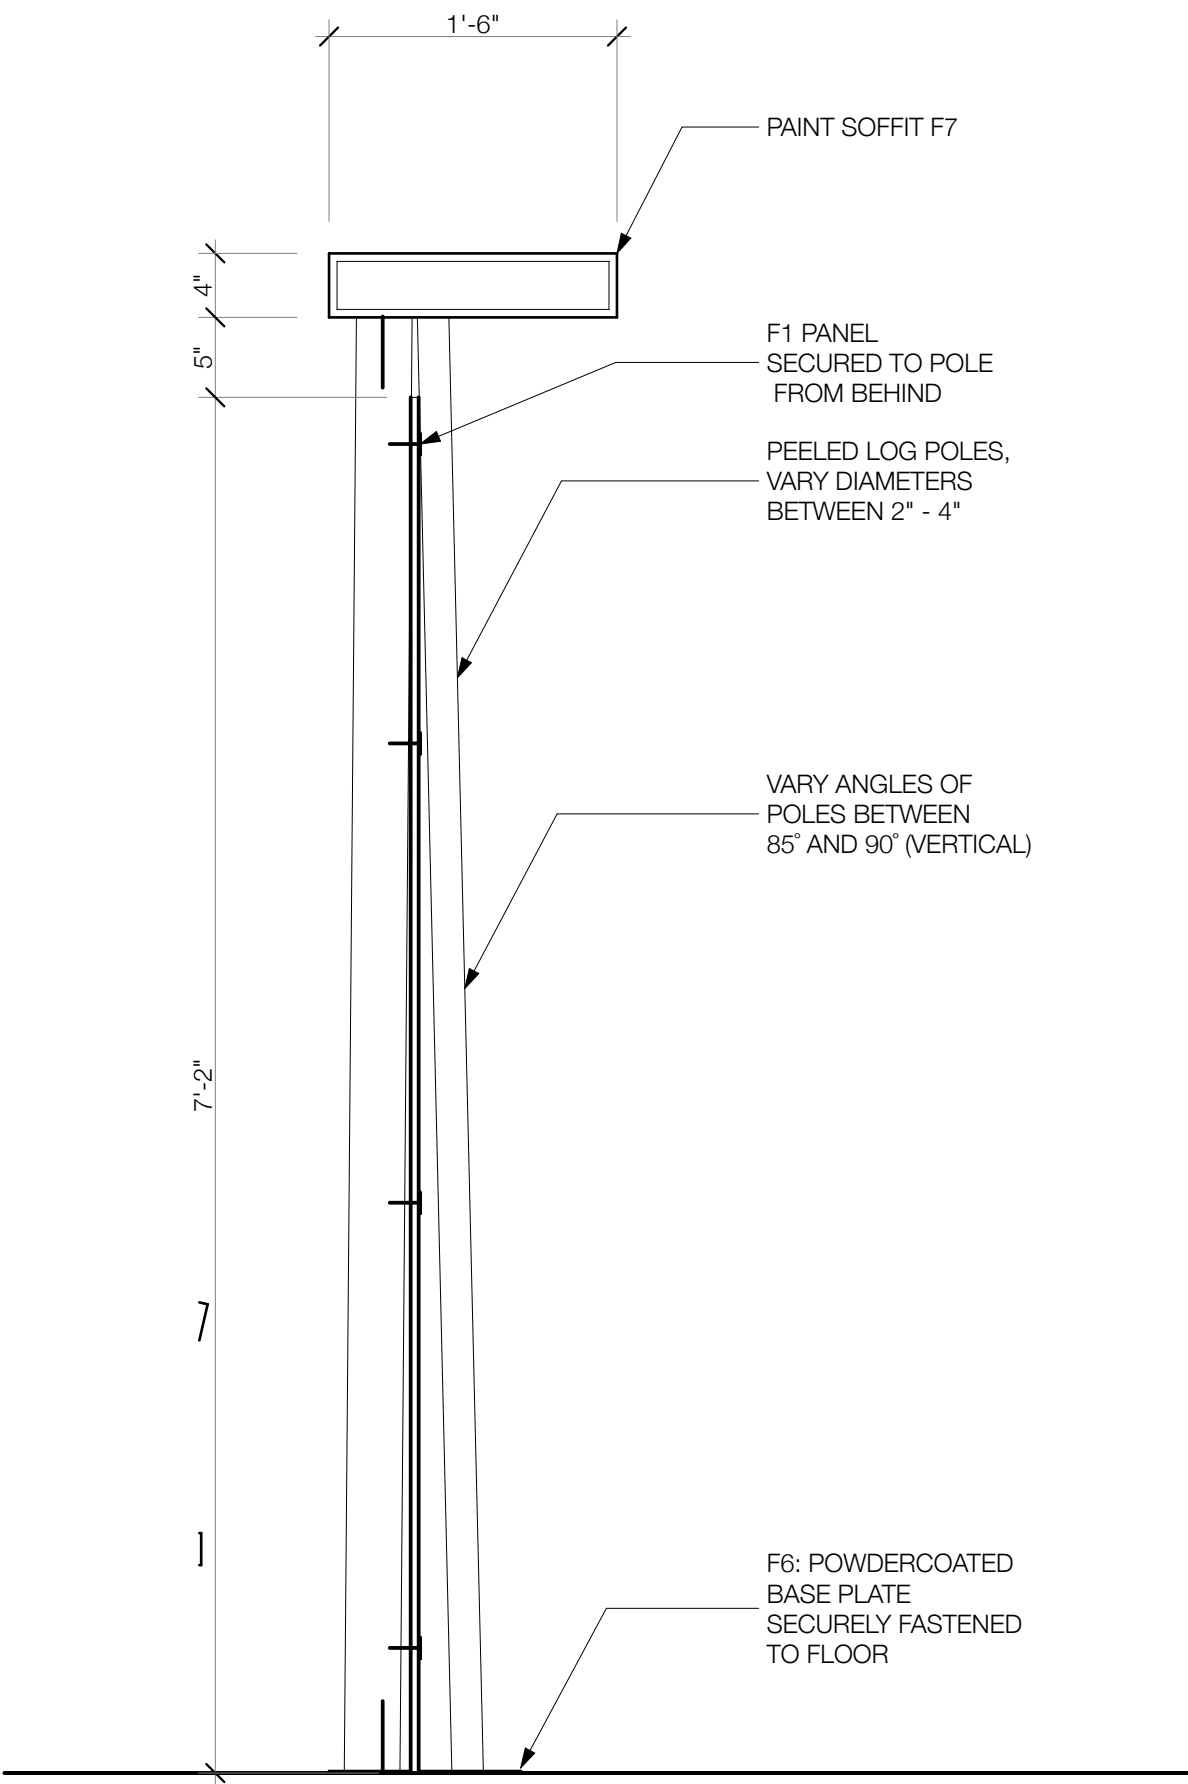

PEELED POLE WALL WITH PANEL SECTION
SCALE: 1" = 1'-0" 3

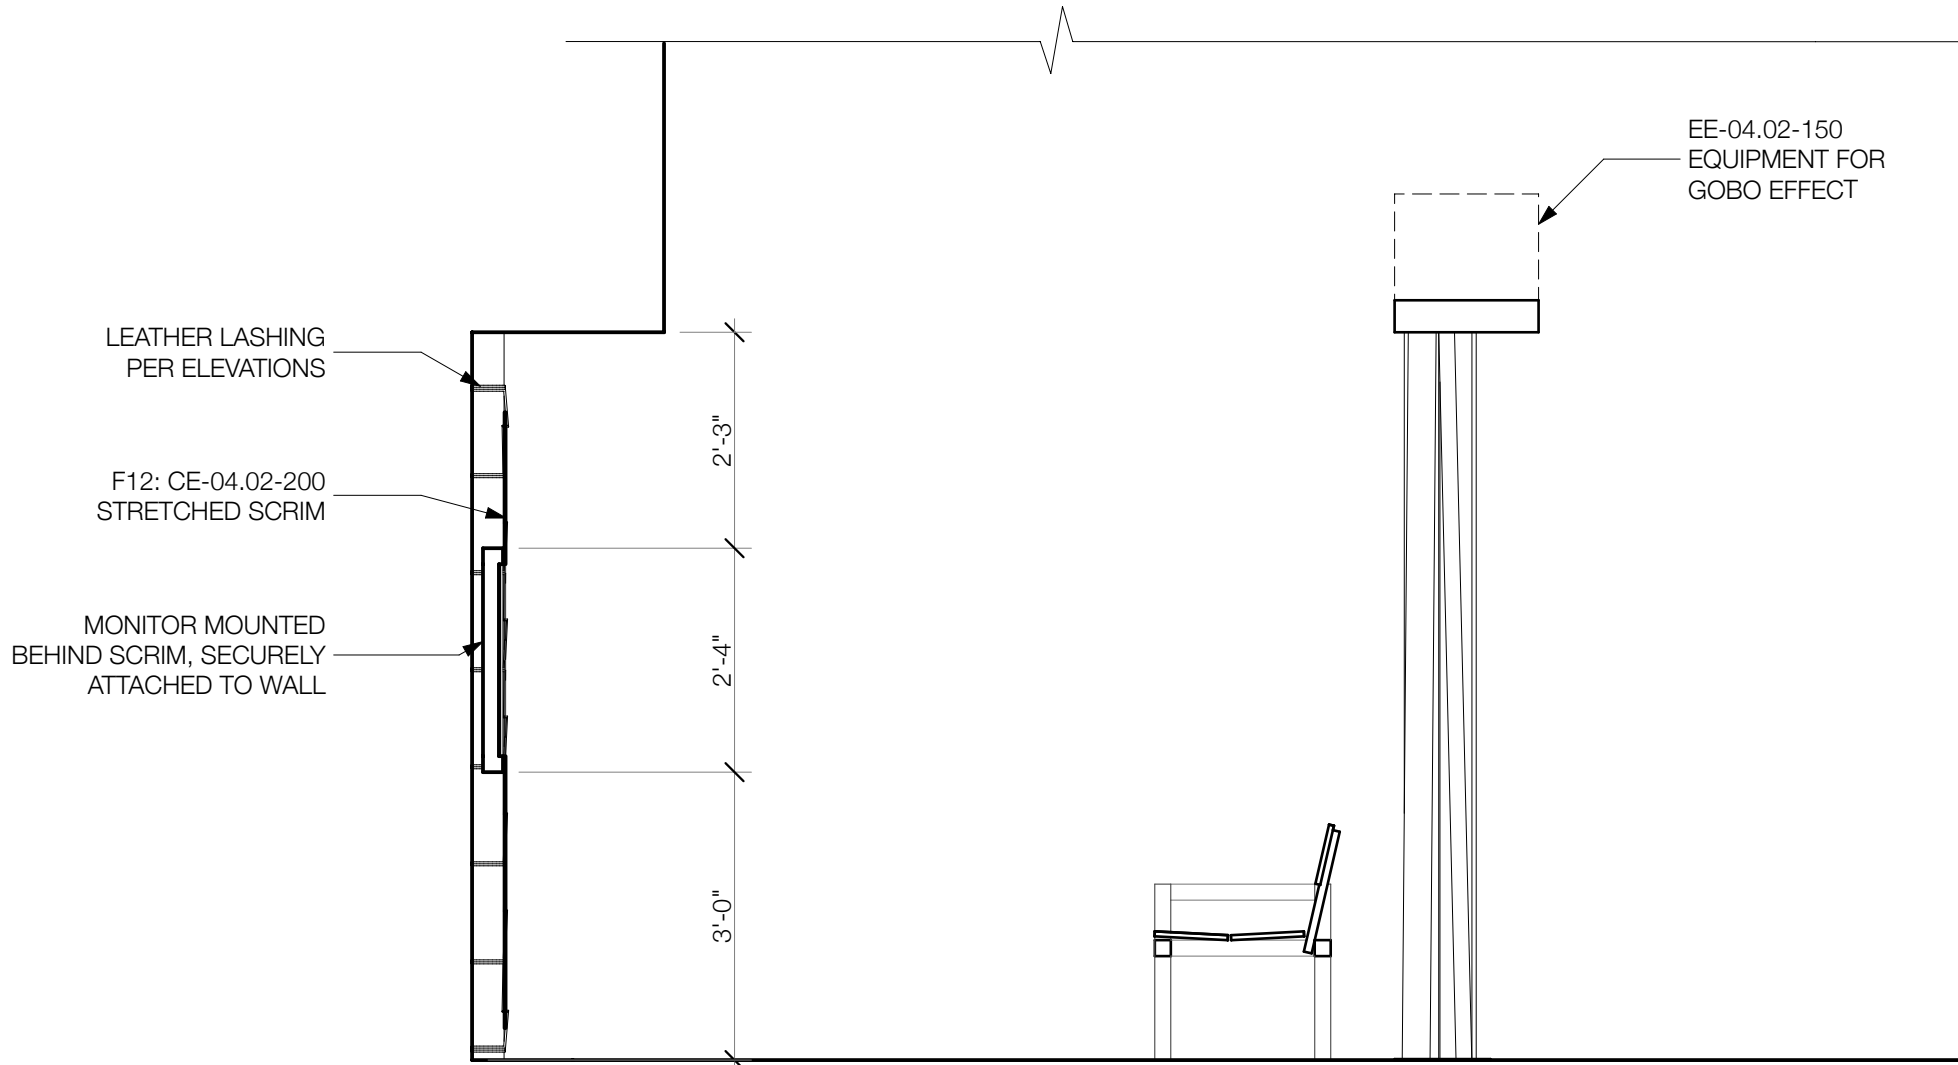


THEATER SECTION
SCALE: 1/2" = 1'-0" 1

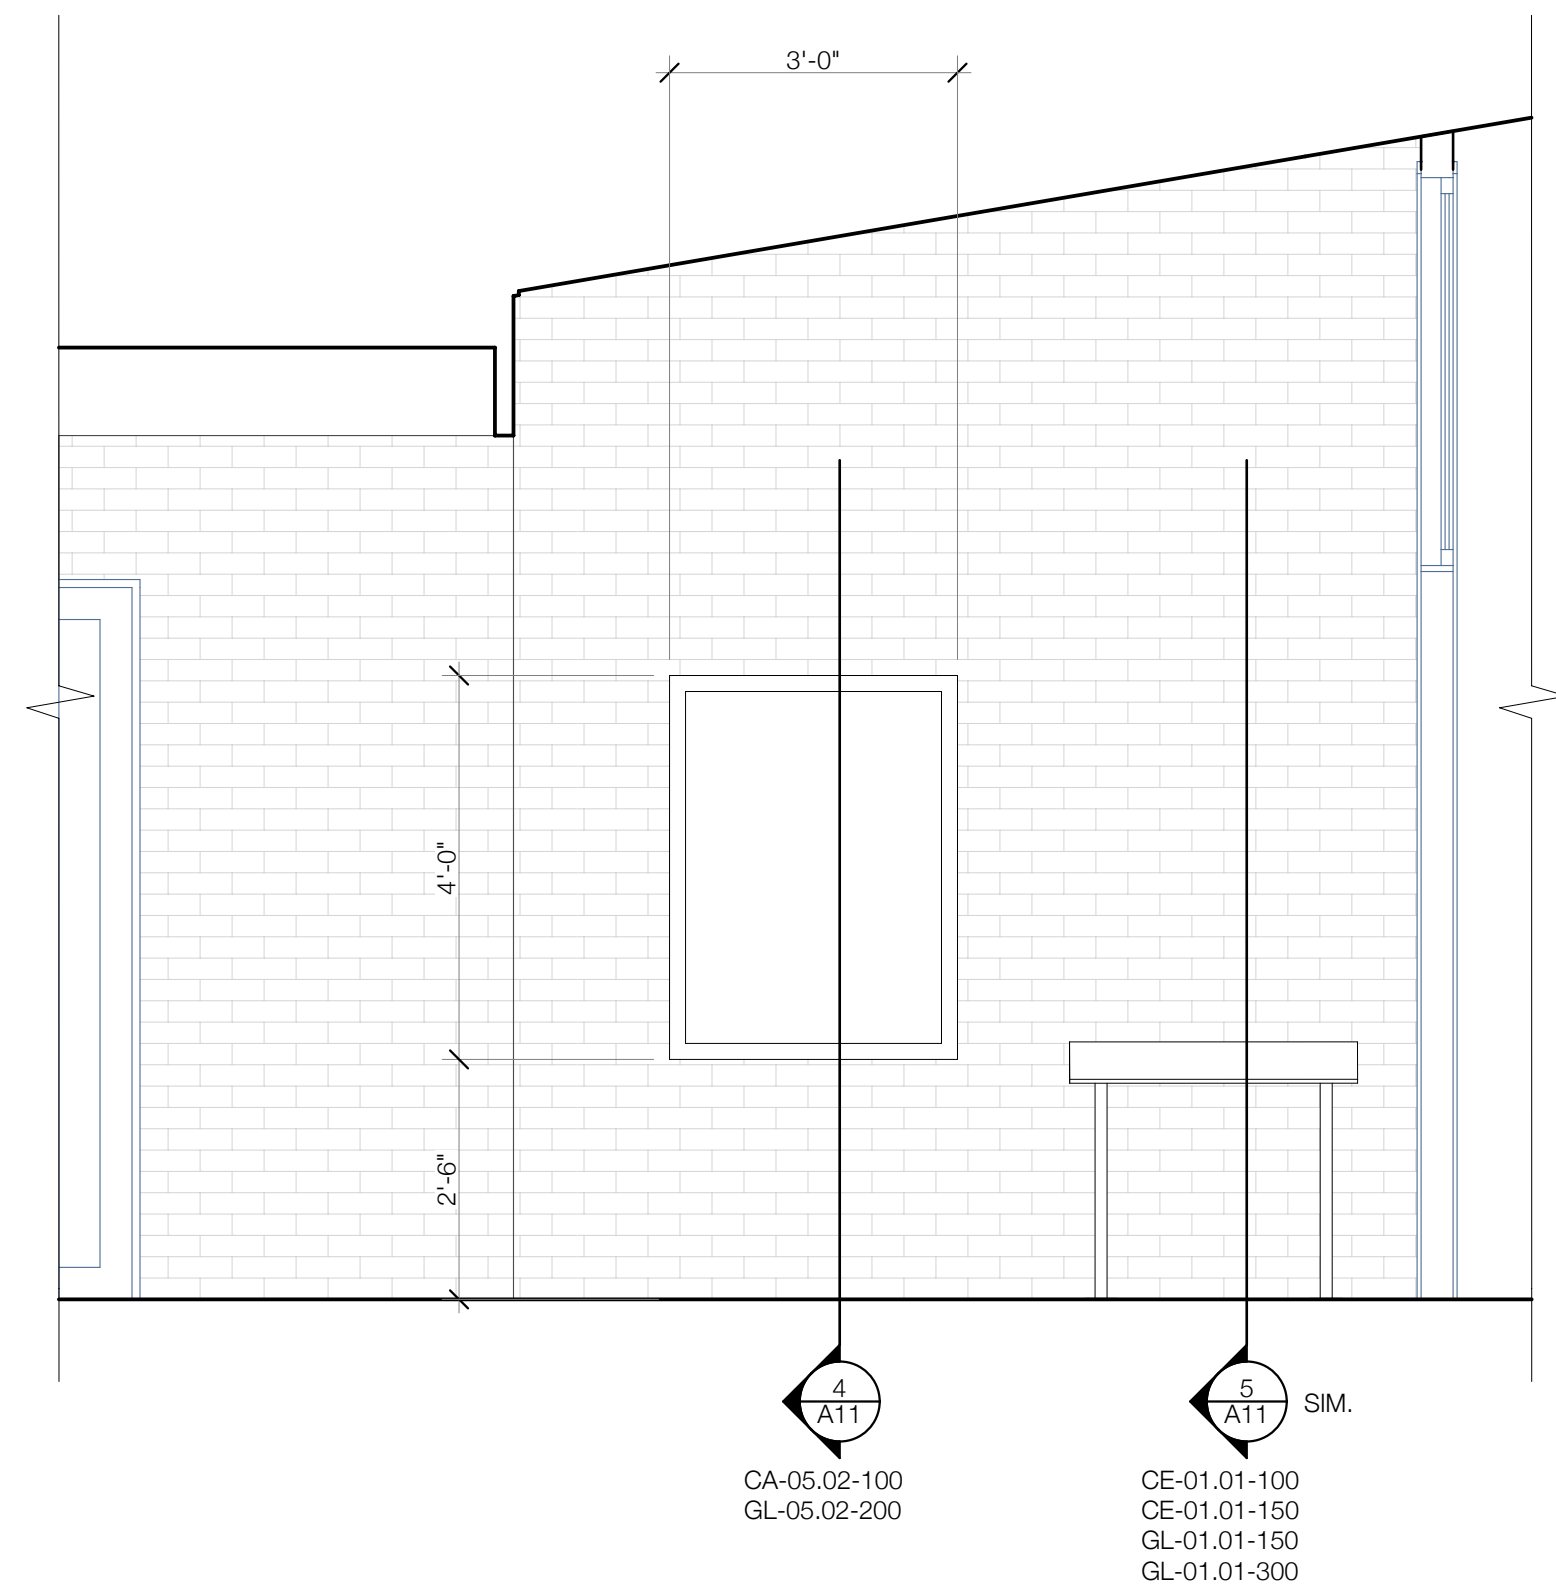


CHANGING CONTENT BOARD & TACTILE FLOOR PLAN ELEVATION
SCALE: 1/2" = 1'-0"

3

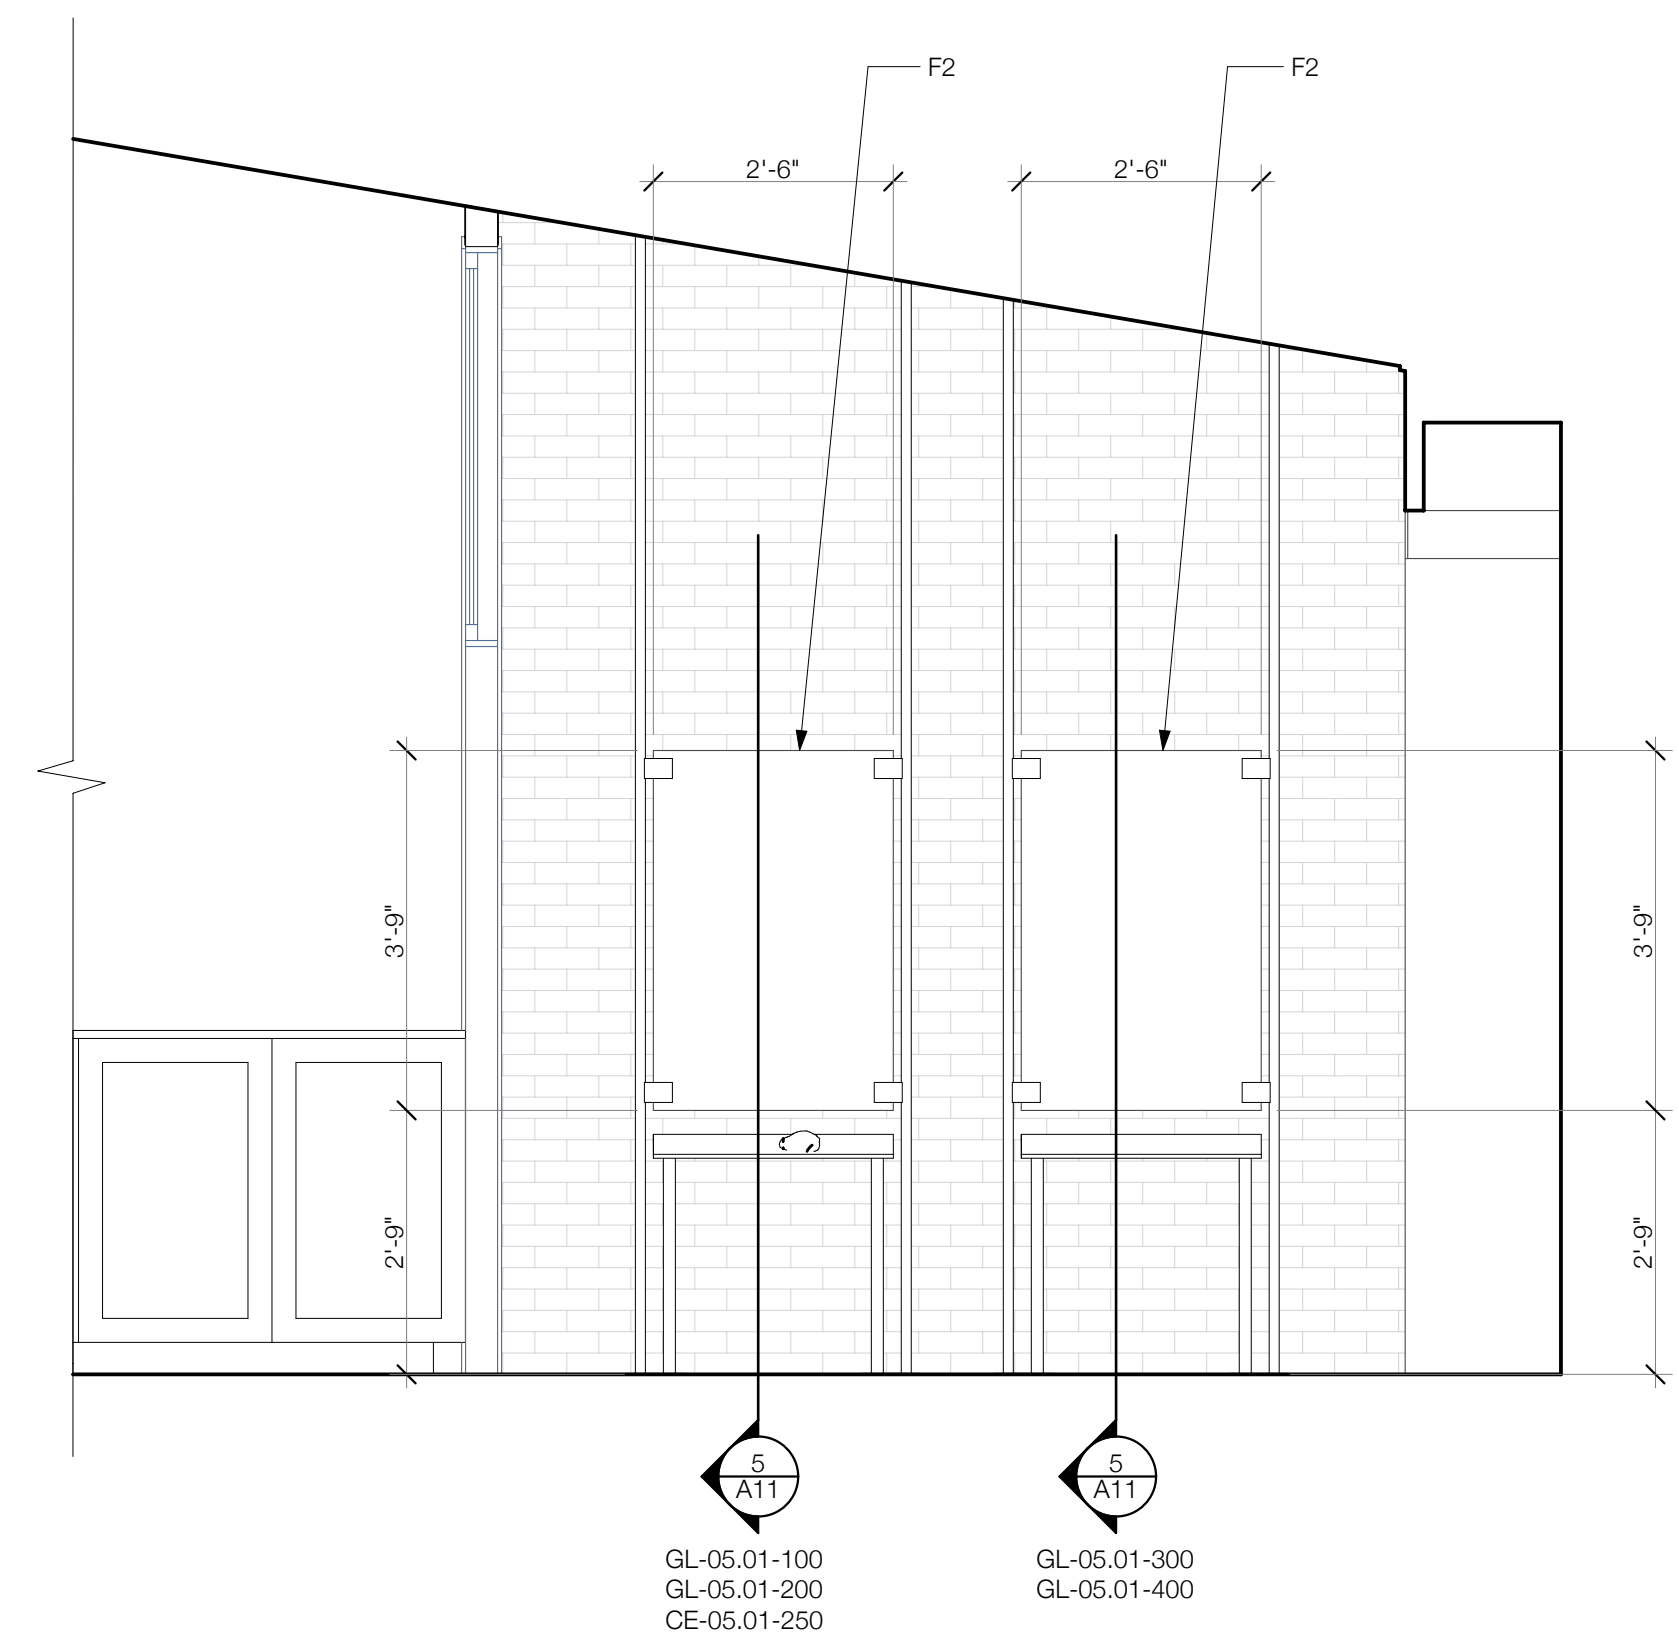


PANELS ELEVATION
SCALE: 1/2" = 1'-0"

2

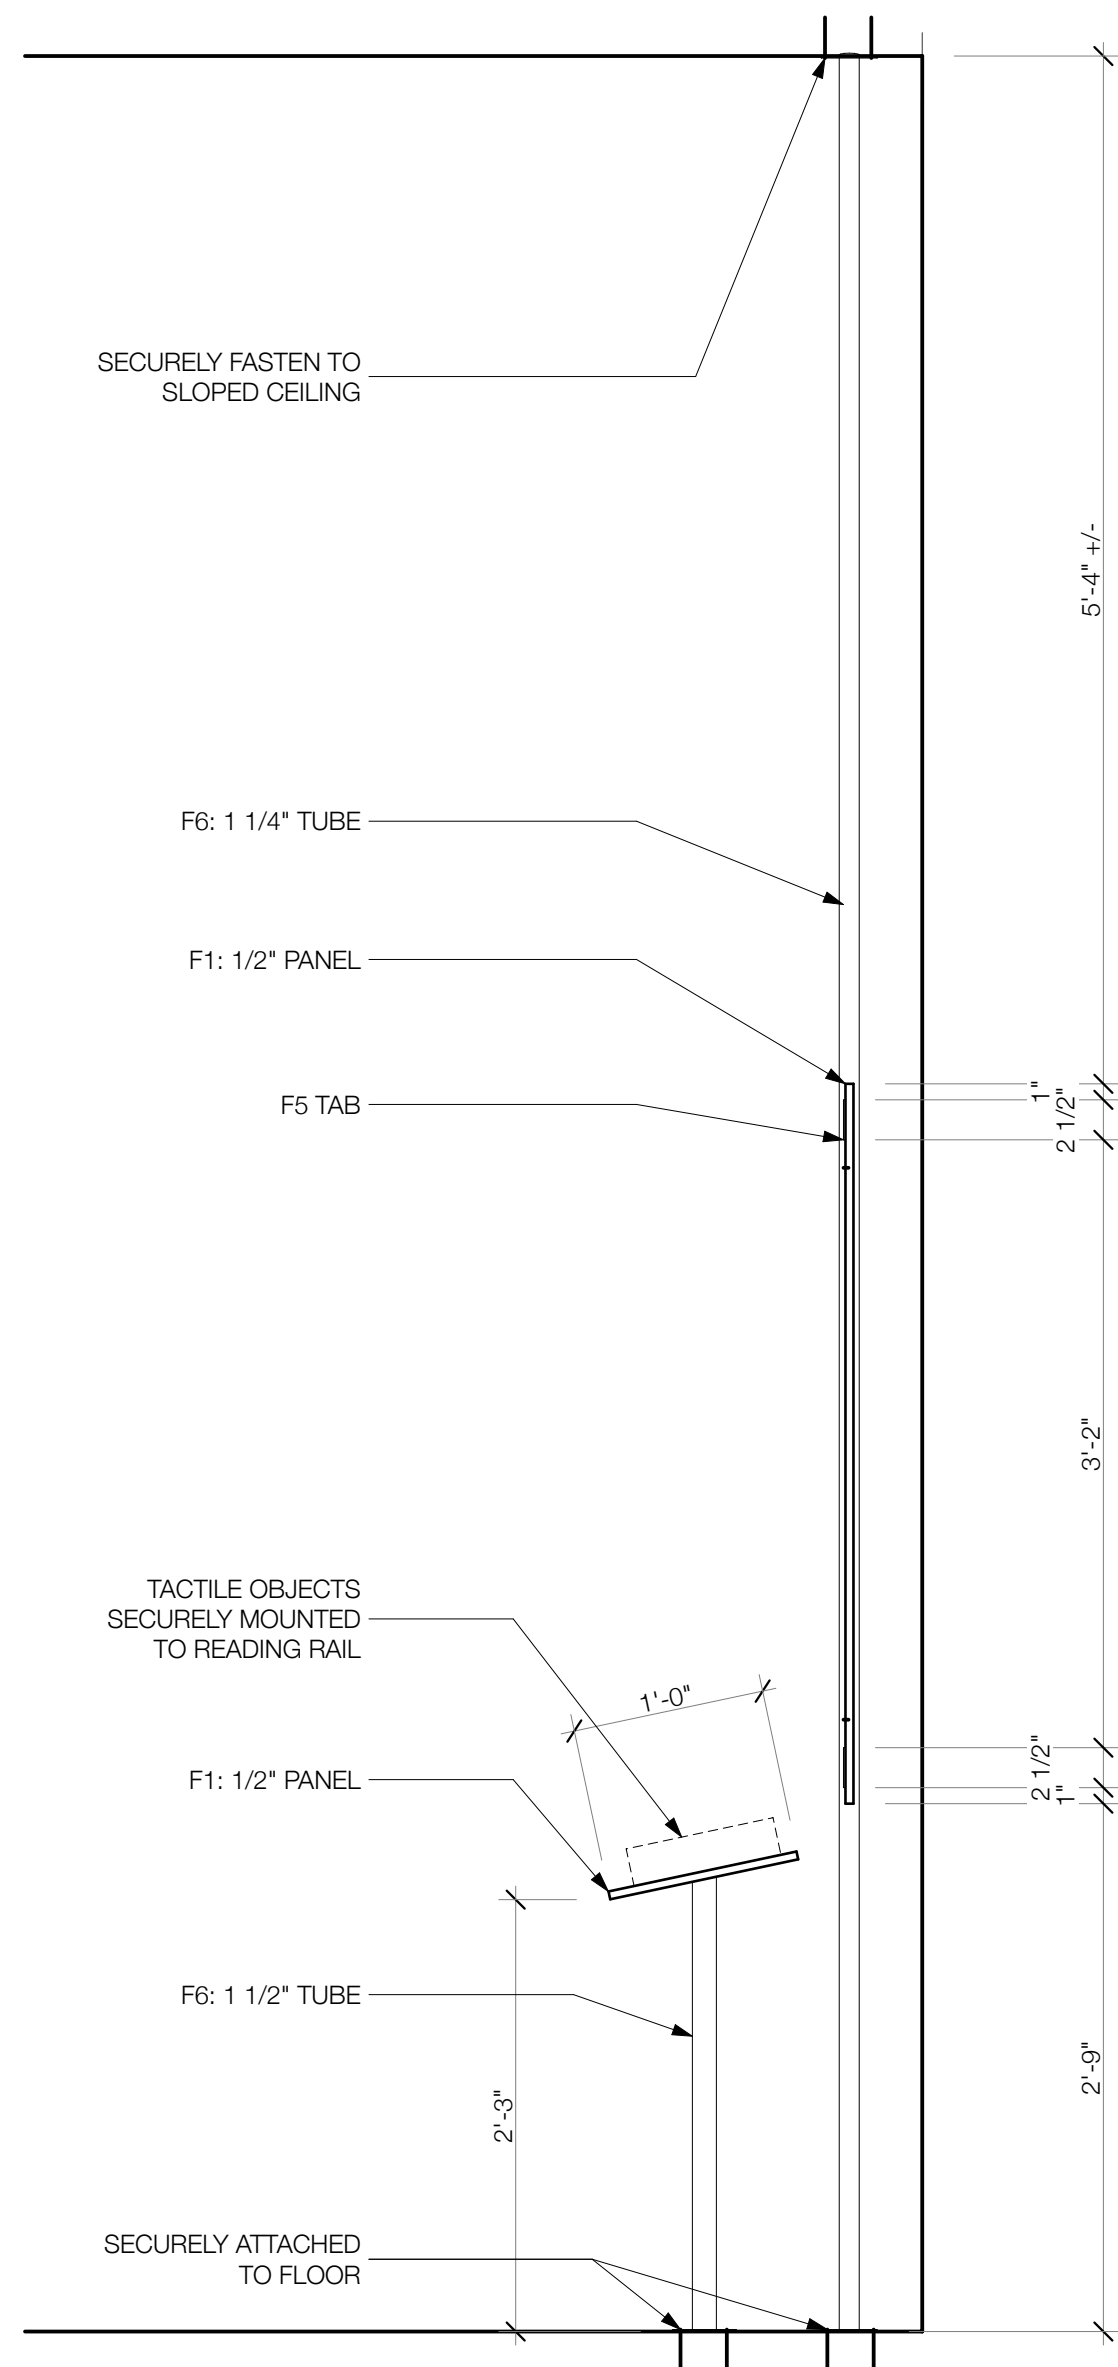


SUSPENDED PANELS WITH READING RAIL SECTION
SCALE: 1" = 1'-0"

5

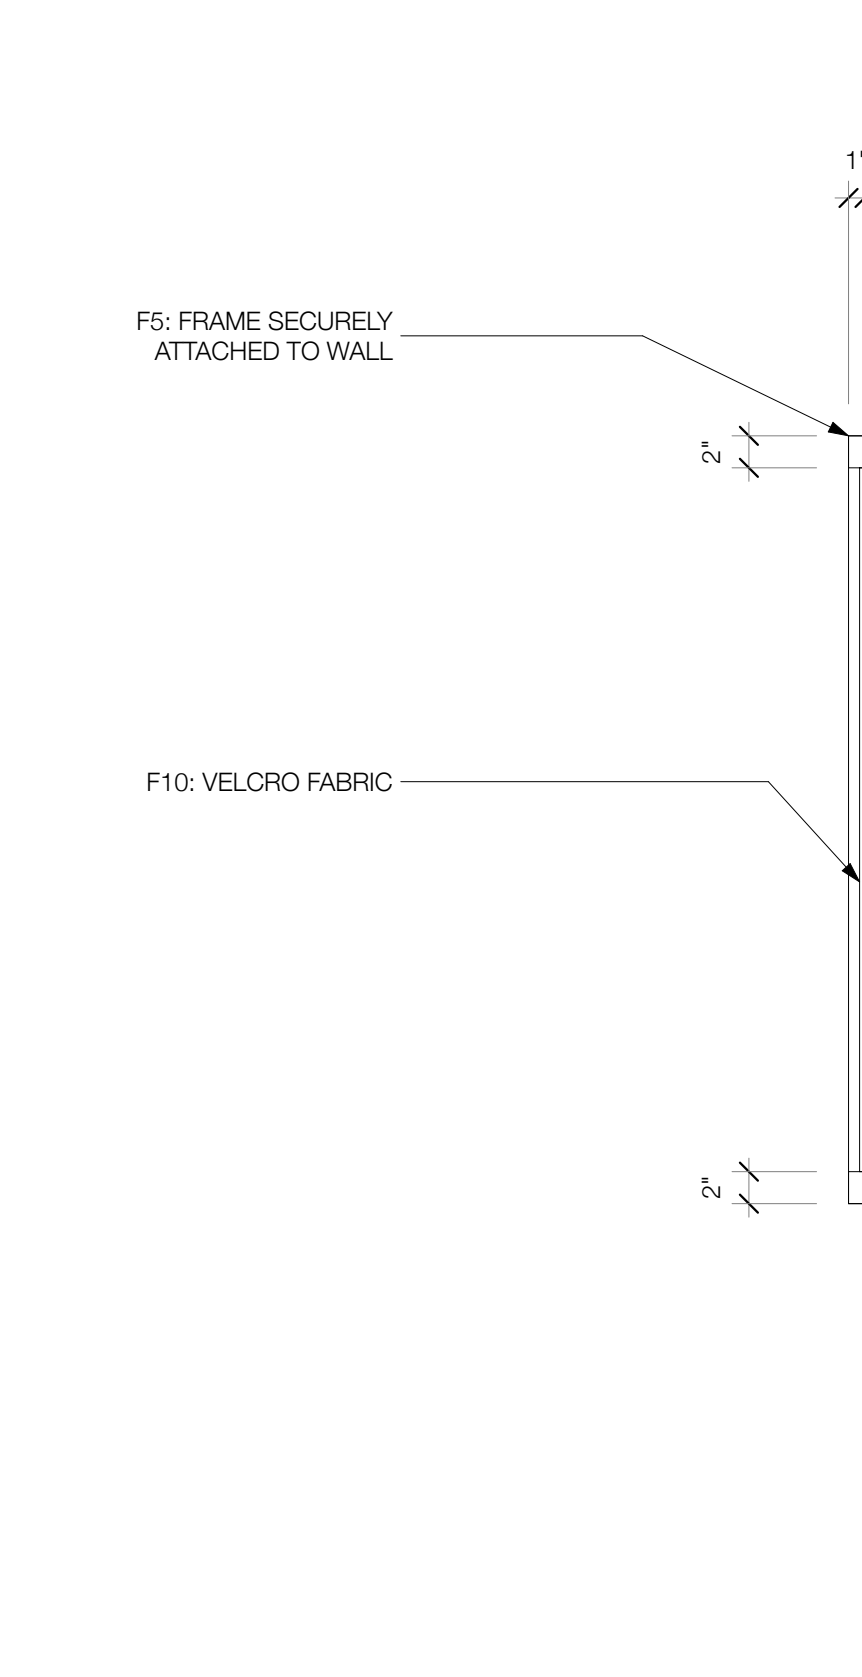

CHANGING BOARD SECTION
SCALE: 1" = 1'-0"

4

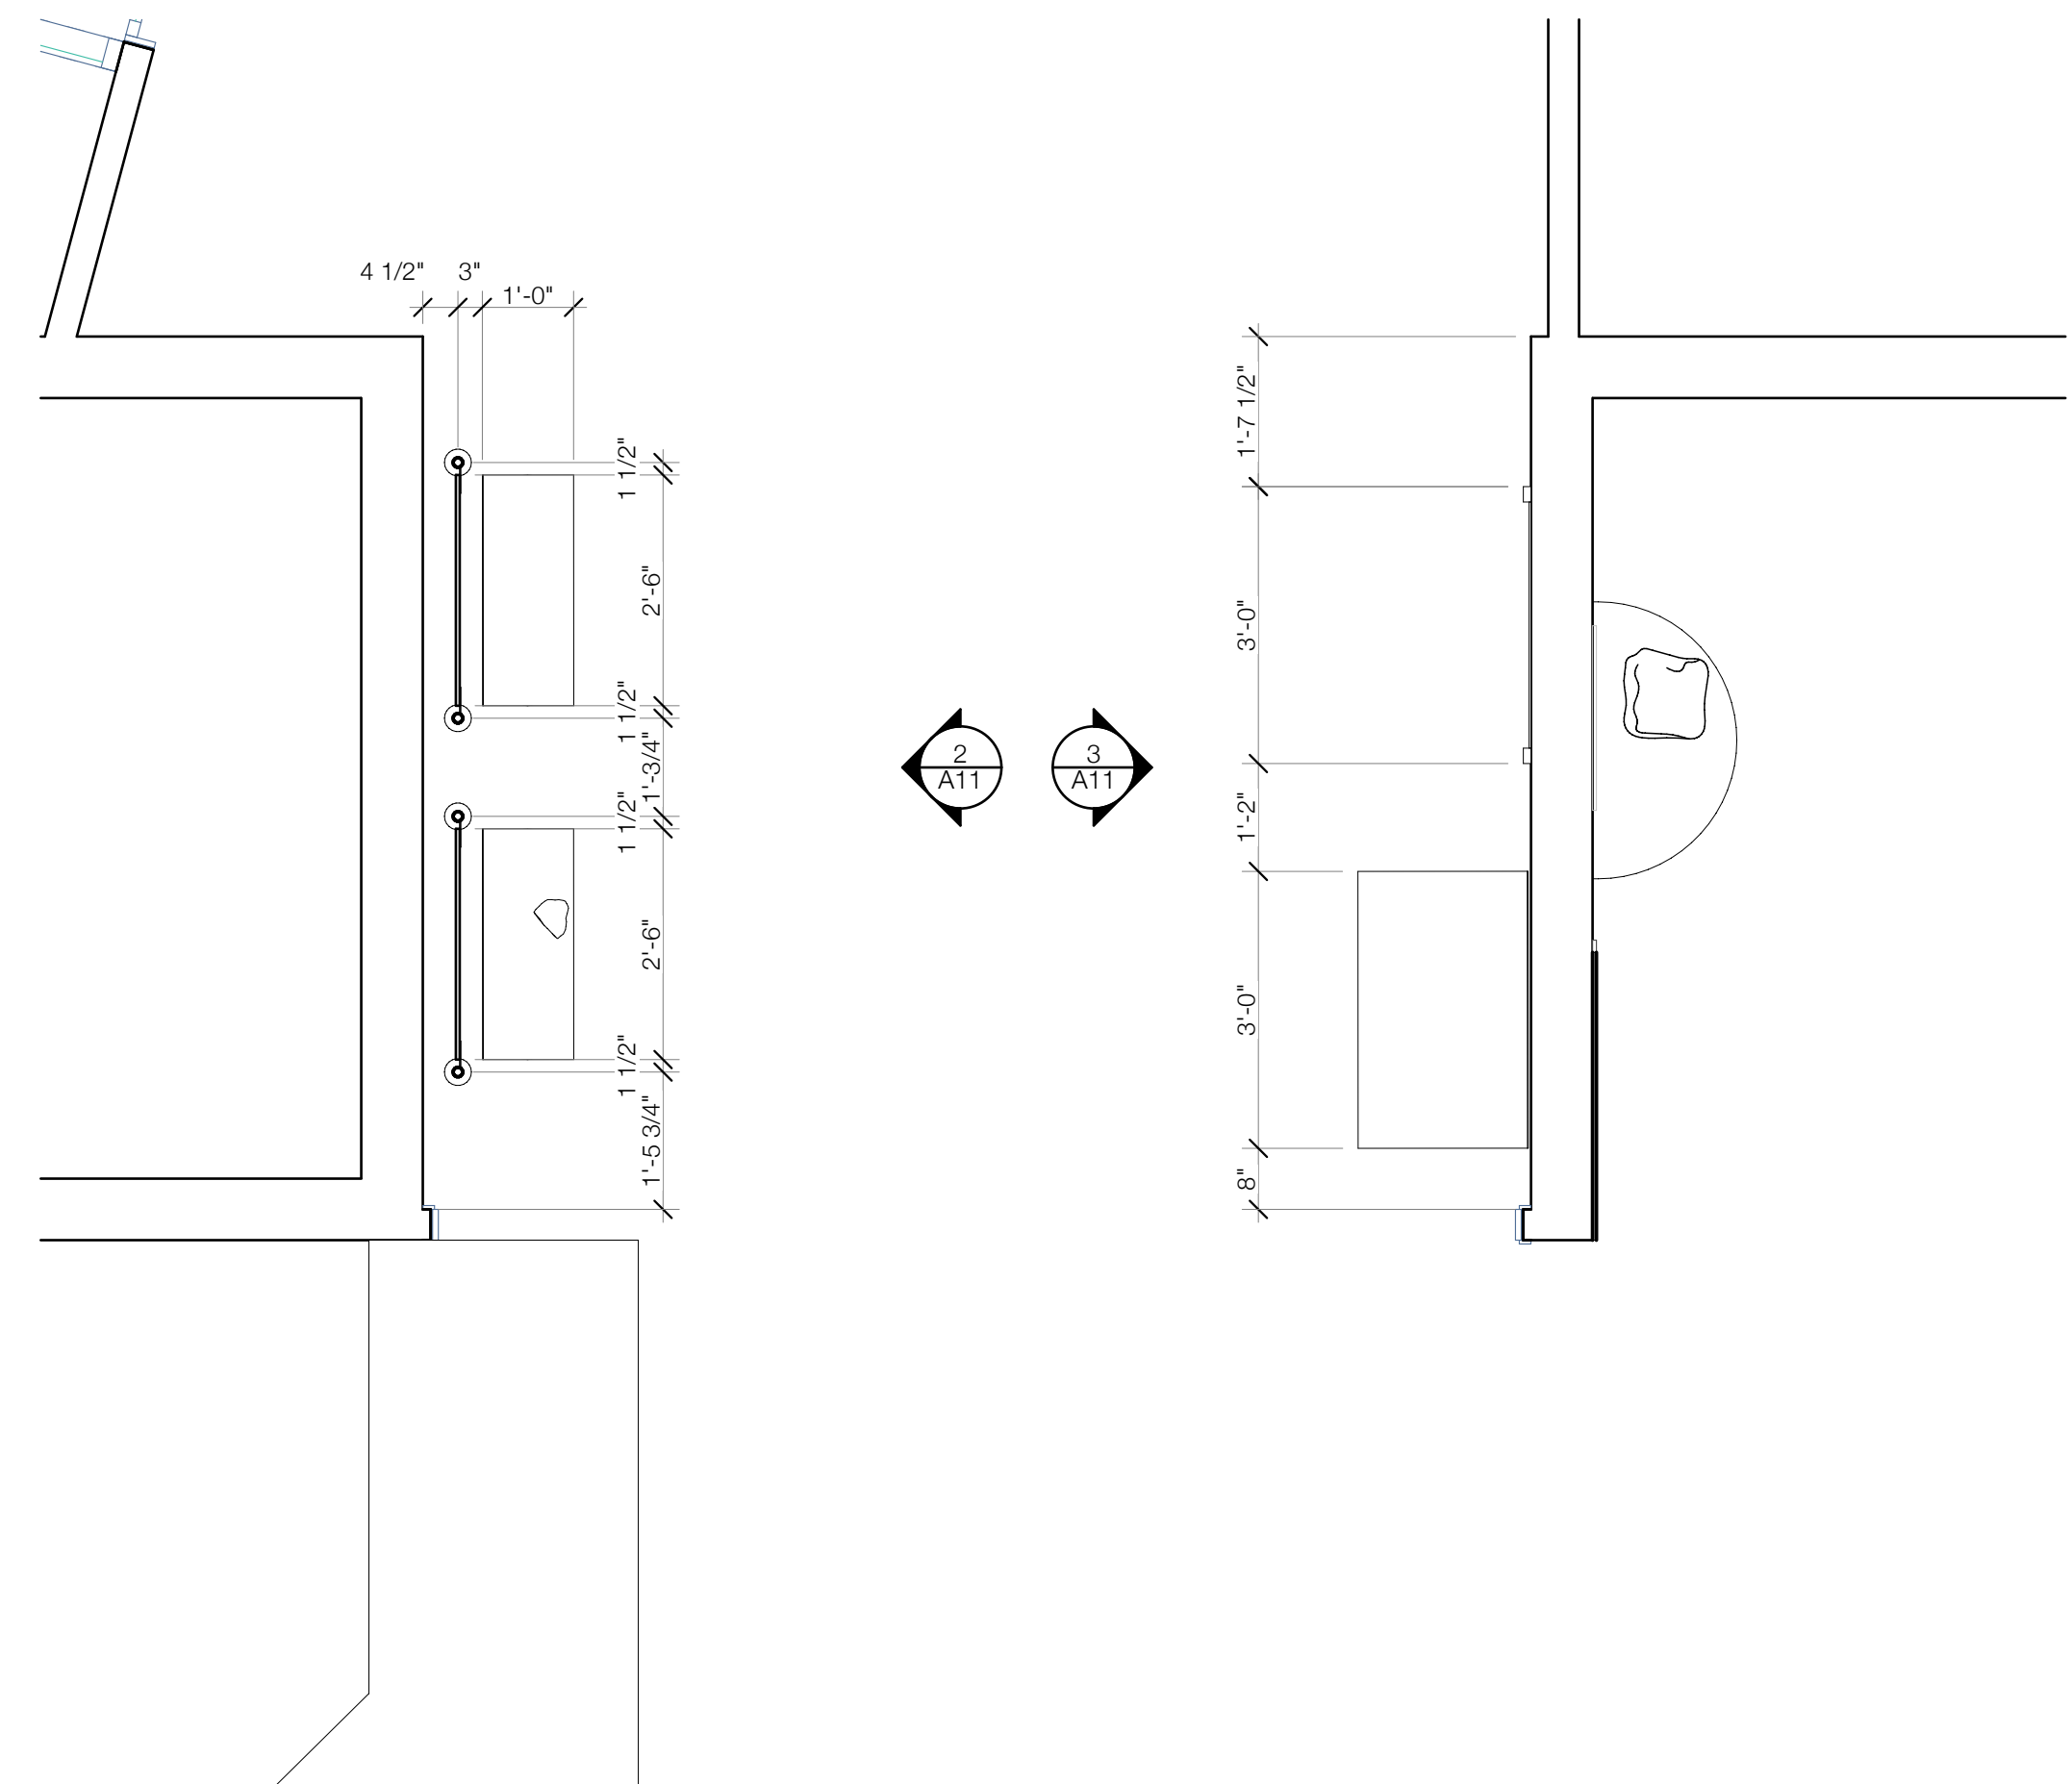


SCENE 05 HISTORY AND PRESERVATION PLAN
SCALE: 1/2" = 1'-0"

1



These documents have been created to show the designers' intent only. Written dimensions shall take precedence over scaled dimensions. Contractors shall verify and be responsible for all dimensions and conditions on the job, and this office must be notified of any variations from the dimensions and conditions shown by these drawings. Shop details must be submitted to this office before beginning fabrication. All ideas, designs, and arrangements indicated on these drawings are the property of EDX and are intended for the sole use of the client noted.

 SHEET 12 OF 14



PIPESTONE NATIONAL MONUMENT
VISITOR CENTER EXHIBITS

These documents have been prepared to show the designers' intent only. Written dimensions shall take precedence over scaled dimensions. Contractors shall verify and be responsible for all dimensions and conditions on the job, and this office must be notified of any variations from the dimensions and conditions shown by these drawings. Shop details must be submitted to this office before beginning fabrication. All ideas, designs, and arrangements indicated on these drawings are the property of EDX and are intended for the sole use of the client noted.


A13

SHEET 13 OF 14




PIPESTONE NATIONAL MONUMENT
VISITOR CENTER EXHIBITS

These documents have been created to show the designers' intent only. Written dimensions shall take precedence over scaled dimensions. Contractors shall verify and be responsible for all dimensions and conditions on the job, and this office must be notified of any variations from the dimensions and conditions shown by these drawings. Shop details must be submitted to this office before beginning fabrication. All ideas, designs, and arrangements indicated on these drawings are the property of EDX and are intended for the sole use of the client noted.

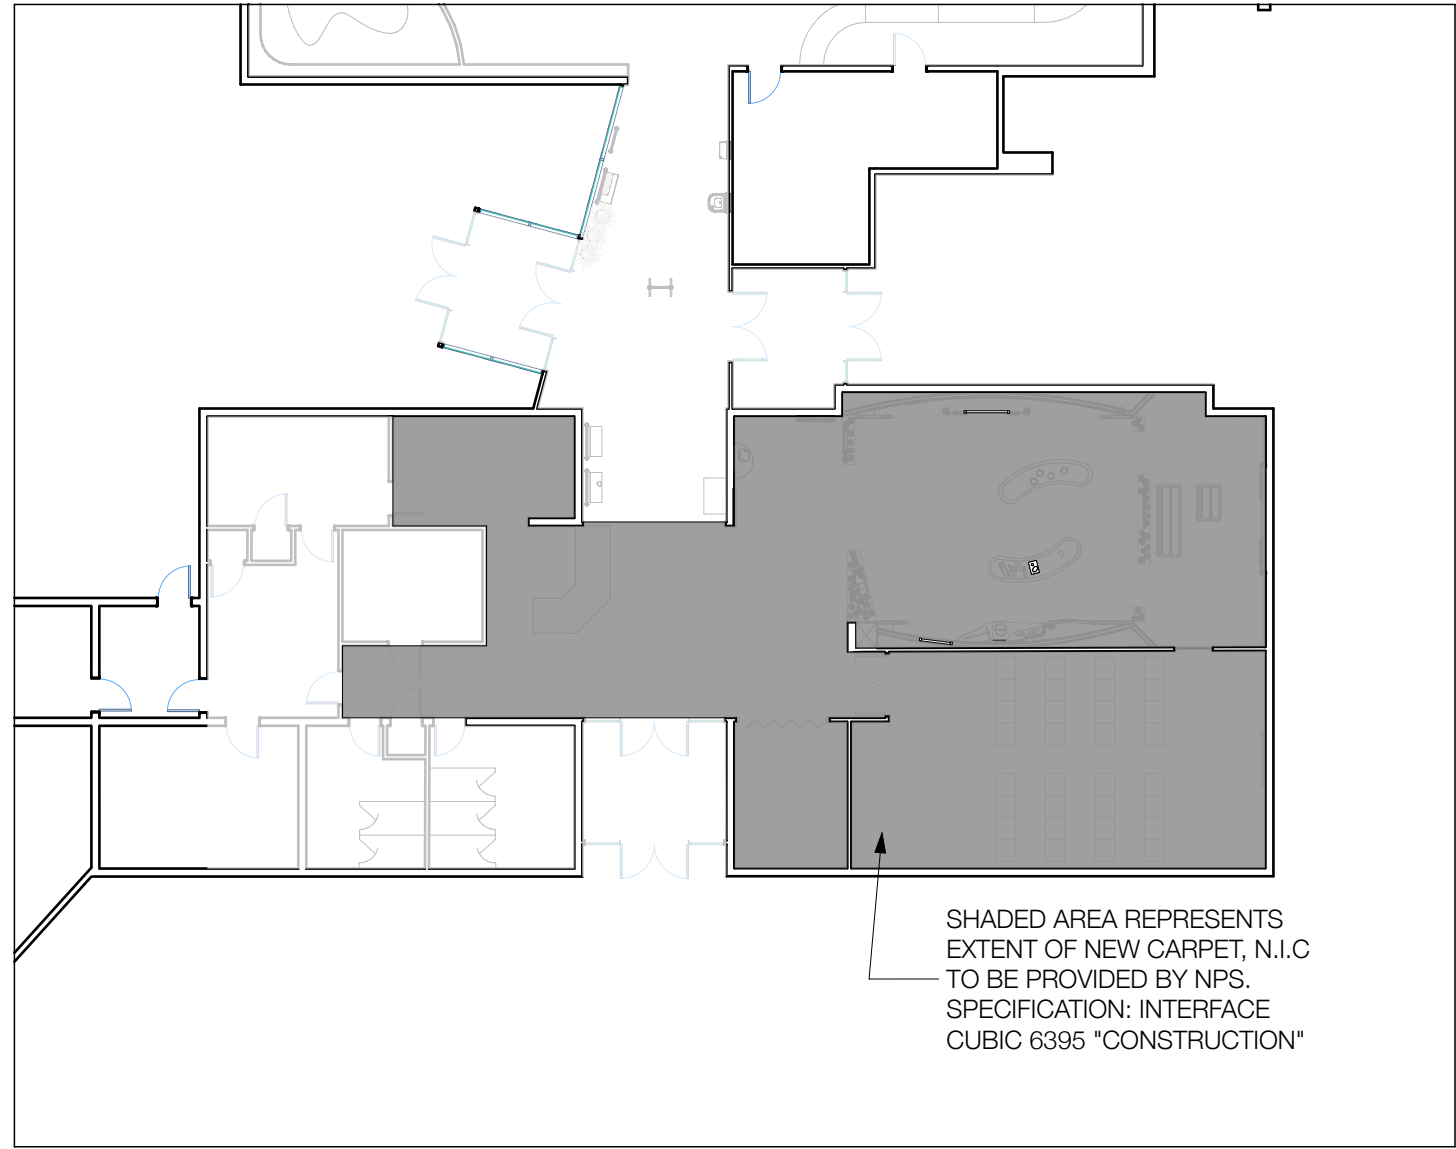

CARPET PLAN
SCALE: 1/16" = 1'-0"

2

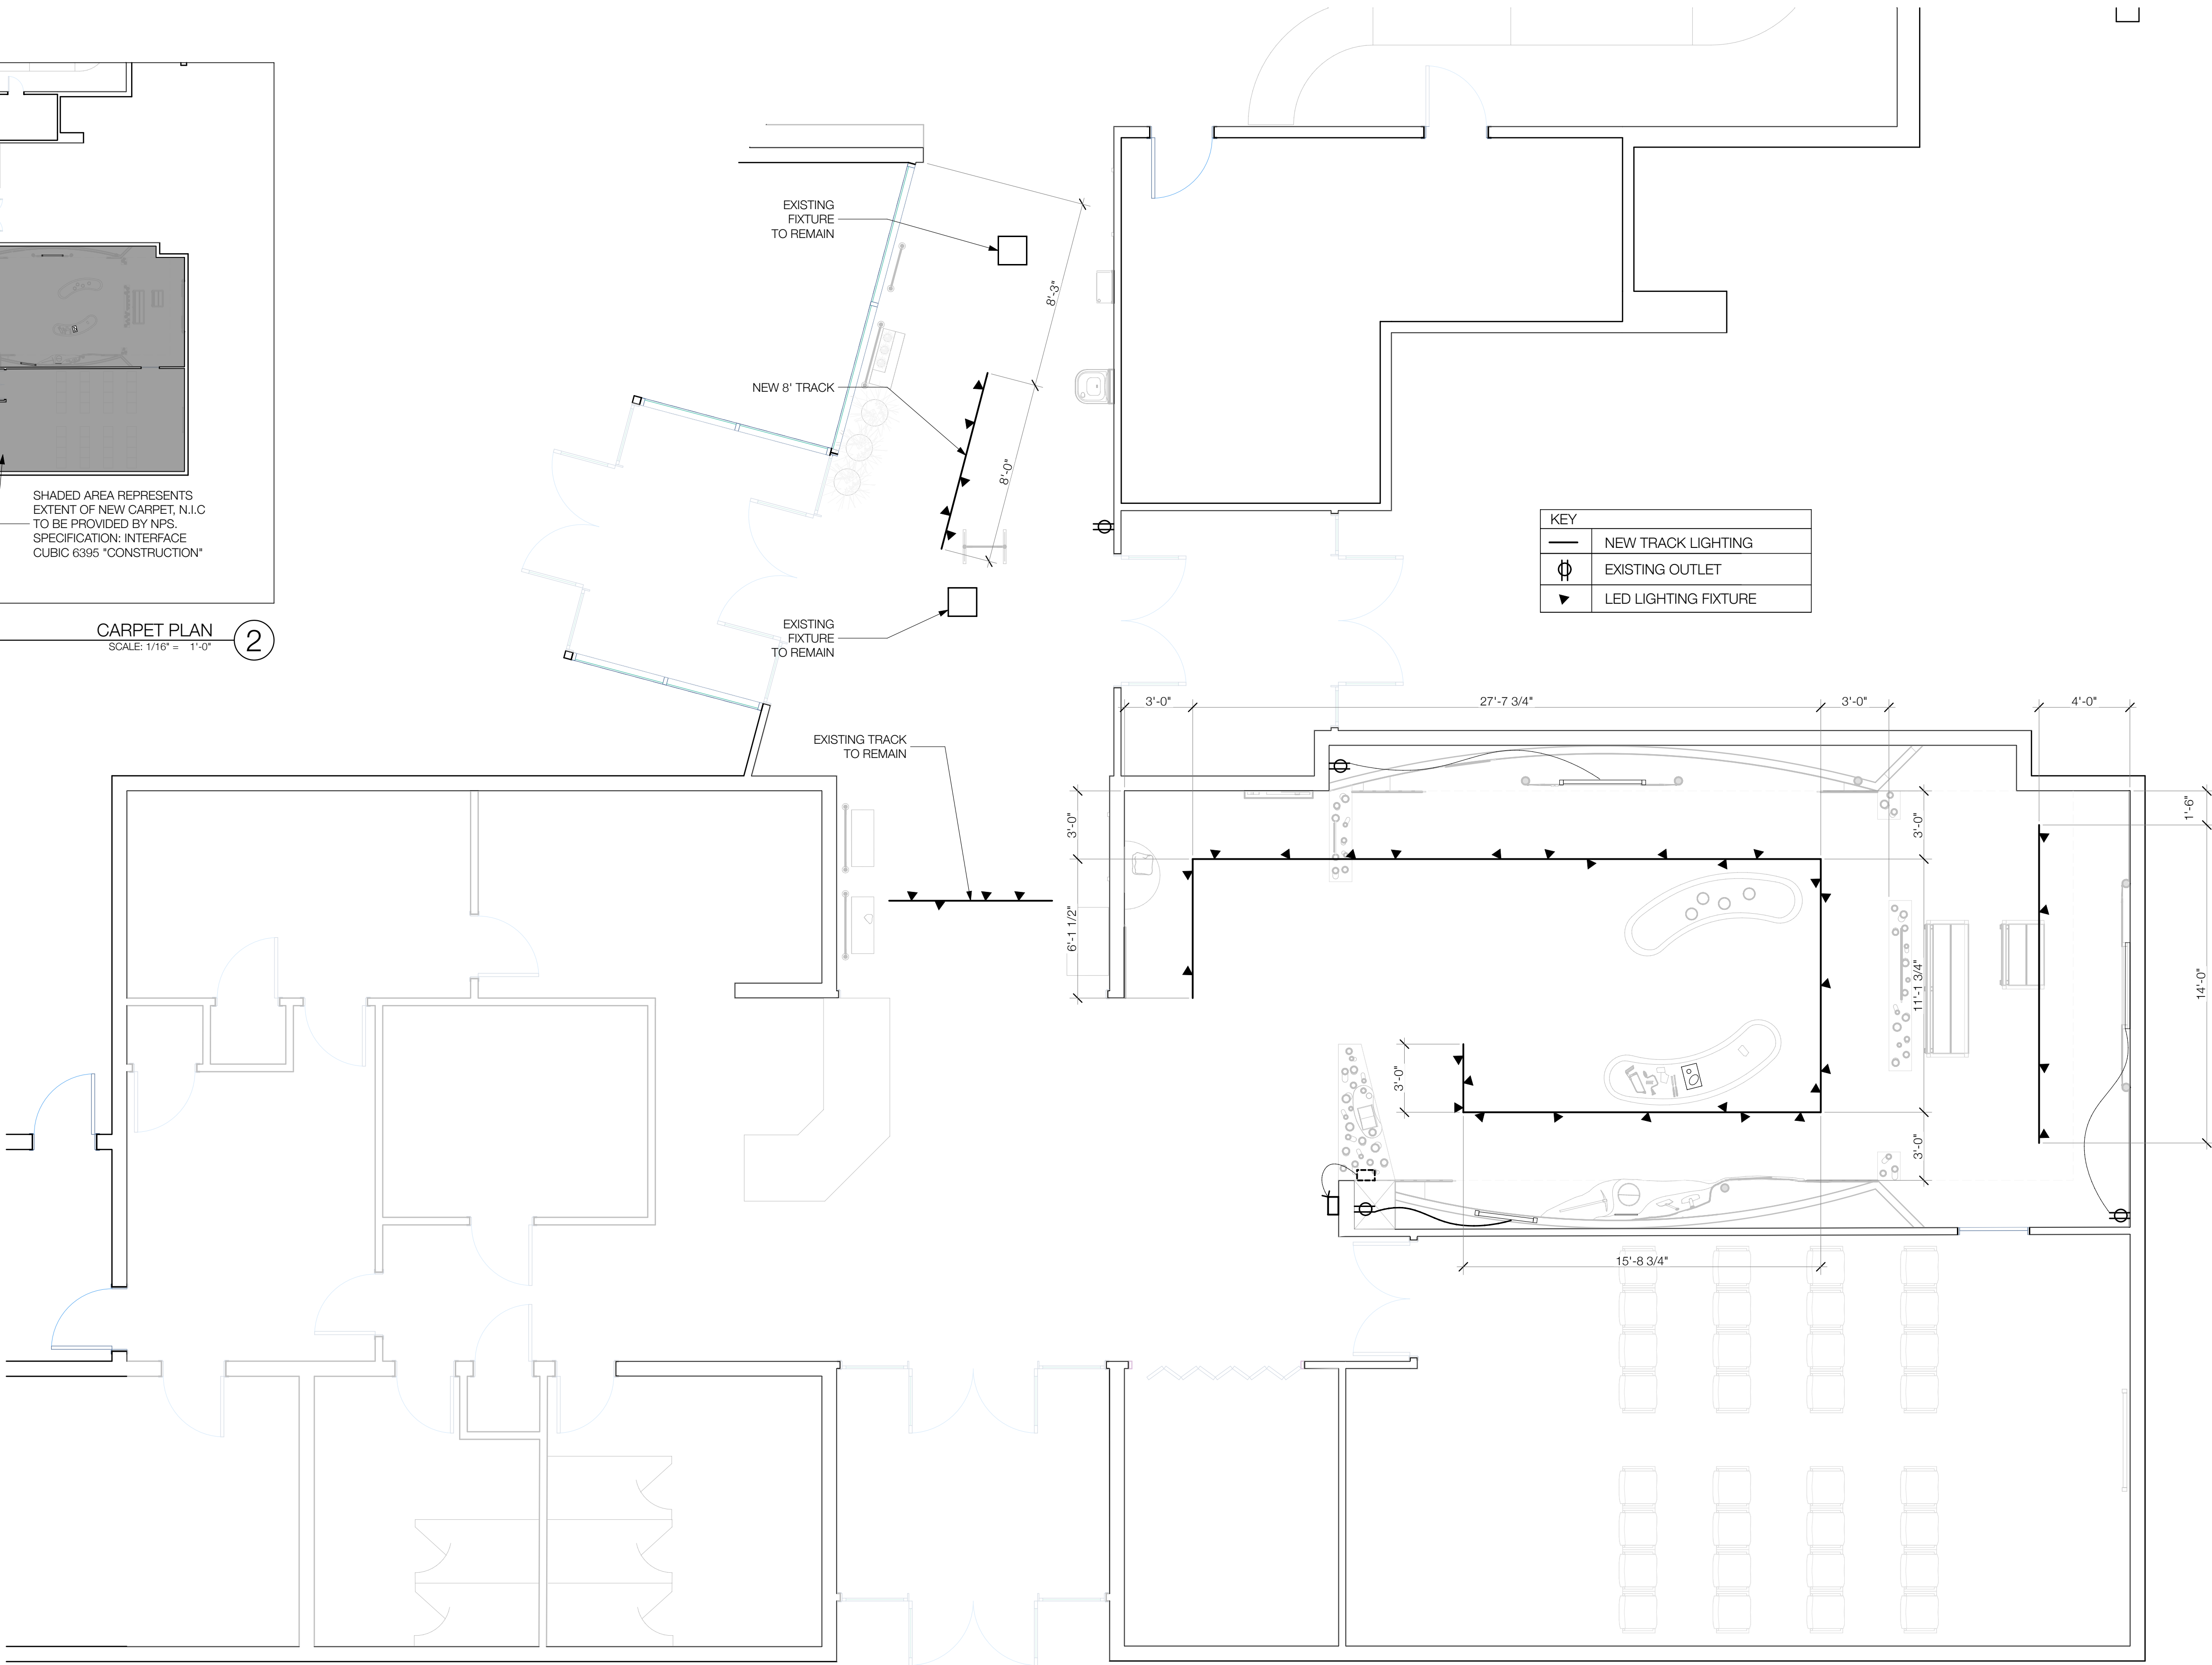

LIGHTING AND ELECTRICAL PLAN
SCALE: 1/4" = 1'-0"

1