 



VISITOR SCREENING FACILITY

FOR THE

WASHINGTON MONUMENT

NATIONAL MALL AND MEMORIAL PARKS
WASHINGTON, DC

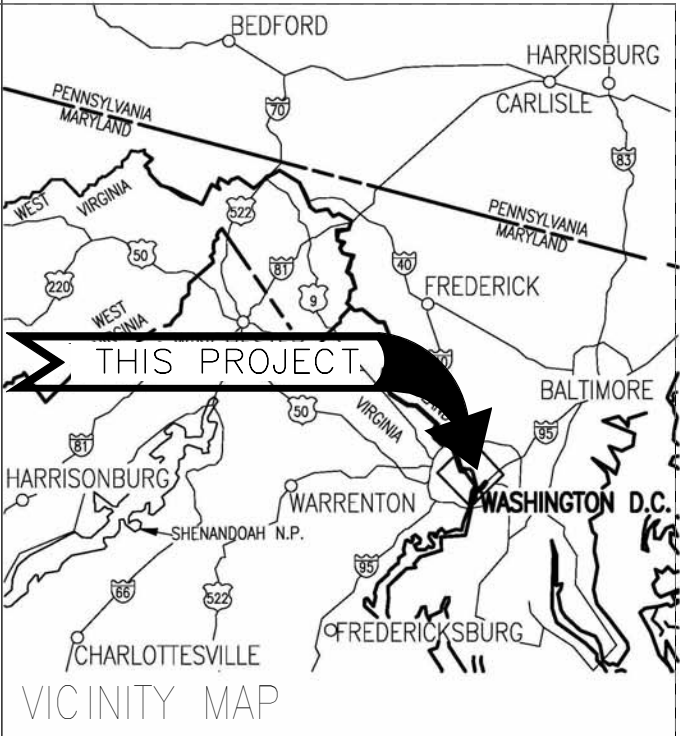

LOCATION MAP



12/30/2016 1:15:24 PM

SUB=CONSULTANTS		A/E FIRM		Mark	Sheet	REVISION	Date	Initial	QUALITY DESIGN CERTIFICATION			100% DRAFT CONSTRUCTION DOCUMENTS		SHEET NO.	TITLE OF PROJECT		DRAWING NO.
SOLTESZ THORNTON TOMASETTI/ WEIDLINGER PROTECTIVE DESIGN PRACTICE JAMES POSEY ASSOCIATES MCLA GHD M2H		BEYER BLINDER BELLE ARCHITECTS & PLANNERS LLP WASHINGTON, DC							☐ Prepared in Accordance with Design Development (Title I) Drawing No. _____ OR ☐ Variance from Design Development (Title I) Approved by Superintendent on _____ Date _____ OR ☐ Construction Drawing Not Preceded by Design Development (Title I) _____ Date _____ Project Manager _____ Date _____	UNITED STATES DEPARTMENT OF THE INTERIOR NATIONAL PARK SERVICE DENVER SERVICE CENTER		C S0.1	DATE: 12/30/2016	VISITOR SCREENING FACILITY LOCATION WITHIN PARK WASHINGTON MONUMENT NAME OF PARK NATIONAL MALL AND MEMORIAL PARKS REGION NATIONAL CAPITAL COUNTY WASHINGTON, DC STATE	807 101713A PMIS/PKG NO. NAMA 151073 SHEET 1 of 129		

PROJECT SUMMARY

PROJECT TITLE:
WASHINGTON MONUMENT VISITOR SCREENING FACILITY

PROJECT LOCATION:
NATIONAL MALL AND MEMORIAL PARK
WASHINGTON, DC

CONTRACT NO: P14PC00250
PMIS NO: 151073

PROJECT DESCRIPTION:
SINGLE LEVEL GLASS AND STEEL CONDITIONED VISITOR
SCREENING FACILITY WITH BALLISTIC AND BLAST
PROTECTION, FOR ENTRY TO WASHINGTON MONUMENT.

DESIGN PHASE:
100% DRAFT CONSTRUCTION DOCUMENT SUBMISSION

BUILDING CODE SUMMARY:

2013 DISTRICT OF COLUMBIA BUILDING CODE SUPPLEMENT (DCMR)
2012 INTERNATIONAL BUILDING CODE (IBC)
2012 INTERNATIONAL FIRE CODE (IFC)
2012 INTERNATIONAL FUEL GAS CODE (IFGC)
2012 INTERNATIONAL MECHANICAL CODE (IMC) –
(AS REFERENCED BY 2012 IBC)
2012 INTERNATIONAL PLUMBING CODE – INCLUDING AMENDMENTS
2011 NATIONAL ELECTRICAL CODE (NEC)
2012 NATIONAL FIRE PROTECTION ASSOCIATION (NFPA) FIRE CODE –
INCLUDING AMENDMENTS
2012 NFPA 101 LIFE SAFETY CODE – INCLUDING AMENDMENTS
ARCHITECTURAL BARRIERS ACT (ABAAS) 2004
NPS–NCR FIRE PROTECTION SYSTEM REQUIREMENTS, REVISED APRIL 24, 2008

CODE AND OCCUPANCY ANALYSIS:

CODE AND OCCUPANCY ANALYSIS BASED UPON IBC 2012,
–SECTION 303 ASSEMBLY GROUP A
–SECTION 1004, OCCUPANT LOAD, TABLE 1004.1.1.

GROSS FLOOR AREA:

PAVILION BASEMENT..... 420 SF
PAVILION FIRST FLOOR..... 649 SF
EXISTING MONUMENT FIRST FLOOR.. 500 SF
ROOF..... 0 SF

TOTAL FIRST FLOOR OCCUPANCY COUNT: 81 PEOPLE BY CALCULATION
(THROUGH TICKETING AND STAFFING)
240 PEOPLE BY OPERATION

OCCUPANCY LOADS AND EGRESS REQUIREMENTS:

USE GROUP ASSEMBLY, A–3

MAX. FLOOR AREA ALLOWANCE PER OCCUPANT (IBC 2012 TABLE 1004.1.1):
1. ASSEMBLY WITHOUT FIXED SEATS, CONCENTRATED (MULTIPURPOSE ROOM): 7 NET
2. EXHIBIT AREAS: 30 NET

CODE AND OCCUPANCY ANALYSIS:

WATER CLOSET (WC) RATIOS: 1 PER 65 (FEMALES)
1 PER 125 (MALES)

TOTAL STAFF OCCUPANTS: (8) PEOPLE = 1 WC, 1 LAVATORY

TYPE CONSTRUCTION (PER TABLE 503 AND SECTION 403.3.1): IIB

ALLOWABLE HEIGHT: 3 STORIES
ALLOWABLE SINGLE FLOOR AREA: 23,000 SF

FIRE PROTECTION SYSTEMS REQUIREMENTS AND FIRE RESISTANCE RATINGS:

AUTOMATIC SPRINKLERS: NO

FIRE ALARM SYSTEM: YES

FIRE RESISTANCE RATING REQUIREMENTS (HOURS):

PRIMARY STRUCTURAL FRAME 0

BEARING WALLS
EXTERIOR..... 0
INTERIOR..... 0

NON–BEARING WALLS AND PARTITIONS
INTERIOR..... 0

FLOOR CONSTRUCTION & SECONDARY MEMBERS..... 0

ROOF CONSTRUCTION & SECONDARY MEMBERS..... 0

INDEX OF DRAWINGS

CS0.1	COVER SHEET	# OF #	1 129
G0.1	PROJECT SUMMARY & SHEET INDEX	2 129	
G0.2	ABBREVIATIONS, SYMBOLS, & NOTES	3 129	
G0.3	EXISTING SITE PLAN	4 129	
G0.4	FIRST FLOOR LIFE SAFETY PLAN	5 129	
C1.0	GENERAL NOTES	6 129	
C1.1	EXISTING CONDITIONS AND DEMOLITION PLAN	7 129	
C1.2	EXISTING CONDITIONS PLAN	8 129	
C1.3	EXISTING CONDITIONS PLAN	9 129	
C1.4	SITE DIMENSION AND UTILITY PLAN	10 129	
C1.5	SITE DIMENSION AND UTILITY PLAN	11 129	
C1.6	SITE DIMENSION AND UTILITY PLAN	12 129	
C1.7	SITE DETAILS	13 129	
C1.8	UTILITY DETAILS & PROFILES	14 129	
C1.9	UTILITY DETAILS	15 129	
C1.10	UTILITY DETAILS	16 129	
C1.11	STORMWATER MANAGEMENT PLAN	17 129	
C1.12	STORMWATER MANAGEMENT NOTES AND DETAILS	18 129	
C1.13	STORMWATER MANAGEMENT NOTES AND DETAILS	19 129	
C1.14	EROSION AND SEDIMENT CONTROL PLAN	20 129	
C1.15	EROSION AND SEDIMENT CONTROL PLAN	21 129	
C1.16	EROSION AND SEDIMENT CONTROL PLAN	22 129	
C1.17	EROSION AND SEDIMENT CONTROL NOTES AND DETAILS	23 129	
C1.18	EROSION AND SEDIMENT CONTROL NOTES AND DETAILS	24 129	
C1.19	EROSION AND SEDIMENT CONTROL NOTES AND DETAILS	25 129	
A1.1	DEMOLITION PLAN	26 129	
A1.2	DEMO ROOF PLAN & ELEVATIONS	27 129	
A1.3	LOWER LEVEL PLAN	28 129	
A1.4	FIRST FLOOR PLAN	29 129	
A1.5	FINISHES PLANS	30 129	
A1.6	SECURE AREA ROOF PLAN	31 129	
A1.7	ROOF PLAN	32 129	
A2.1	REFLECTED CEILING PLAN	33 129	
A2.2	REFLECTED CEILING PLANS	34 129	
A3.1	BUILDING ELEVATIONS	35 129	
A3.2	BUILDING SECTIONS/ ELEVATIONS	36 129	
A3.3	BUILDING SECTIONS	37 129	
A3.4	BUILDING SECTIONS	38 129	
A4.1	WALL SECTIONS	39 129	
A4.2	BUILDING DETAILS	40 129	
A4.3	BUILDING DETAILS	41 129	
A4.4	BUILDING DETAILS	42 129	
A4.5	LOWER LEVEL DETAILS	43 129	
A4.6	ROOF DETAILS	44 129	
A5.1	ELEVATIONS – CURTAIN WALL MOCK–UP	45 129	
A5.2	INTERIOR DETAILS	46 129	
A6.1	PARTITION TYPES	47 129	
A6.2	WINDOW TYPES – INTERIOR	48 129	
A6.3	DOOR TYPES	49 129	
A6.4	DOOR DETAILS	50 129	
A7.1	SIGNAGE	51 129	
S0.1	GENERAL NOTES	52 129	
S0.2	GENERAL NOTES	53 129	
S0.3	GENERAL NOTES	54 129	
S0.4	ABBREVIATIONS AND SPECIAL INSPECTIONS	55 129	
S0.5	LAP SPLICE SCHEDULES	56 129	
S1.1	LOWER LEVEL PLAN	57 129	
S1.2	FIRST FLOOR PLAN	58 129	
S1.3	LOW ROOF PLAN	59 129	
S1.4	ROOF PLAN	60 129	
S1.5	SLAB EDGE LAYOUTS	61 129	
S2.1	TYPICAL FOUNDATION DETAILS	62 129	
S2.2	FOUNDATION SECTIONS AND DETAILS	63 129	
S2.3	FOUNDATION SECTIONS AND DETAILS	64 129	
S3.1	ELEVATIONS	65 129	
S3.2	WALL ELEVATIONS	66 129	
S3.3	BUILDING SECTIONS	67 129	
S3.4	SECTIONS AND DETAILS	68 129	
S3.5	SECTIONS AND DETAILS	69 129	
S3.6	SECTIONS AND DETAILS	70 129	

INDEX OF DRAWINGS

S3.7	SECTIONS AND DETAILS	# OF #	71 129
S3.8	BUNKER #2 MODIFICATIONS		72 129
S4.0	3D VIEWS		73 129
S4.1	3D VIEWS		74 129
M0.0	MECHANICAL SYMBOLS AND ABBREVIATIONS		75 129
MD0.1	BUNKER 1 FLOOR PLAN – DEMOLITION		76 129
MD0.2	BUNKER 2 FLOOR PLAN –DEMOLITION		77 129
MED1.1	MECHANICAL & ELECTRICAL DEMOLITION PLAN		78 129
ME0.1	SITE PLAN		79 129
M0.1	BUNKER 1 FLOOR PLAN – NEW WORK		80 129
M0.2	BUNKER 2 FLOOR PLAN – NEW WORK		81 129
M1.1	LOWER LEVEL FLOOR PLAN – DUCTWORK		82 129
M1.2	FIRST FLOOR PLAN – DUCTWORK		83 129
M1.3	ROOF PLAN – DUCTWORK		84 129
M2.1	LOWER LEVEL FLOOR PLAN – HVAC PIPING		85 129
M3.1	MECHANICAL ELEVATIONS		86 129
M5.1	MECHANICAL DETAILS		87 129
M5.2	MECHANICAL DETAILS		88 129
M5.3	MECHANICAL DETAILS		89 129
M5.4	MECHANICAL DETAILS		90 129
M5.5	MECHANICAL DETAILS		91 129
M6.1	MECHANICAL SCHEDULES		92 129
M6.2	MECHANICAL SCHEDULES		93 129
M7.1	ATC SCHEMATICS		94 129
M7.2	ATC SCHEMATICS		95 129
M7.3	ATC SCHEMATICS		96 129
M7.4	ATC SCHEMATICS		97 129
E0.0	ELECTRICAL SYMBOLS AND ABBREVIATIONS		98 129
ED0.1	BUNKER 1 FLOOR PLAN – DEMOLITION		99 129
ED0.2	BUNKER 2 FLOOR PLAN –DEMOLITION		100 129
E0.1	BUNKER 1 FLOOR PLAN – NEW WORK		101 129
E0.2	BUNKER 2 FLOOR PLAN – NEW WORK		102 129
EL1.1	LOWER LEVEL FLOOR PLAN – LIGHTING		103 129
EL1.2	FIRST FLOOR PLAN – LIGHTING		104 129
EP1.1	LOWER LEVEL FLOOR PLAN – POWER		105 129
EP1.2	FIRST FLOOR – POWER		106 129
E5.1	ELECTRICAL DETAILS		107 129
E6.1	ELECTRICAL DIAGRAMS		108 129
E7.1	ELECTRICAL SCHEDULES		109 129
E7.2	ELECTRICAL SCHEDULES		110 129
E7.3	ELECTRICAL SCHEDULES		111 129
P0.2	BUNKER 2 FLOOR PLAN – PLUMBING		112 129
P1.1	LOWER LEVEL FLOOR PLAN – PLUMBING		113 129
P1.2	FIRST FLOOR PLAN – PLUMBING		114 129
P1.3	ROOF PLAN – PLUMBING		115 129
P5.1	PLUMBING DETAILS		116 129
P5.2	PLUMBING DETAILS		117 129
P6.1	PLUMBING SCHEDULES		118 129
FA0.1	FIRE ALARM REFERENCE SHEET		119 129
FA1.1	LOWER LEVEL & FIRST FLOOR PLAN FIRE ALARM		120 129
FA1.2	LOW ROOF PLAN FIRE ALARM		121 129
FA5.1	DETAIL SHEET AND MATRIX FIRE ALARM		122 129
SE0.0	LEGEND		123 129
SE1.1	LOWER LEVEL & FIRST FLOOR SECURITY/TELECOM/AUDIO VISUAL PLAN		124 129
SE1.2	ROOF LEVEL SECURITY/TELECOM/AUDIO VISUAL PLAN		125 129
SE5.1	SECURITY/TELECOM/AUDIO VISUAL DETAILS		126 129
SE5.2	SECURITY/TELECOM/AUDIO VISUAL DETAILS		127 129
SE5.3	SECURITY/TELECOM/AUDIO VISUAL DETAILS		128 129
SE5.4	SECURITY ACCESS CONTROL SYSTEM DETAIL		129 129

DESIGNED: LD	SUB SHEET NO. GO.1	TITLE OF SHEET PROJECT SUMMARY & SHEET INDEX 100% DRAFT CONSTRUCTION DOCUMENTS WASHINGTON MONUMENT NATIONAL MALL AND MEMORIAL PARKS	DRAWING NO. 807
SA			101713A
TECH. REVIEW: LD			PMIS/PKG NO. NAMA 151073
DATE: 12/30/2016			SHEET 2 of 129

ABBREVIATIONS

&	AND
ABAAS	ARCHITECTURAL BARRIERS ACT
ADJ	ADJACENT/ADJOINING
AFF	ABOVE FINISH FLOOR
AHU	AIR HANDLING UNIT
ALT	ALTERNATE
ARCH	ARCHITECTURAL
AVE	AVENUE
CL	CENTERLINE
C.I.P.	CAST IN PLACE
CLR	CLEAR/CLEARANCE
CLG	CEILING
CONC.	CONCRETE
CORR	CORRIDOR
DN	DOWN
DTL	DETAIL
DWG	DRAWING
EL	ELEVATION
ELEC	ELECTRICAL/ELECTRIC
EMER	EMERGENCY
ENTR	ENTRANCE
EQ	EQUAL
EXG/EXIST	EXISTING
EXT	EXTERIOR
FD	FLOOR DRAIN/FIRE DAMPER
FIN	FINISH
FLR	FLOOR
FS	FLOOR SINK
FE	FIRE EXTINGUISHER
FT	FOOT/FEET
GEN	GENERAL
GWB	GYPSTUM WALL BOARD
HIST	HISTORIC
HP	HIGH POINT
IN	INCH(ES)
JAN	JANITOR
LP	LOW POINT
MAX	MAXIMUM
MECH	MECHANICAL
MIN	MINIMUM
MO	MASONRY OPENING
N	NORTH
NTS	NOT TO SCALE
OC	ON CENTER(S)
OPG	OPENING
OPH	OPPOSITE HAND
OPP	OPPOSITE
PTD	PAINTED
R	RISER
RD	ROOF DRAIN
RM	ROOM
S	SOUTH
SIM	SIMILAR
SQ	SQUARE
SF	SQUARE FEET
SS	STAINLESS STEEL
ST	STREET
STRUCT	STRUCTURAL
T.O.	TOP OF
T.O.S.	TOP OF SLAB
T	TREAD
TYP	TYPICAL
TYP O.S.	TYPICAL OTHER SIDE
V.I.F.	VERIFY IN FIELD
WH	WATER HEATER

SYMBOLS


NORTH ARROW		
SECTION KEY		DETAIL NUMBER DRAWING NUMBER
ELEVATION KEY		DETAIL NUMBER DRAWING NUMBER
INTERIOR ELEVATION KEY		DETAIL NUMBER DRAWING NUMBER
DETAIL KEY		DETAIL NUMBER DRAWING NUMBER
ROOM TAG		ROOM NAME ROOM NUMBER
DOOR TAG		
PARTITION TAG		
WINDOW TAG		
STRUCTURAL GRID LINE		
FLOOR LEVEL		
DETAIL TITLE ON DRAWING SHEET		

ACCESSIBILITY LEGEND

	CLEARANCE: 5'-0" TURNING RADIUS
	DOOR CLEARANCE: PULL SIDE
	DOOR CLEARANCE: PUSH SIDE
	FORWARD/SIDE APPROACH
	KNEE / TOE CLEARANCE


NOTE: PLEASE SEE G0.2 FOR
ADDITIONAL LIFE SAFETY.

TYPICAL MOUNTING HEIGHTS

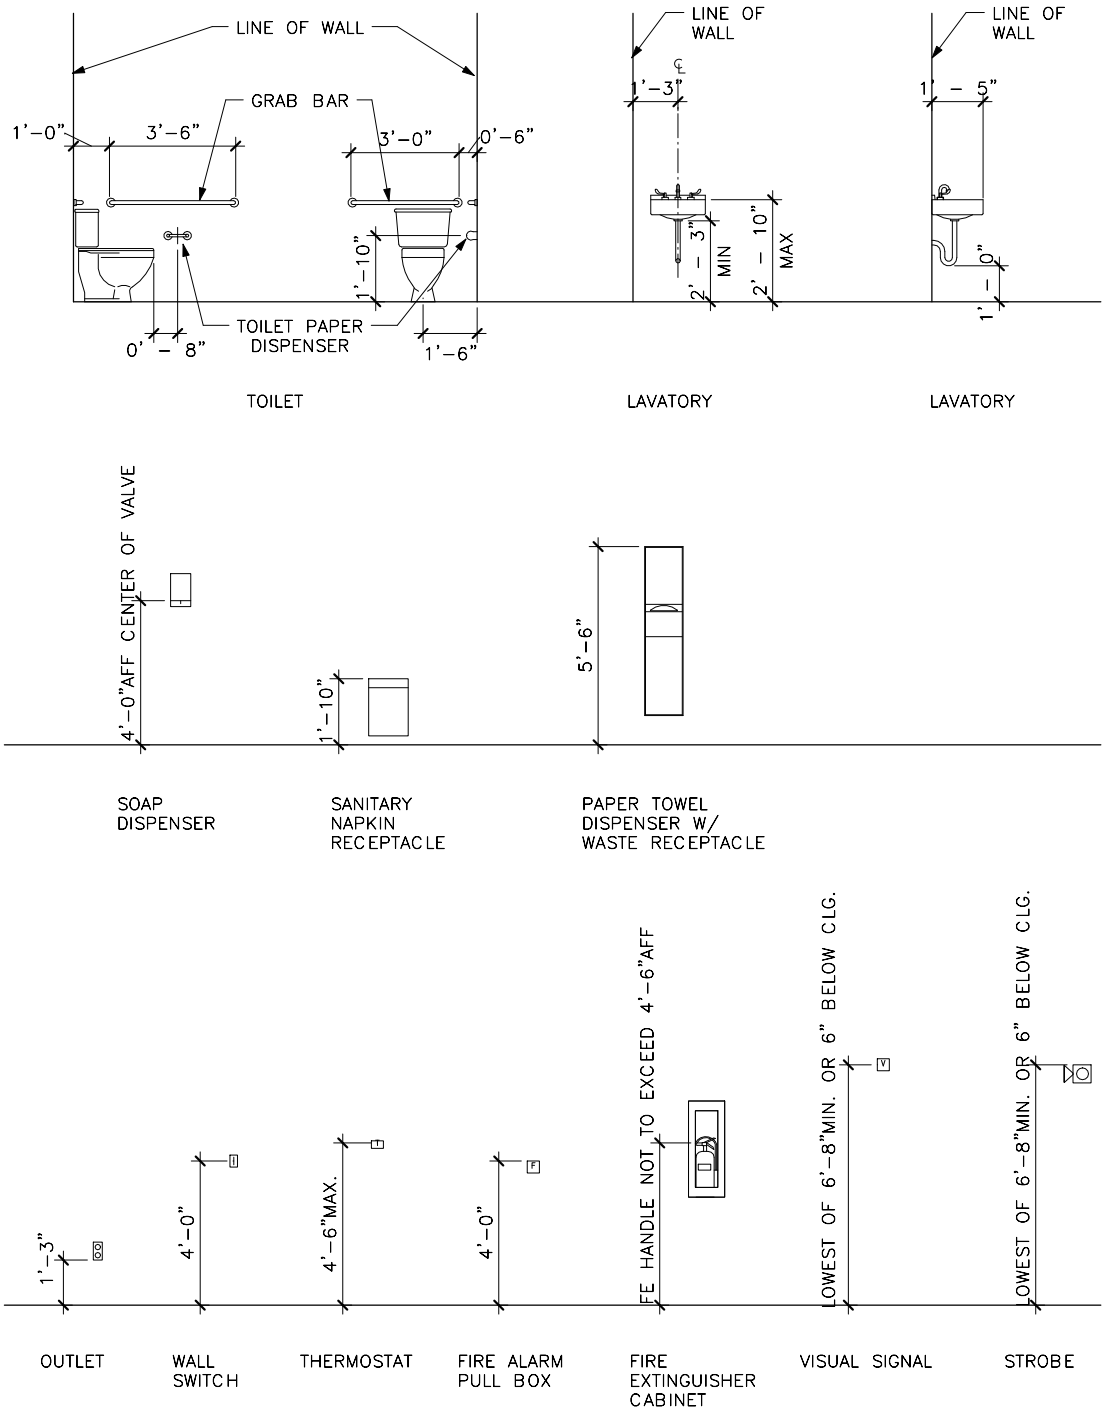

NOTE: FOR SPECIALIZED DEVICE LOCATIONS, SEE ELECTRICAL, SECURITY, TELECOM, A/V AND FIRE ALARM DRAWINGS.

DESIGNED: LD	SUB SHEET NO. G0.2	TITLE OF SHEET ABBREVIATIONS, SYMBOLS, & NOTES 100% DRAFT CONSTRUCTION DOCUMENTS WASHINGTON MONUMENT NATIONAL MALL AND MEMORIAL PARKS	DRAWING NO. 807
SA			101713A
TECH. REVIEW: LD			PMIS/PKG NO. NAMA 151073
DATE: 12/30/2016			SHEET 3 of 129

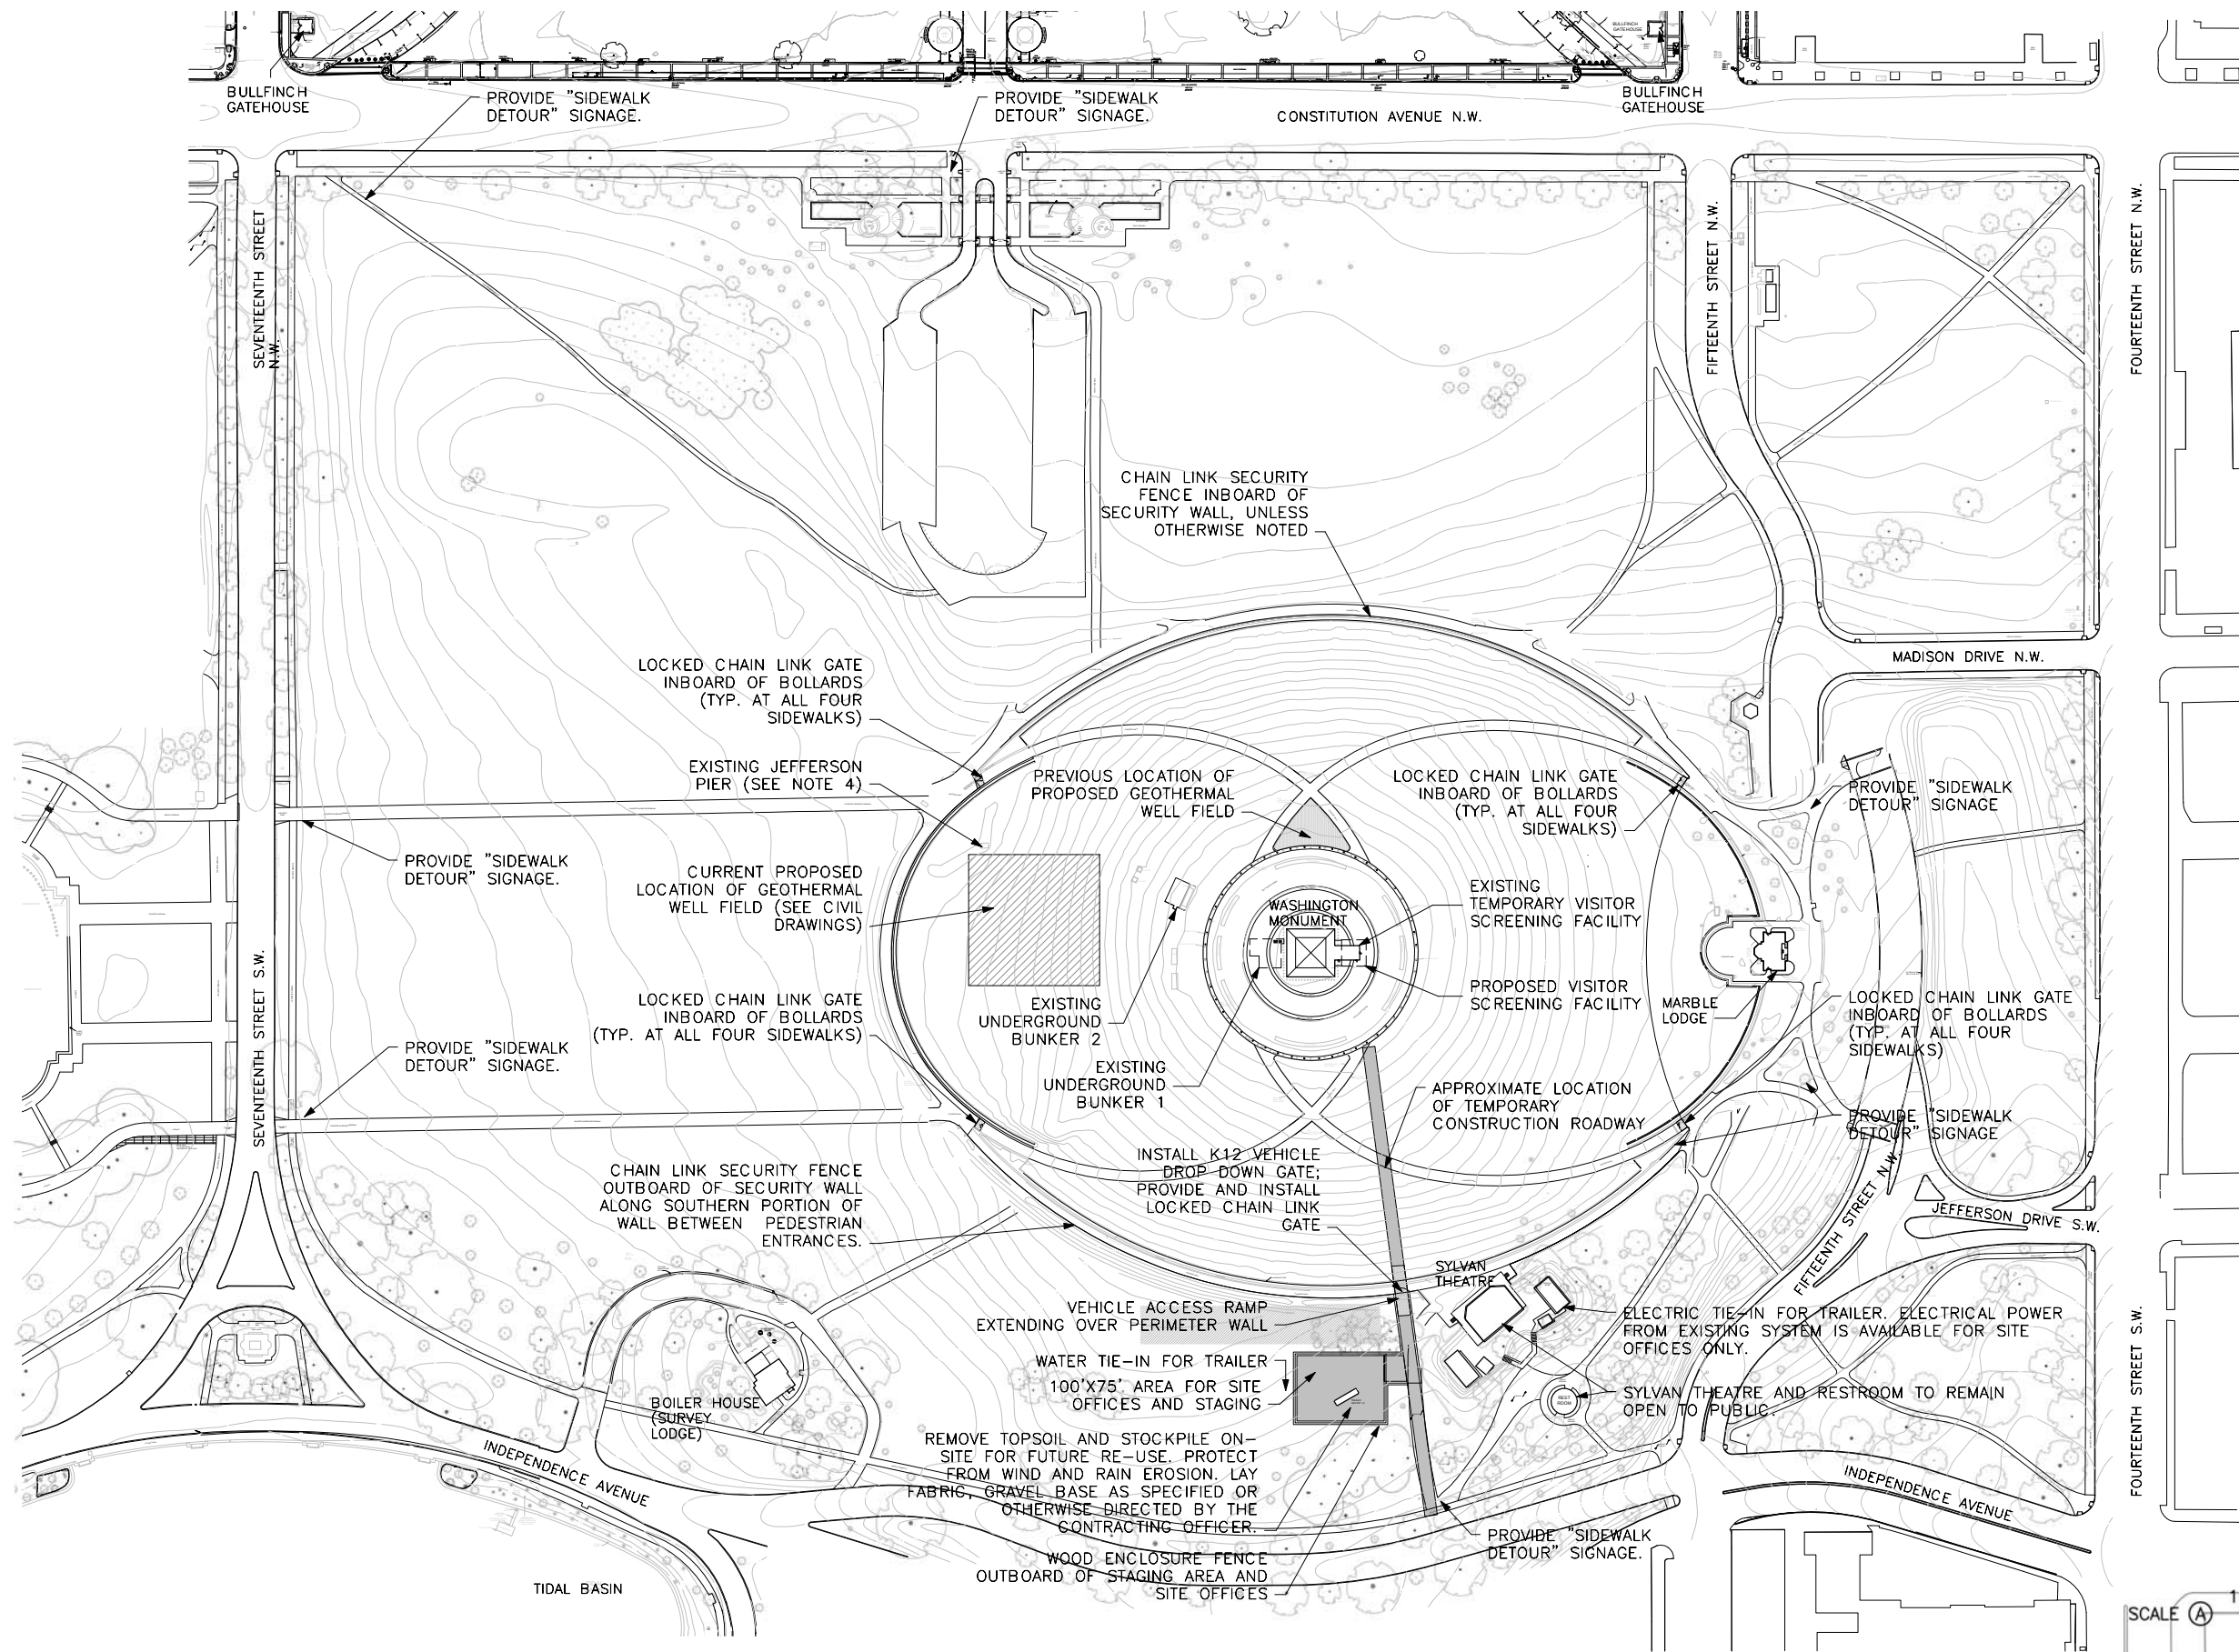

NOTE:


1. EXISTING TREES, SIDEWALKS, GRANITE CURBS, HANDICAP RAMPS (IF ANY), WAYFINDING SIGNS, AND ALL OTHER STREETSCAPE FEATURES MUST BE PROTECTED.
2. INSTALL SEDIMENT AND EROSION CONTROL MEASURES INCLUDING INLET PROTECTION, SILT FENCE, AND TREE PROTECTION. SEE CIVIL DRAWINGS.
3. AT COMPLETION OF CONSTRUCTION, ALL TEMPORARY SEDIMENT AND EROSION CONTROL MEASURES SHALL BE REMOVED. SEE CIVIL DRAWINGS.
4. EXISTING JEFFERSON PIER: CONTRACTOR TO PROTECT STONE PIER AND FOUNDATION DURING ENTIRE PROJECT. PROTECTION MAY NOT BE DIRECTLY AFFIXED TO THE PIER AND MUST BE REMOVED AT THE COMPLETION OF THE PROJECT. DRILLING RIG SHALL NOT BEAR ON, BE PLACED OVER, OR WITHIN 5 FEET OF PIER OR FOUNDATION. MONITOR EXISTING TO PROHIBIT UNDERMINING DURING ENTIRE PROJECT.

1 SITE PLAN
GO.3 SCALE (A)

SCALE (A) 100 0 100 200
SCALE OF FEET

DESIGNED:	SUB SHEET NO.	TITLE OF SHEET	DRAWING NO.
LD	GO.3	EXISTING SITE PLAN	807
SA			101713A
TECH. REVIEW:			PMIS/PKG NO.
LD			NAMA
DATE:			151073
12/30/2016			SHEET
			4 of 129

12/30/2016 1:21:37 PM

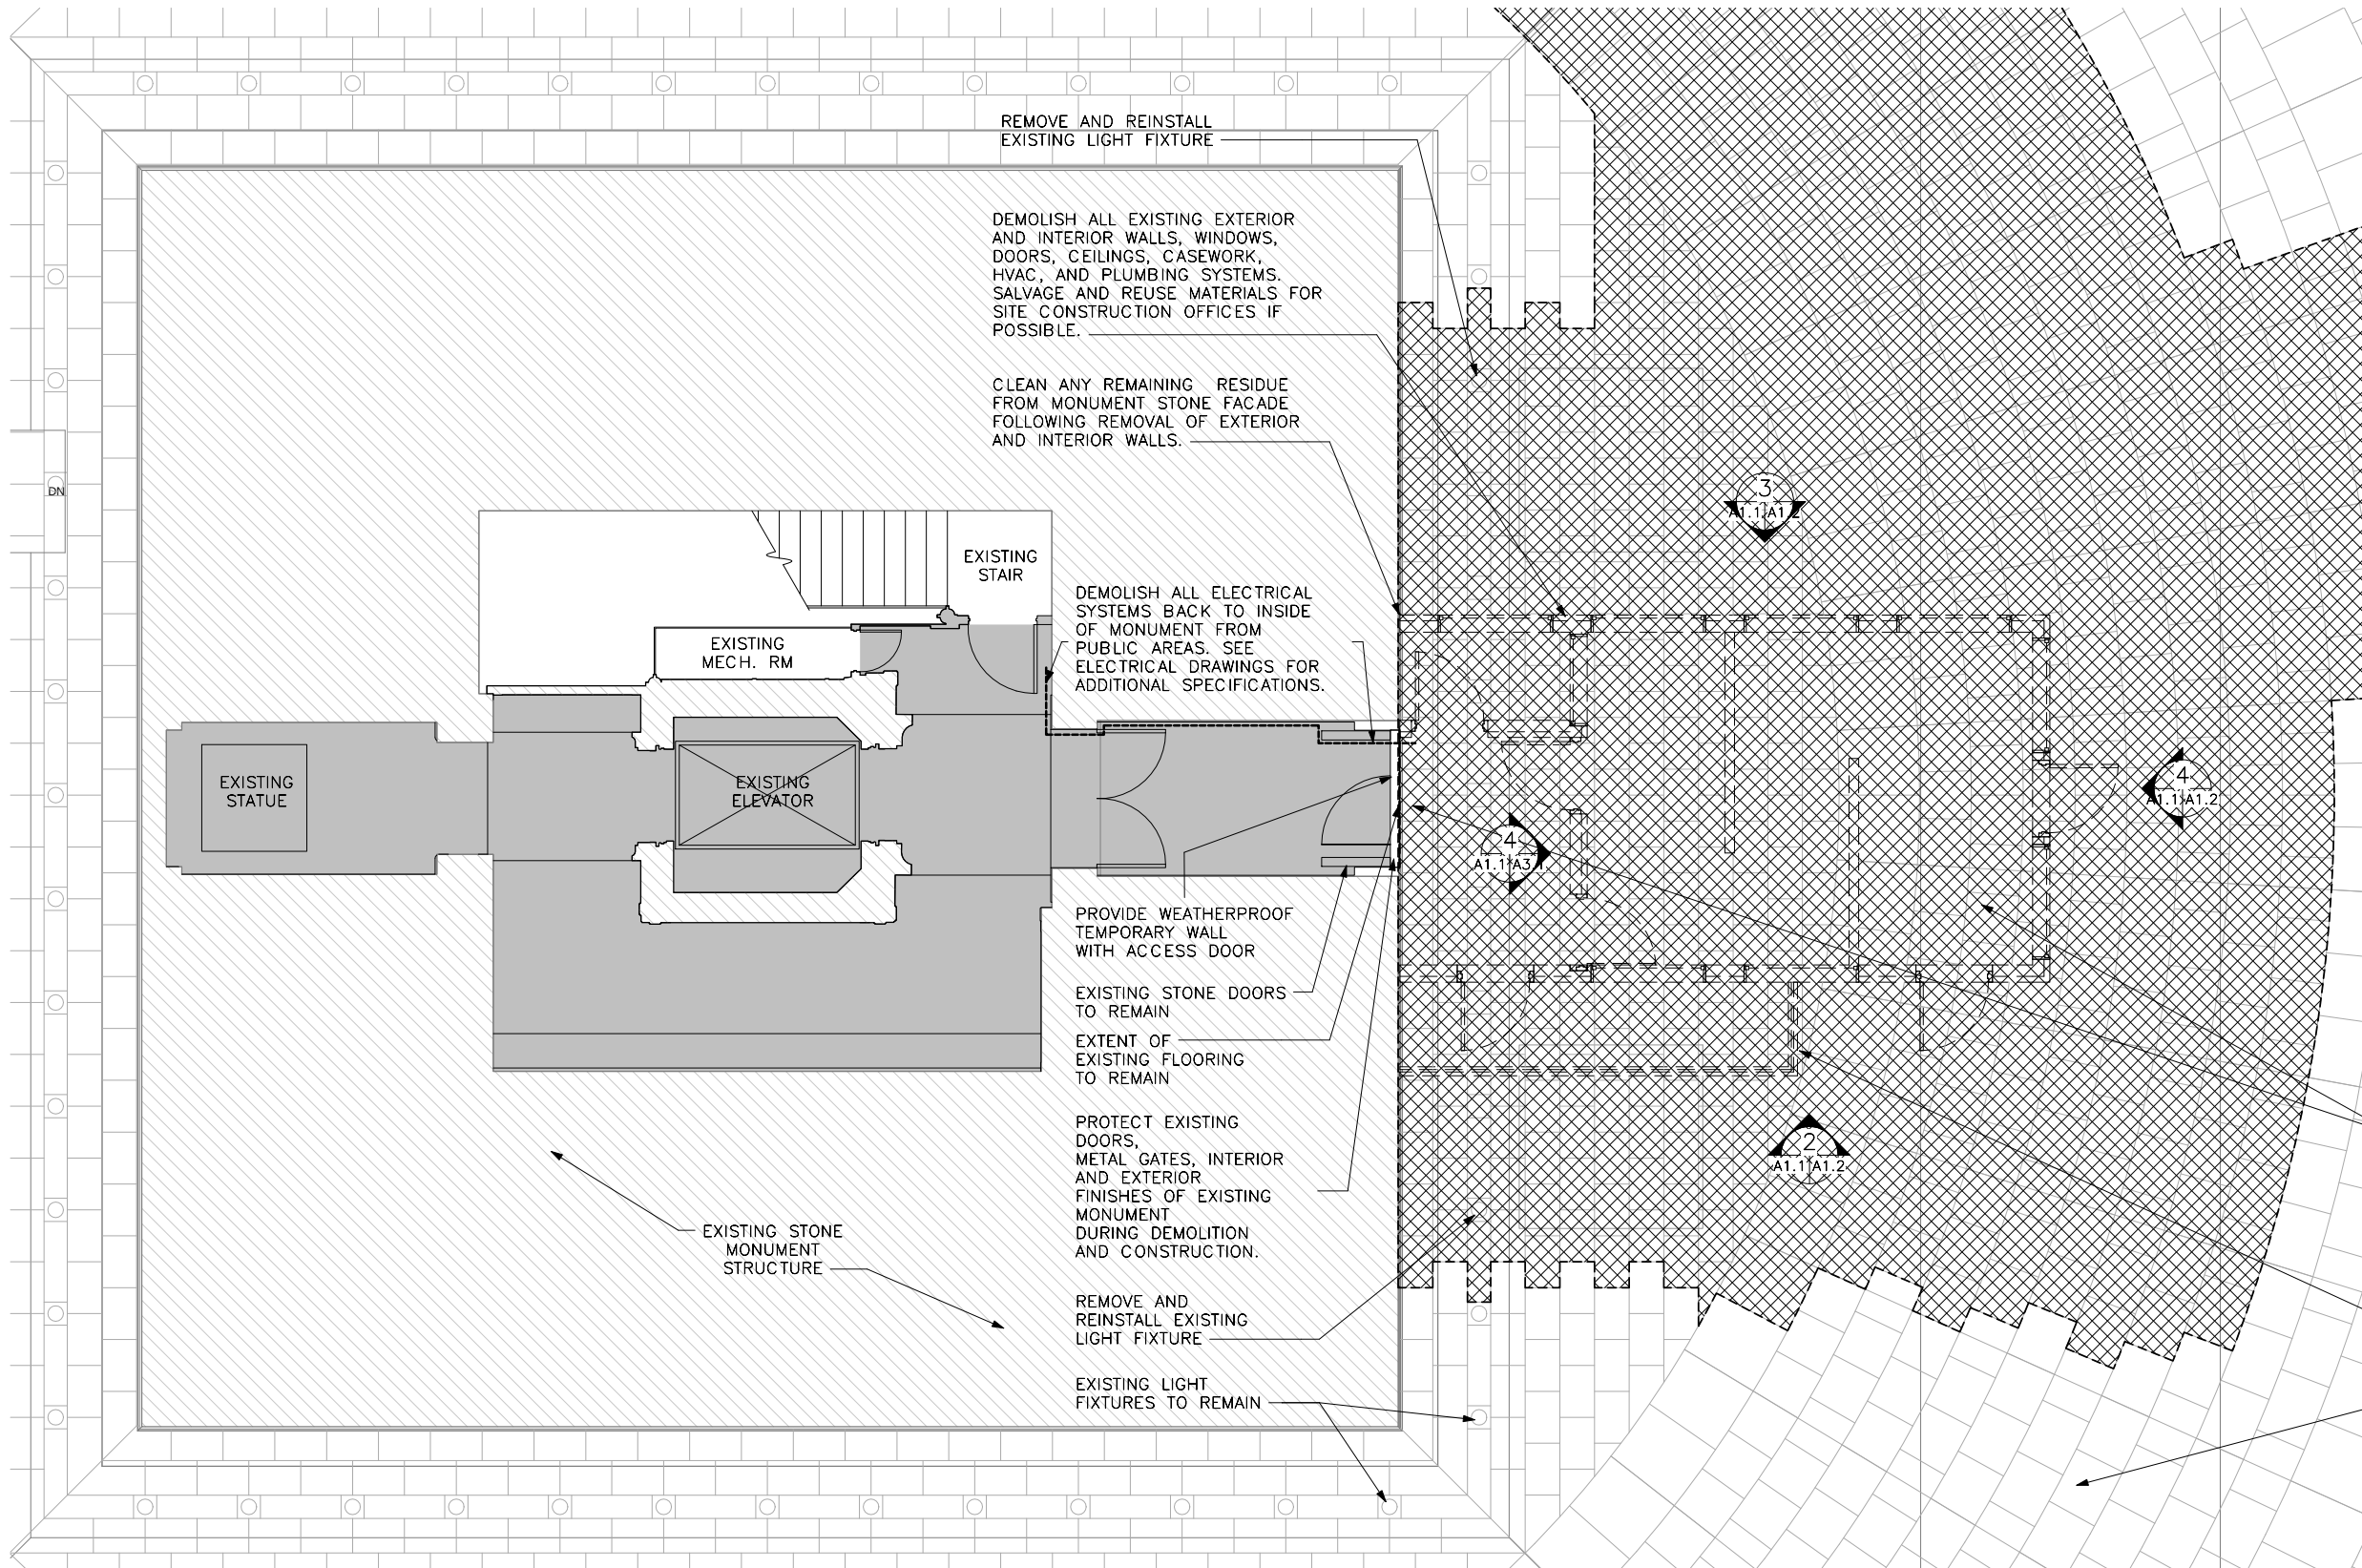

LEGEND — DEMOLITION

- EXISTING MONUMENT OUTSIDE SCOPE OF WORK U.O.N.
- EXISTING STONE MONEMENT STRUCTURE
- EXISTING STONE PAVERS TO BE REMOVED

GENERAL NOTES

1. PROTECT ALL EXISTING SURFACES AND SURROUNDING AREAS OF THE EXISTING FACILITY INCLUDING PATHWAYS FOR REMOVALS ACROSS THE LAWN.
2. CAREFULLY REMOVE EXISTING FACILITY TO NOT DAMAGE THE EXISTING MONUMENT OR STONE PLAZA
3. DEMOUNT PANELS, CONDUIT, FENCES, BUILDING COMPONENTS IN A MANNER THAT DOES NOT DAMAGE THE EXISTING MONUMENT OR STONE PLAZA
4. NOTE AREAS THAT REQUIRE CLEANING OF THE MONUMENT AND PLAZA FROM THE REMOVALS AND PROVIDE CLEANING METHODOLOGY IN COMPLIANCE WITH SPECIFIED PROCESSES FOR APPROVAL BEFORE CLEANING ANY SURFACES
5. INSTALL TEMPORARY WEATHER ENCLOSURE AT EXISTING DOOR TO MONUMENT WITH NO DIRECT ANCHORAGES OR ADHESIVES TO THE MONUMENT TO PROVIDE A FULLY REVERSIBLE SOLUTION.
6. PATCH ALL ANCHOR HOLES FROM EXISTING ATTACHMENTS. SEE SPECIFICATIONS FOR INFORMATION RELATED TO PATCHING AND REPAIRING HISTORIC MATERIALS.
7. REMOVE AND SALVAGE ALL EXISTING EQUIPMENT. CONTRACTOR TO COORDINATE ALL REMOVALS WITH USPP.

REMOVE AND SALVAGE EXISTING STONE PAVING AS NECESSARY UP TO MONUMENT DOOR THRESHOLD. SEE CIVIL DRAWINGS FOR EXTENT OF PAVER REMOVAL NECESSARY FOR UTILITIES.

REMOVE EXISTING FENCE AND GATE



EXISTING PAVING TO REMAIN; SEE CIVIL DRAWINGS FOR LIMITS OF DISTURBANCE




1 First Floor Demolition
A1.1 SCALE (A)

DESIGNED:	SUB SHEET NO.	TITLE OF SHEET	DRAWING NO.
LD	A1.1	DEMOLITION PLAN	807
SA			101713A
TECH. REVIEW:			PMIS/PKG NO.
LD			NAMA
DATE:			151073
12/30/2016			SHEET
		100% DRAFT CONSTRUCTION DOCUMENTS	26 of 129
		WASHINGTON MONUMENT	
		NATIONAL MALL AND MEMORIAL PARKS	


1 ROOF PLAN DEMOLITION
SCALE (A)

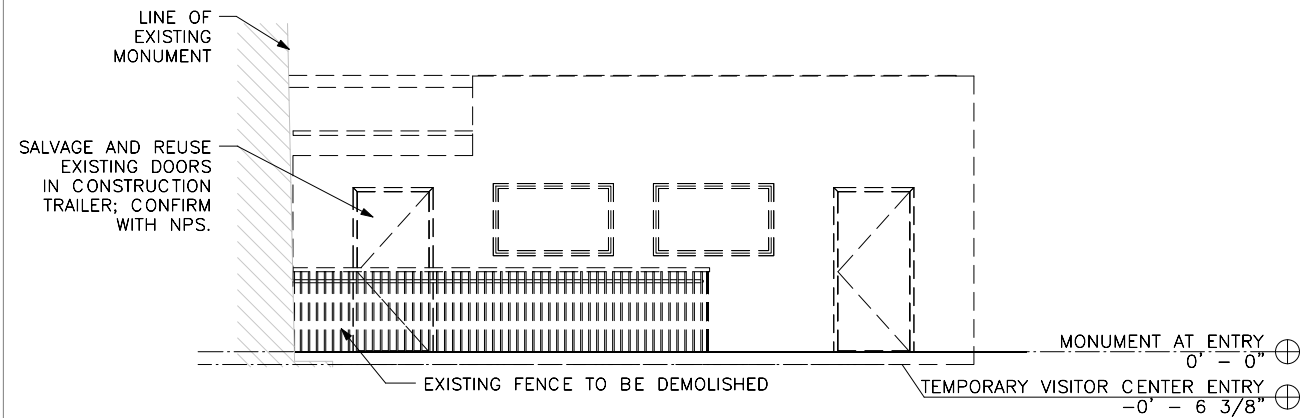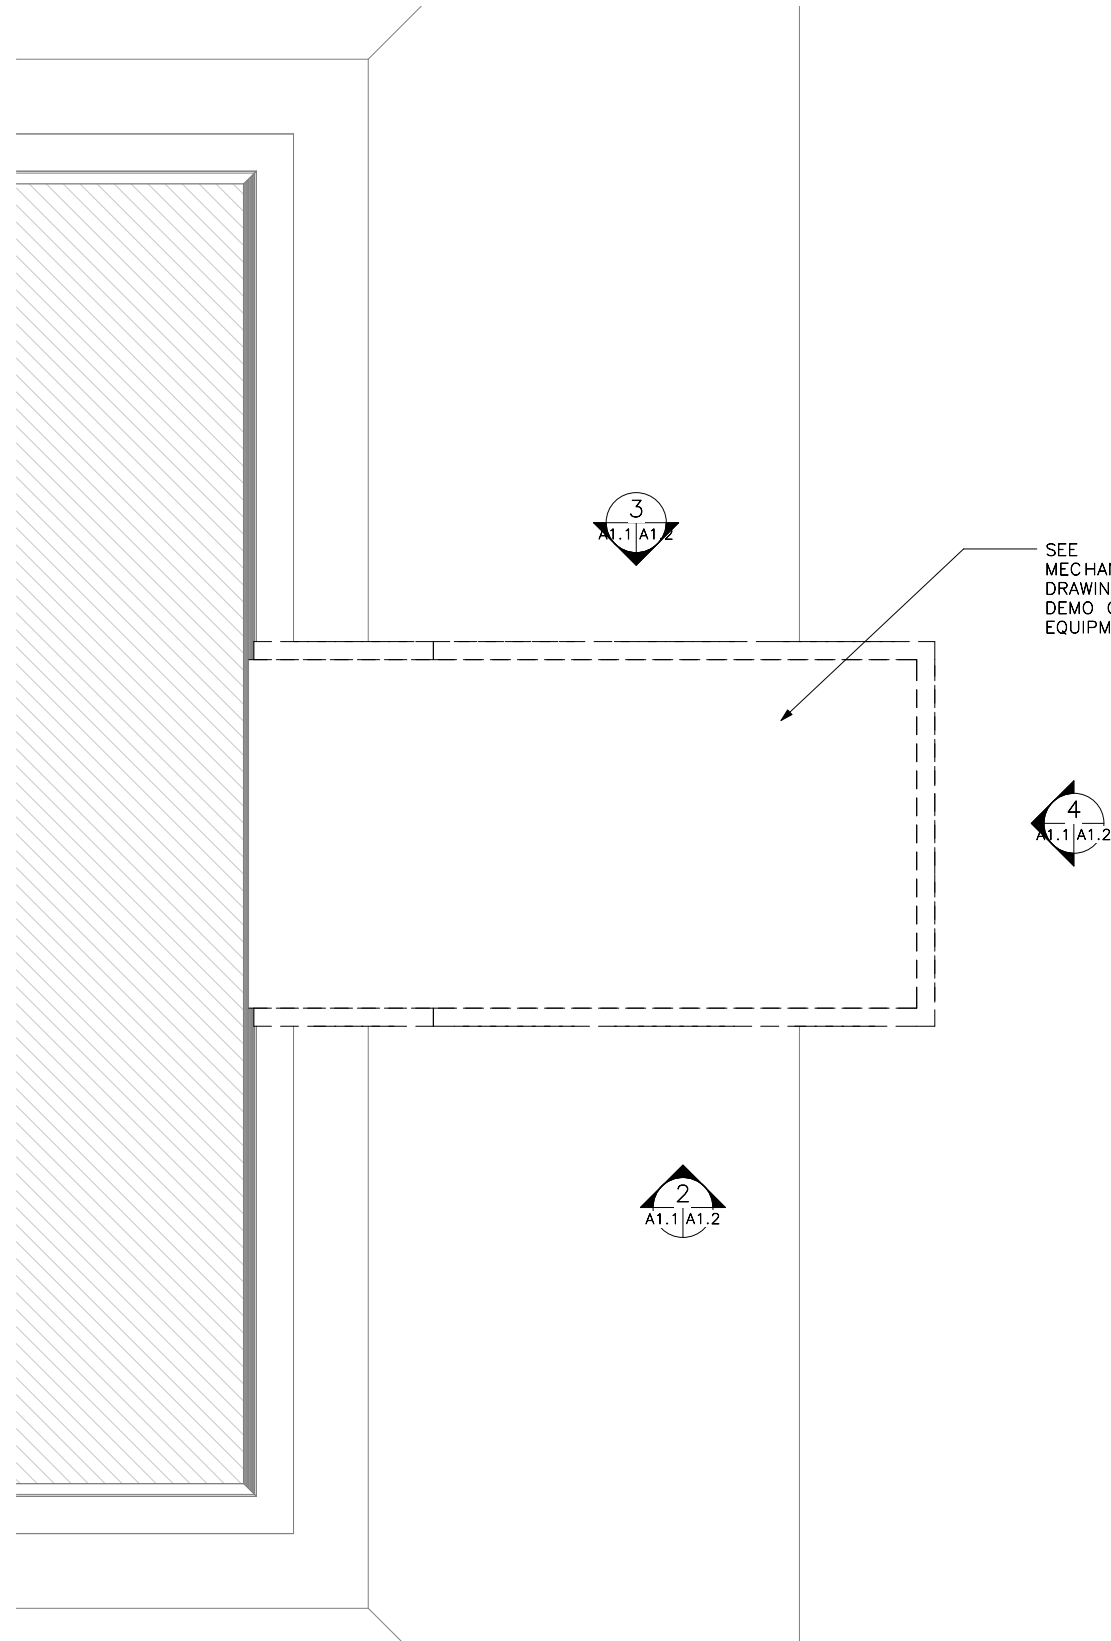

2 SOUTH ELEV. - DEMO
SCALE (A)

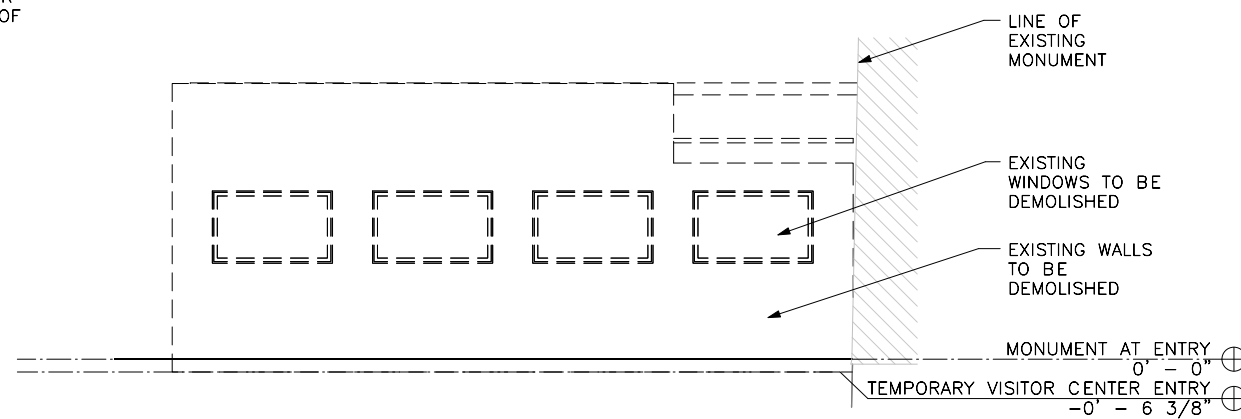


3 NORTH ELEV. - DEMO
SCALE (A)

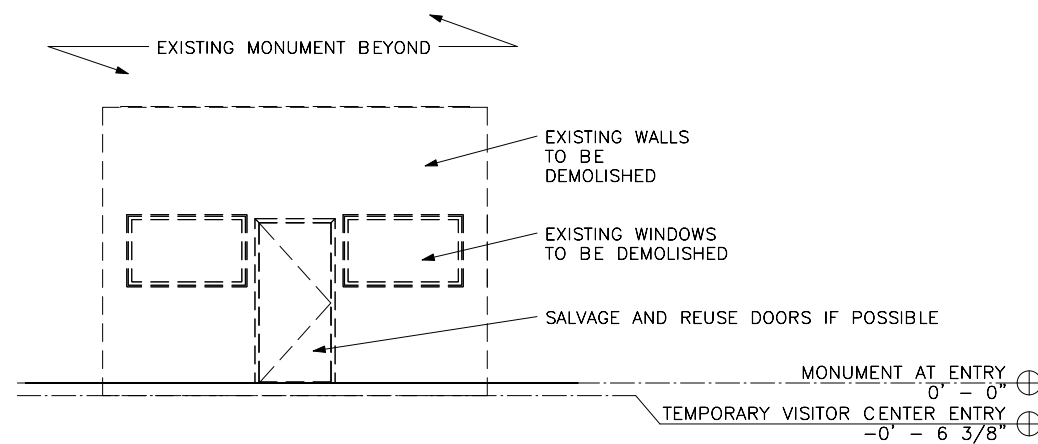

4 EAST ELEV. - DEMO
SCALE (A)

LEGEND - DEMOLITION

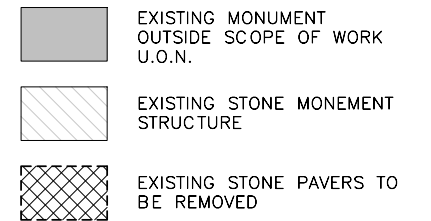

GENERAL NOTES

1. PROTECT ALL EXISTING SURFACES AND SURROUNDING AREAS OF THE EXISTING FACILITY INCLUDING PATHWAYS FOR REMOVALS ACROSS THE LAWN.
2. CAREFULLY REMOVE EXISTING FACILITY TO NOT DAMAGE THE EXISTING MONUMENT OR STONE PLAZA
3. DEMOUNT PANELS, CONDUIT, FENCES, BUILDING COMPONENTS IN A MANNER THAT DOES NOT DAMAGE THE EXISTING MONUMENT OR STONE PLAZA
4. NOTE AREAS THAT REQUIRE CLEANING OF THE MONUMENT AND PLAZA FROM THE REMOVALS AND PROVIDE CLEANING METHODOLOGY IN COMPLIANCE WITH SPECIFIED PROCESSES FOR APPROVAL BEFORE CLEANING ANY SURFACES
5. INSTALL TEMPORARY WEATHER ENCLOSURE AT EXISTING DOOR TO MONUMENT WITH NO DIRECT ANCHORAGES OR ADHESIVES TO THE MONUMENT TO PROVIDE A FULLY REVERSIBLE SOLUTION.
6. PATCH ALL ANCHOR HOLES FROM EXISTING ATTACHMENTS. SEE SPECIFICATIONS FOR INFORMATION RELATED TO PATCHING AND REPAIRING HISTORIC MATERIALS.
7. REMOVE AND SALVAGE ALL EXISTING EQUIPMENT. CONTRACTOR TO COORDINATE ALL REMOVALS WITH USPP.



DESIGNED:	SUB SHEET NO.	TITLE OF SHEET	DRAWING NO.
LD	A1.2	DEMO ROOF PLAN & ELEVATIONS	807
SA			101713A
TECH. REVIEW:			PMIS/PKG NO.
LD			NAMA
DATE:		100% DRAFT CONSTRUCTION DOCUMENTS	151073
12/30/2016		WASHINGTON MONUMENT	SHEET
		NATIONAL MALL AND MEMORIAL PARKS	27 of 129


DESIGNED:	SUB SHEET NO.	TITLE OF SHEET	DRAWING NO.
LD	A1.3	LOWER LEVEL PLAN	807
DATE			101713A
SA			PMIS/PKG NO.
TECH. REVIEW:			NAMA
LD			151073
DATE:		100% DRAFT CONSTRUCTION DOCUMENTS	SHEET
12/30/2016		WASHINGTON MONUMENT	28 of 129
		NATIONAL MALL AND MEMORIAL PARKS	

12/30/2016 1:21:40 PM

1 First Floor
A1.4 SCALE (A)


GENERAL NOTES:

1. FOR EXISTING PAVING PATTERN SEE A1.5
2. FOR SPOT ELEVATIONS, SLOPES, AND ALIGNMENTS OF SLOPED WALKWAYS, SEE A1.5

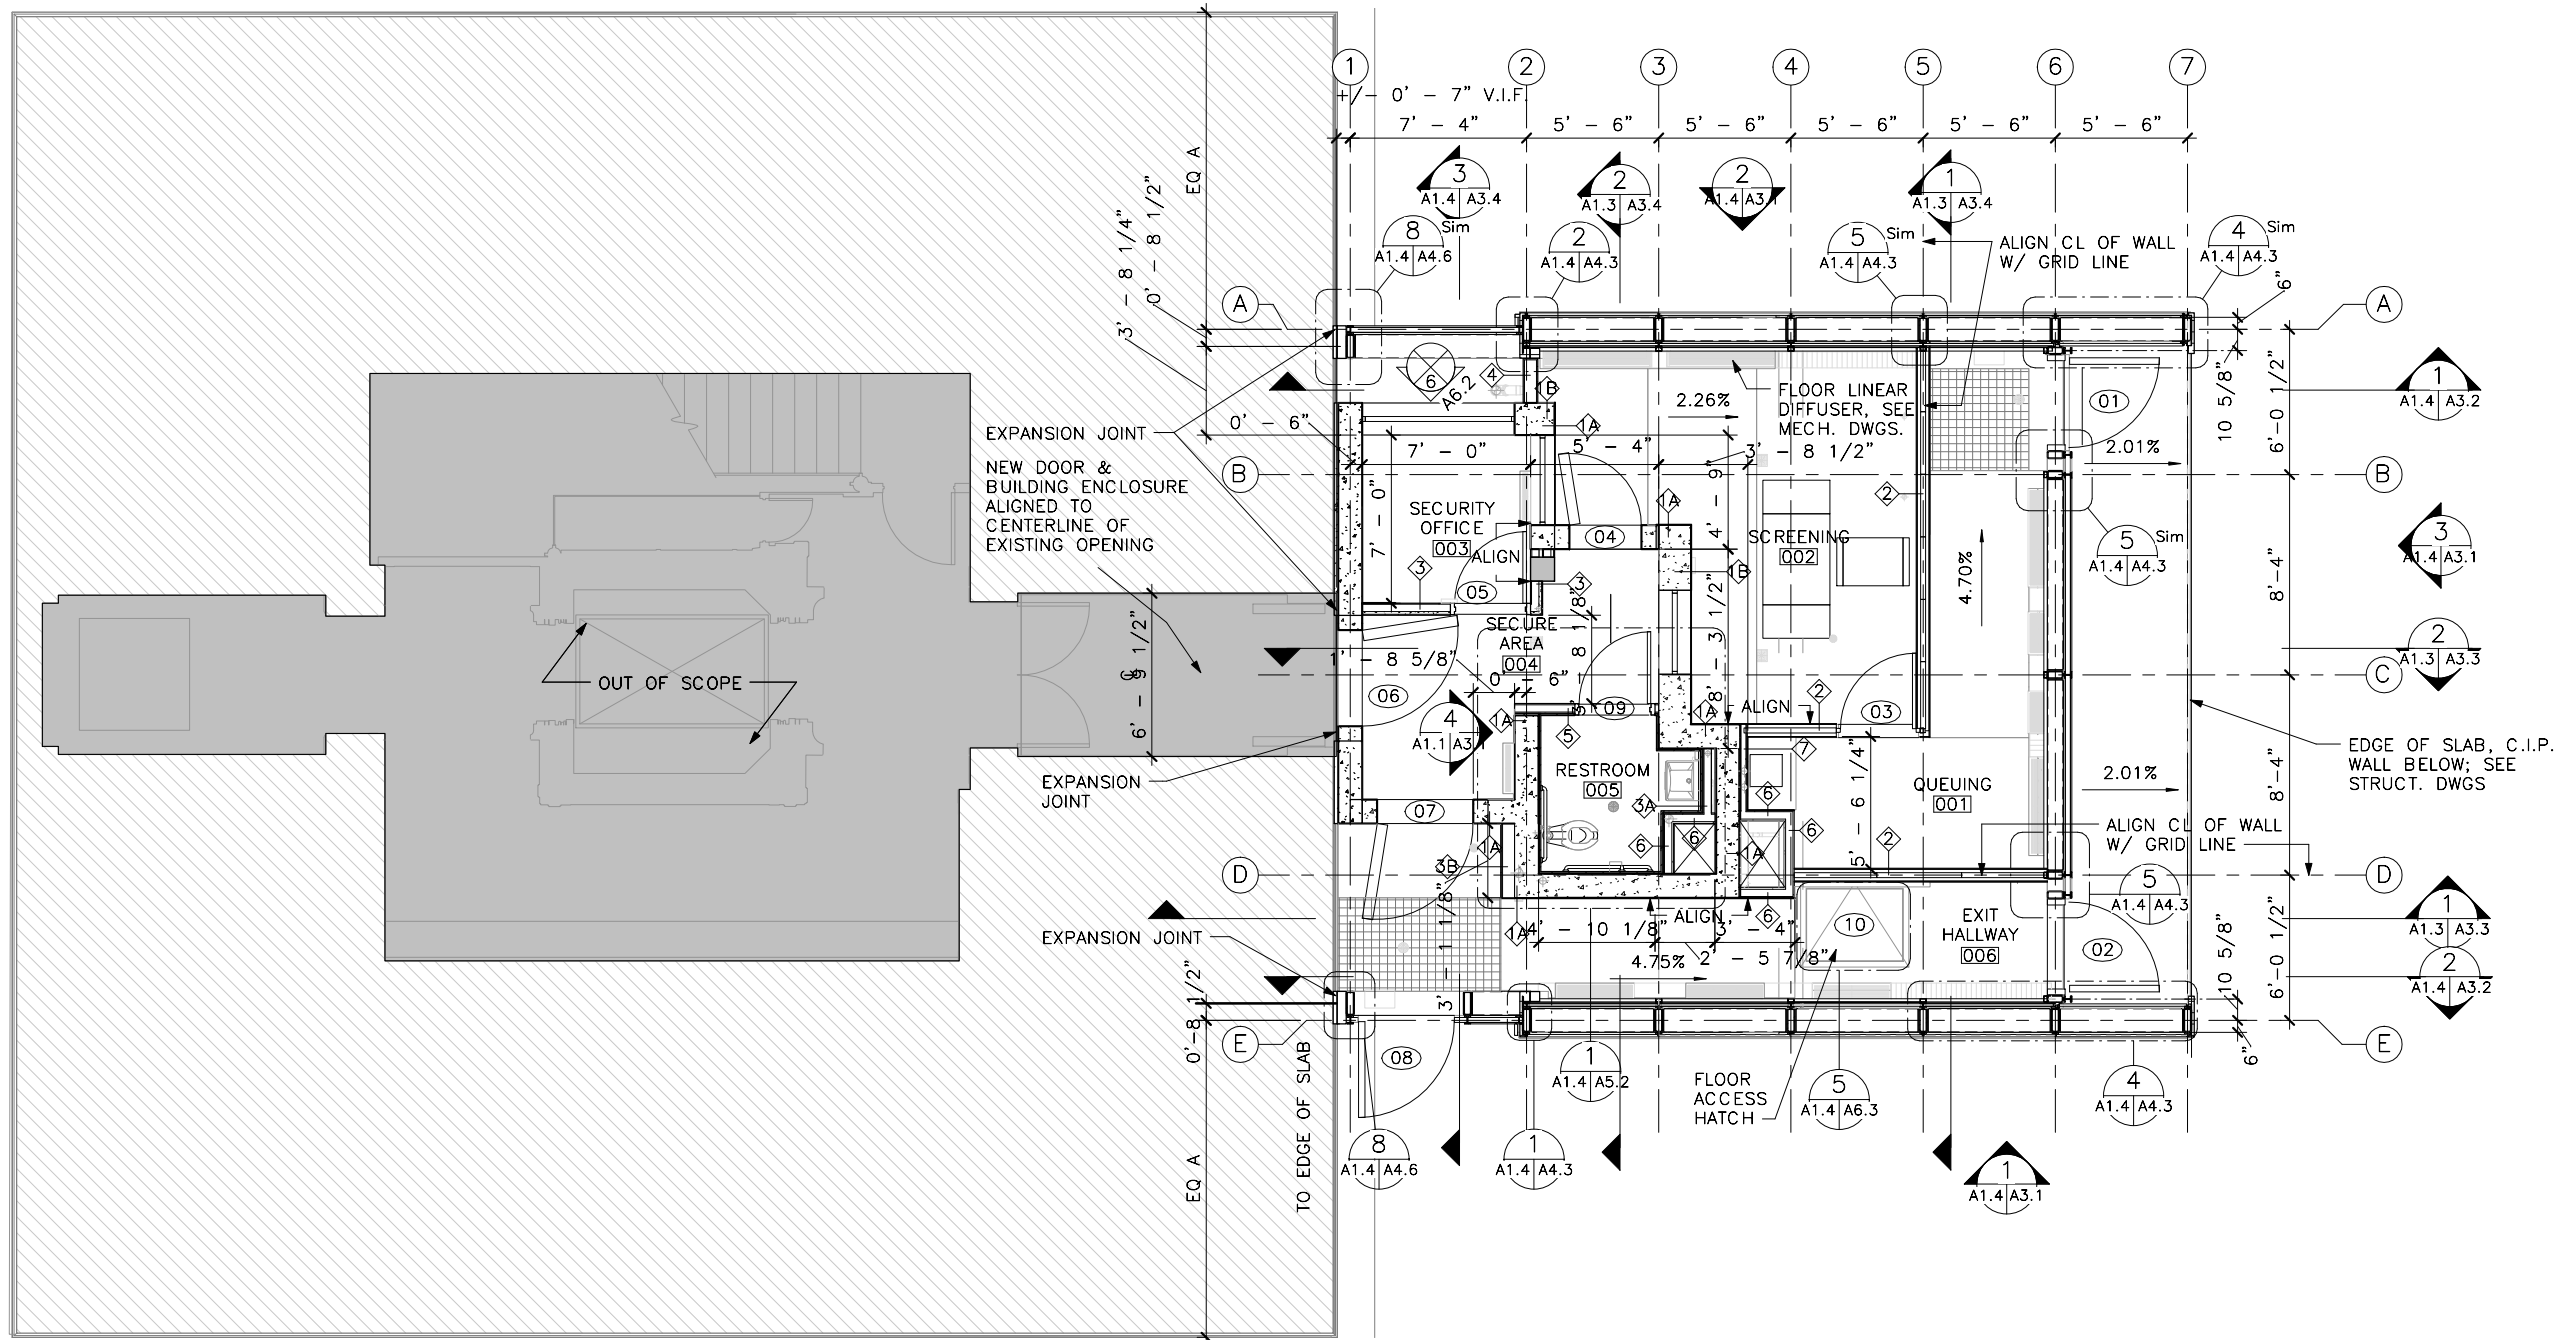

DESIGNED:	SUB SHEET NO.	TITLE OF SHEET	DRAWING NO.
LD	A1.4	FIRST FLOOR PLAN	807
BC			101713A
TECH. REVIEW:			PMIS/PKG NO.
LD			NAMA
DATE:		100% DRAFT CONSTRUCTION DOCUMENTS	151073
12/30/2016		WASHINGTON MONUMENT	SHEET
		NATIONAL MALL AND MEMORIAL PARKS	29 of 129

12/30/2016 1:21:45 PM

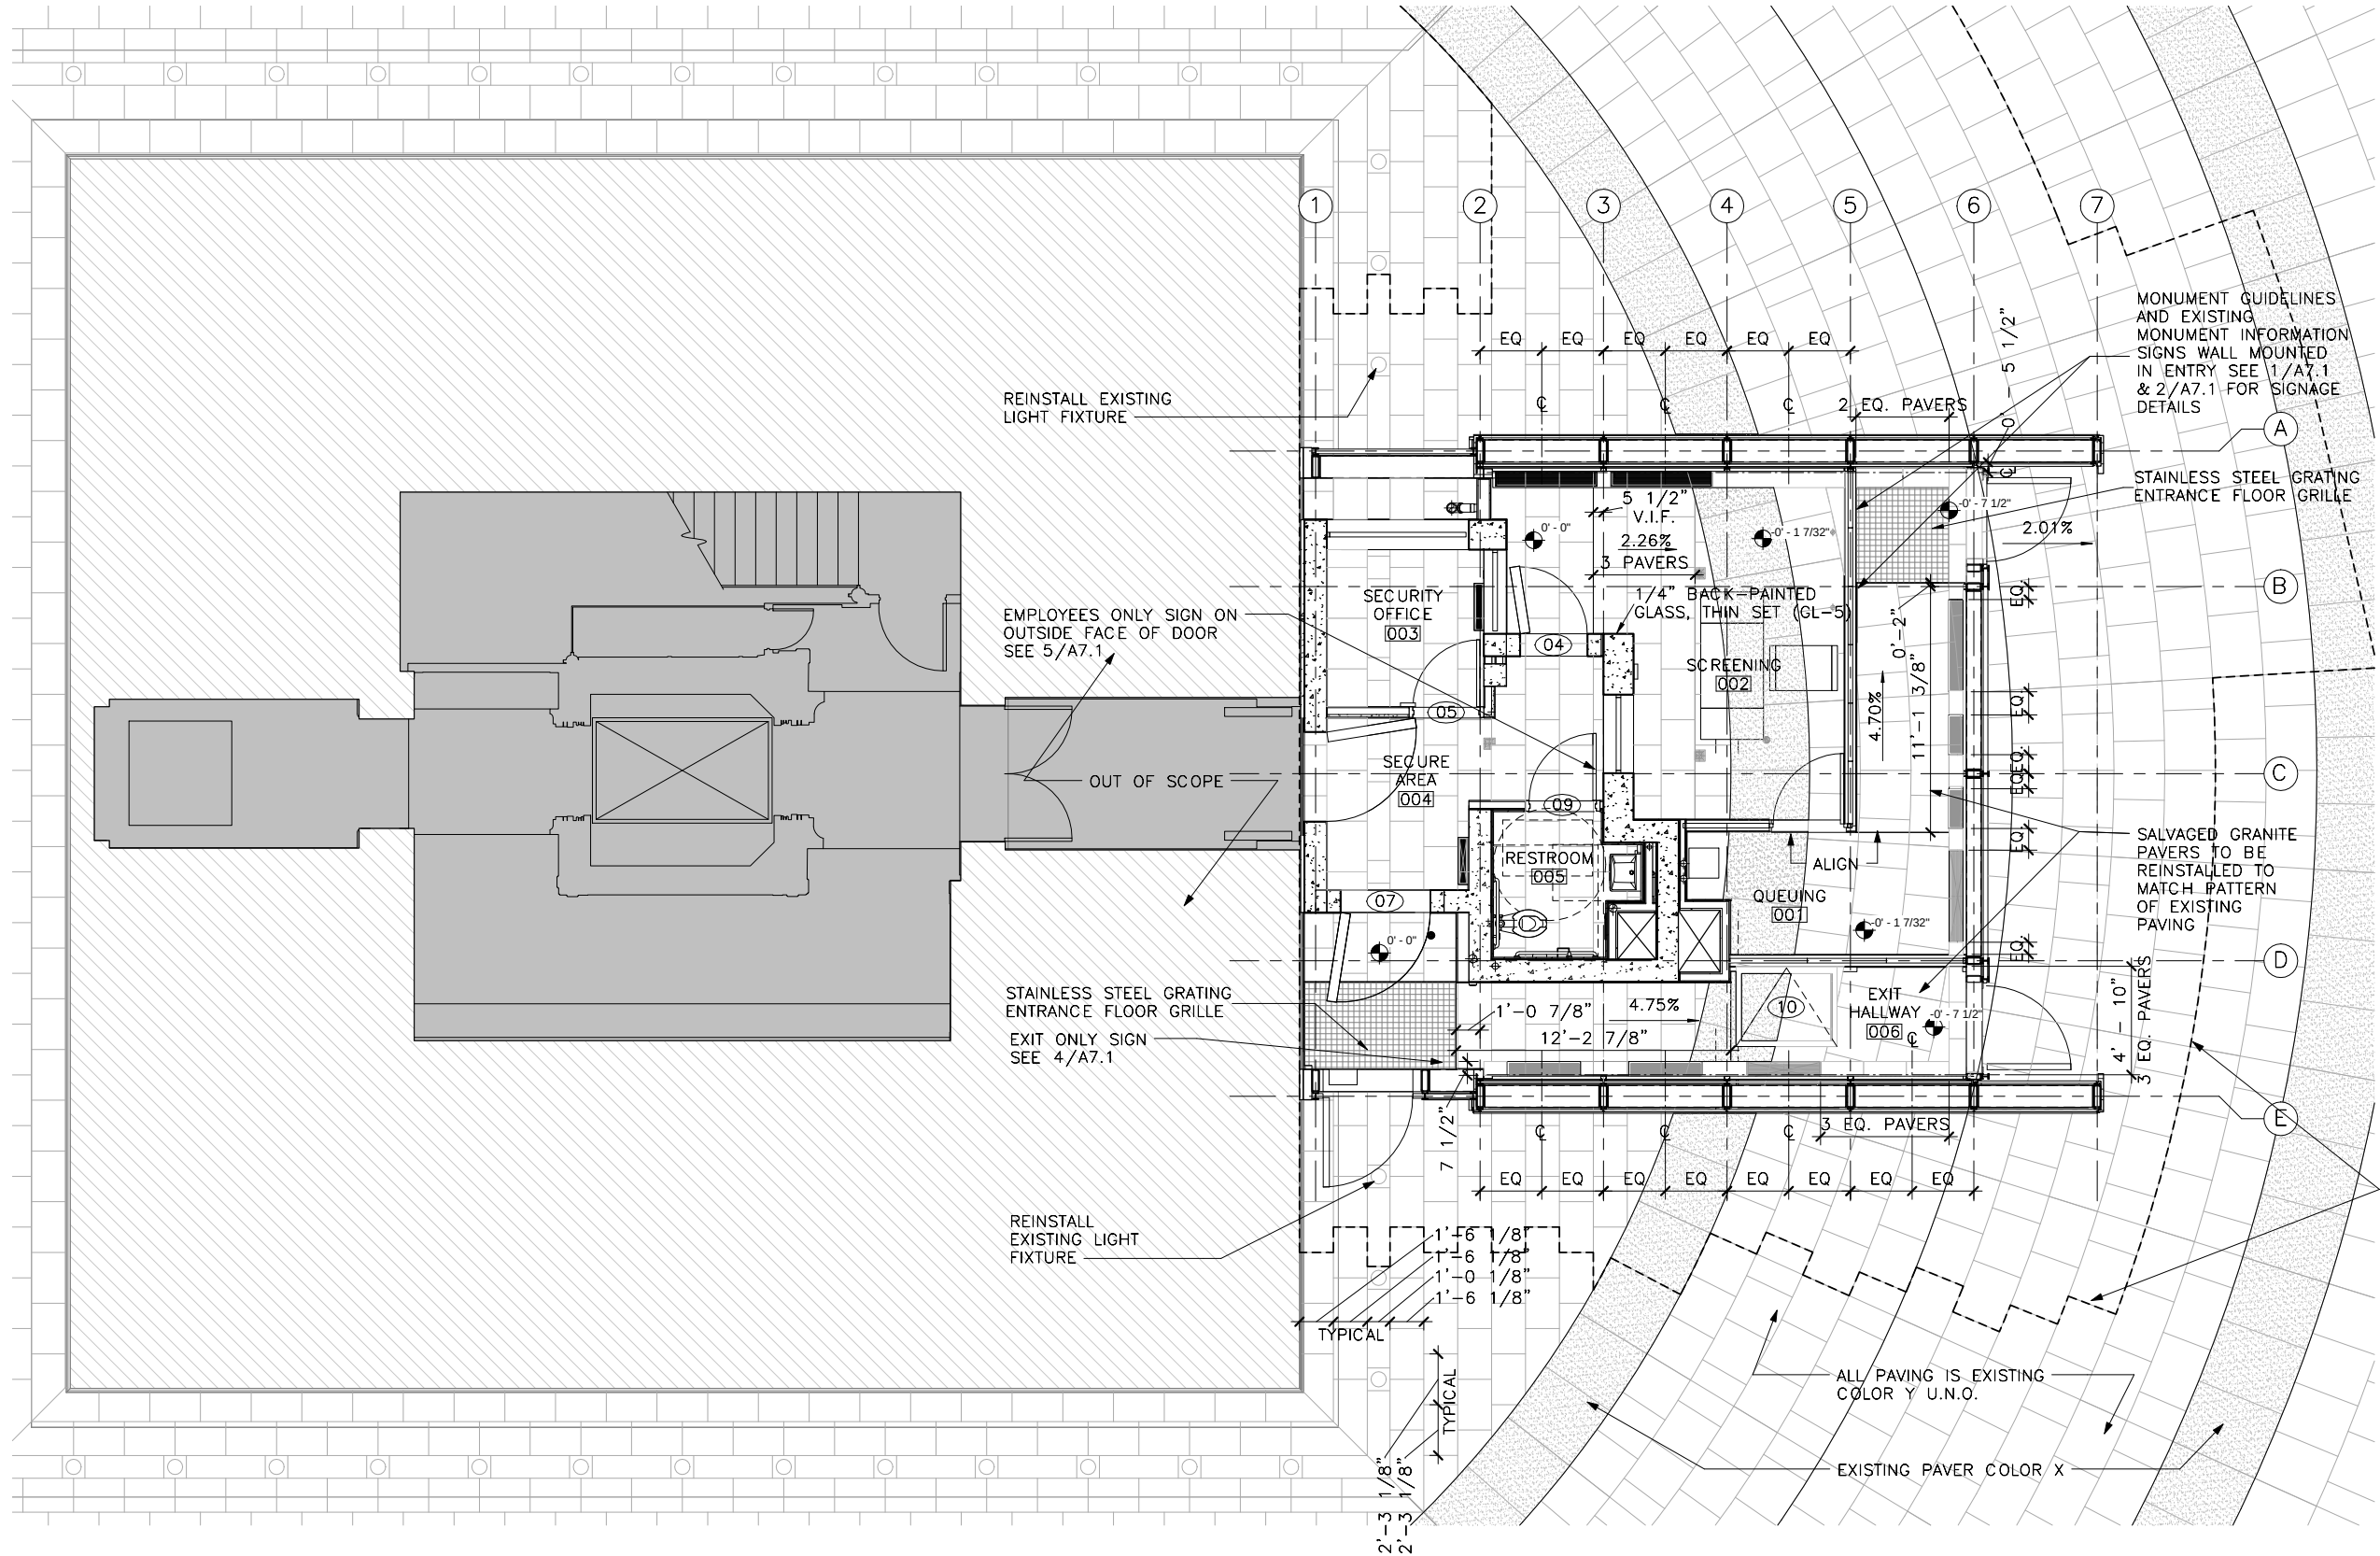

GENERAL NOTES:

1. STONE FLOOR PAVING TO BE SALVAGED FROM EXISTING & RELAIID TO MATCH EXISTING. NEW STONE MATERIAL MUST MATCH EXISTING.
2. ALL EXPOSED GWB & CONCRETE WALLS AND CEILINGS TO BE PAINTED PT-01 UNLESS OTHERWISE NOTED
3. ALL DOORS TO BE PAINTED UNLESS OTHERWISE NOTED
4. ALL BASE TRIM TO BE MT-01 UNLESS OTHERWISE NOTED
5. ALL FLOOR DIFFUSERS TO BE SATIN FINISH STAINLESS STEEL TYP. UNLESS OTHERWISE NOTED
6. ALL FLOOR DIFFUSERS TO BE INSTALLED FLUSH WITH FINISH FLOOR (INCLUDING AT SLOPED AREAS) UNLESS OTHERWISE NOTED
7. ALL INTERIOR EXPOSED CAST IN PLACE CONCRETE WALLS AND CEILINGS TO RECEIVE SKIM COAT, U.O.N.
8. ALL INTERIOR EXPOSED STRUCTURAL STEEL TO BE PAINTED PT-02, U.O.N.



1 First Floor Finishes
A1.5 SCALE (A)

DESIGNED:	SUB SHEET NO.	TITLE OF SHEET	DRAWING NO.
BBB			807
SA			101713A
TECH. REVIEW:			PMIS/PKG NO.
LD			NAMA
DATE:			151073
12/30/2016			SHEET
			30 of 129


A1.5

FINISHES PLANS

100% DRAFT CONSTRUCTION DOCUMENTS
WASHINGTON MONUMENT
NATIONAL MALL AND MEMORIAL PARKS

12/30/2016 1:21:48 PM


1 Hyphen T.O.S.
A1.6 SCALE (A)

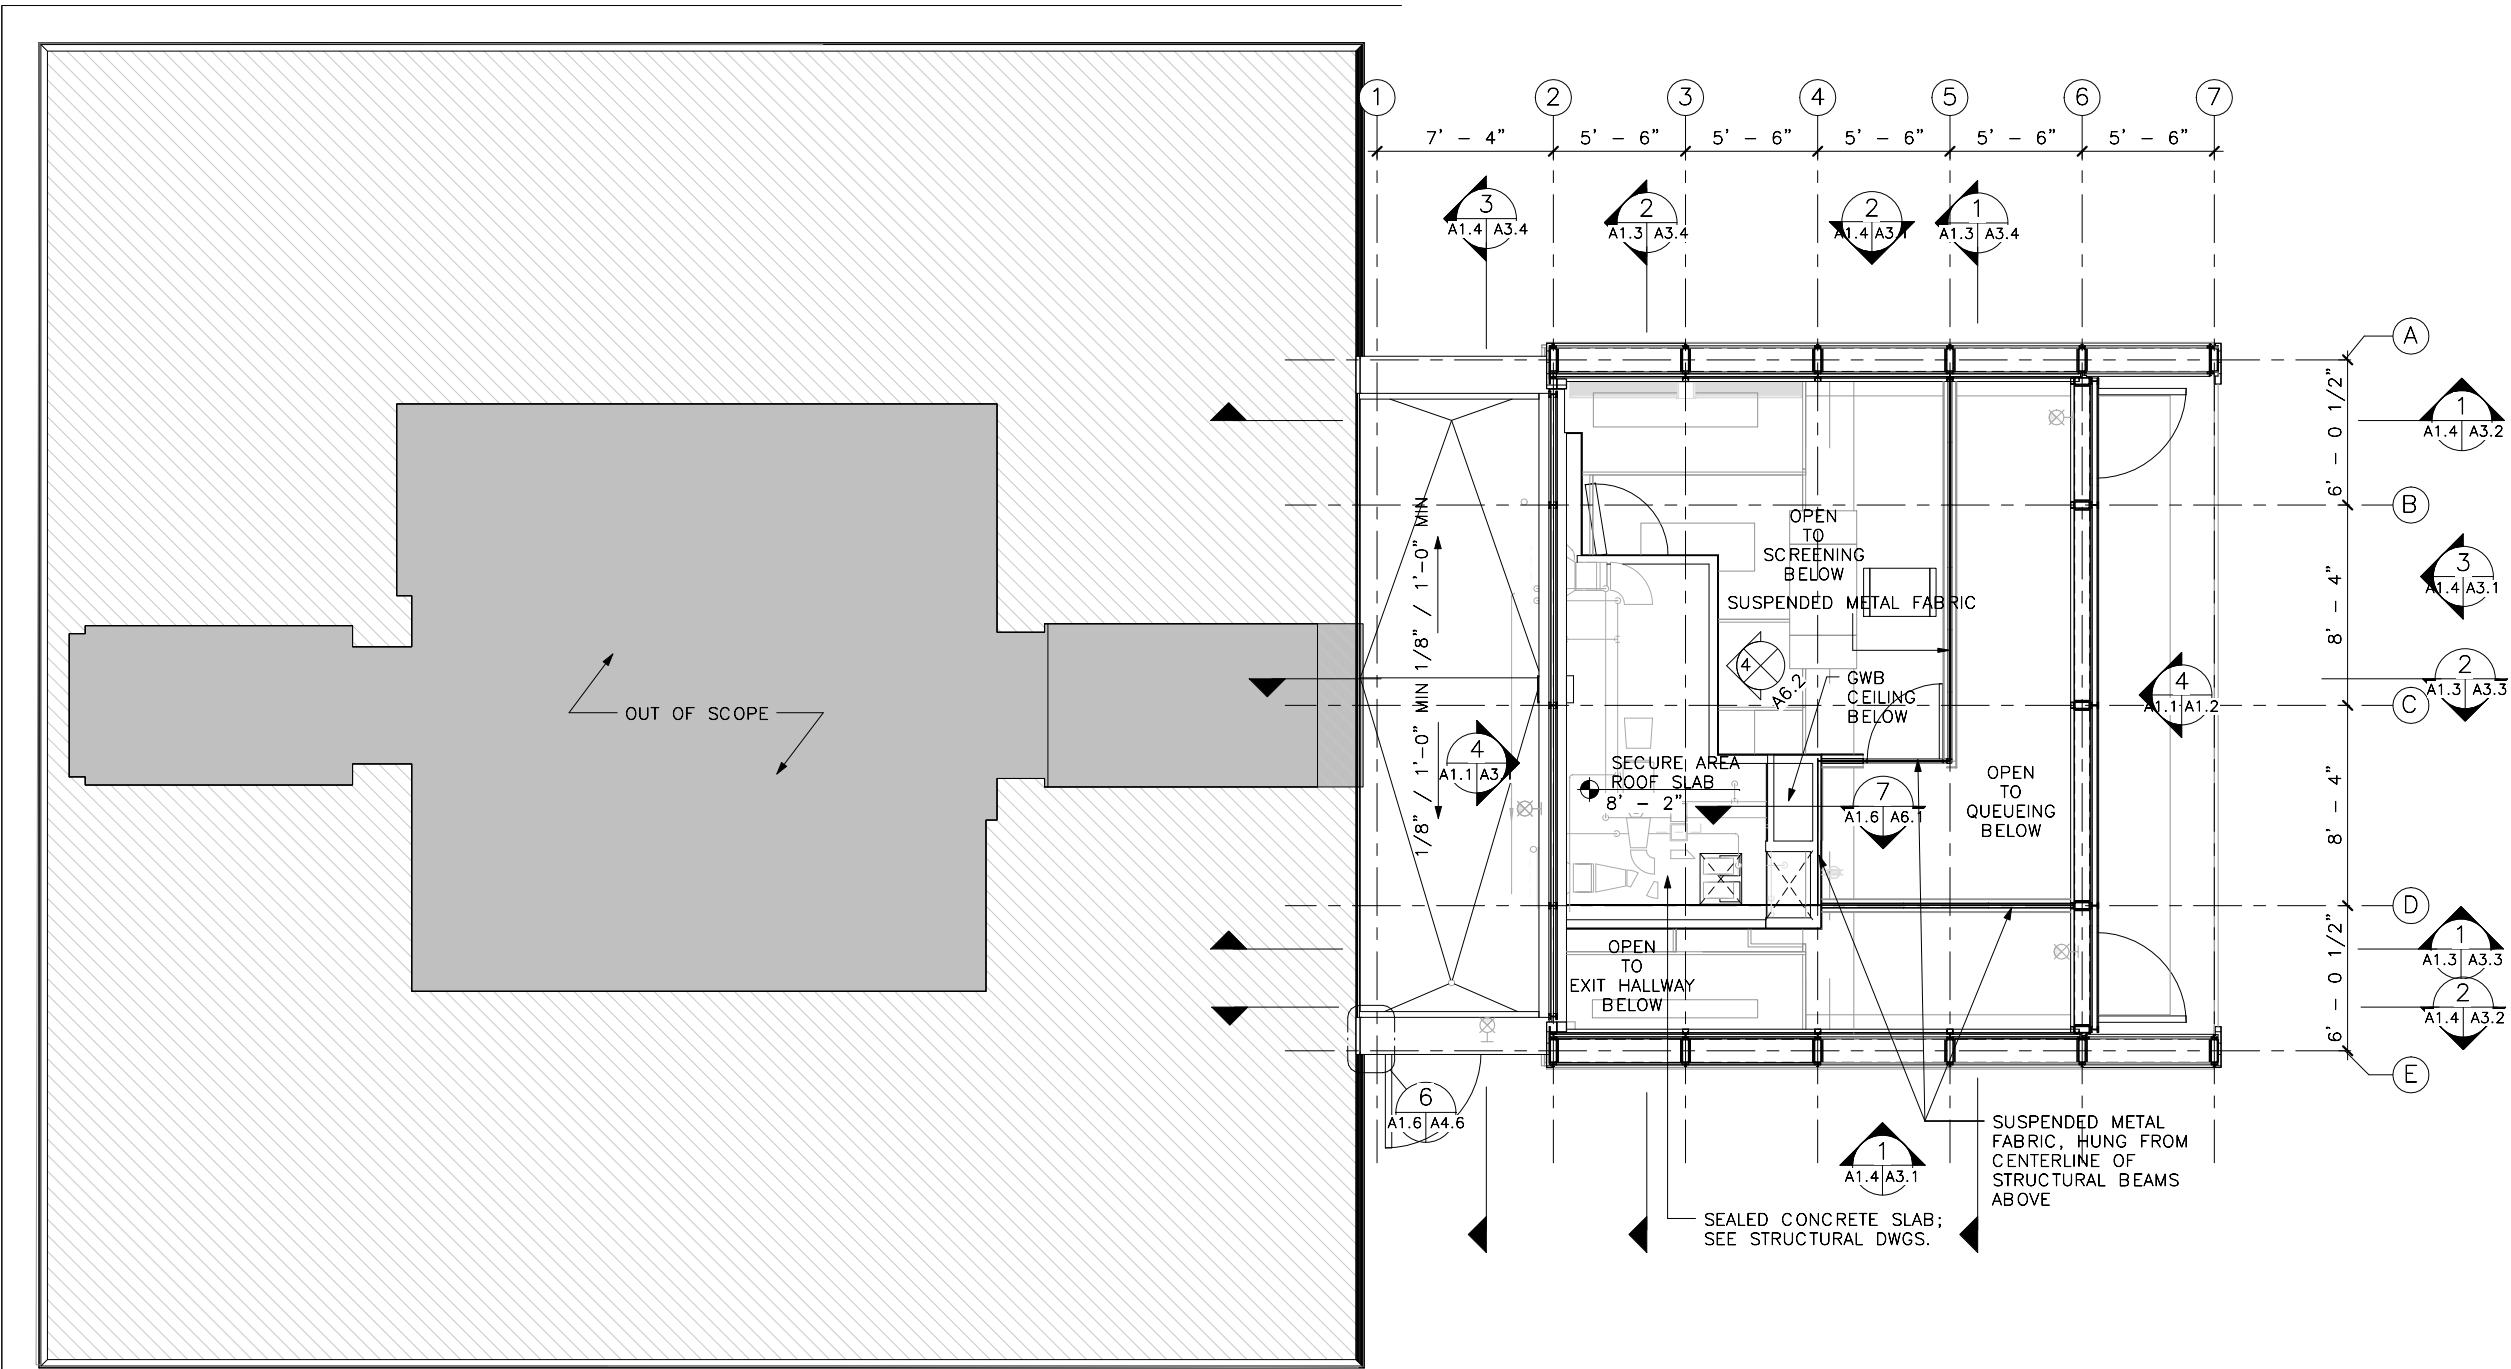


DESIGNED: LD SA TECH. REVIEW: LD DATE: 12/30/2016	SUB SHEET NO. A1.6	TITLE OF SHEET SECURE AREA ROOF PLAN 100% DRAFT CONSTRUCTION DOCUMENTS WASHINGTON MONUMENT NATIONAL MALL AND MEMORIAL PARKS	DRAWING NO. 807 101713A PMIS/PKG NO. NAMA 151073 SHEET 31 of 129
---	---------------------------	--	---

12/30/2016 1:21:49 PM


1 Roof
A1.7 SCALE (A)

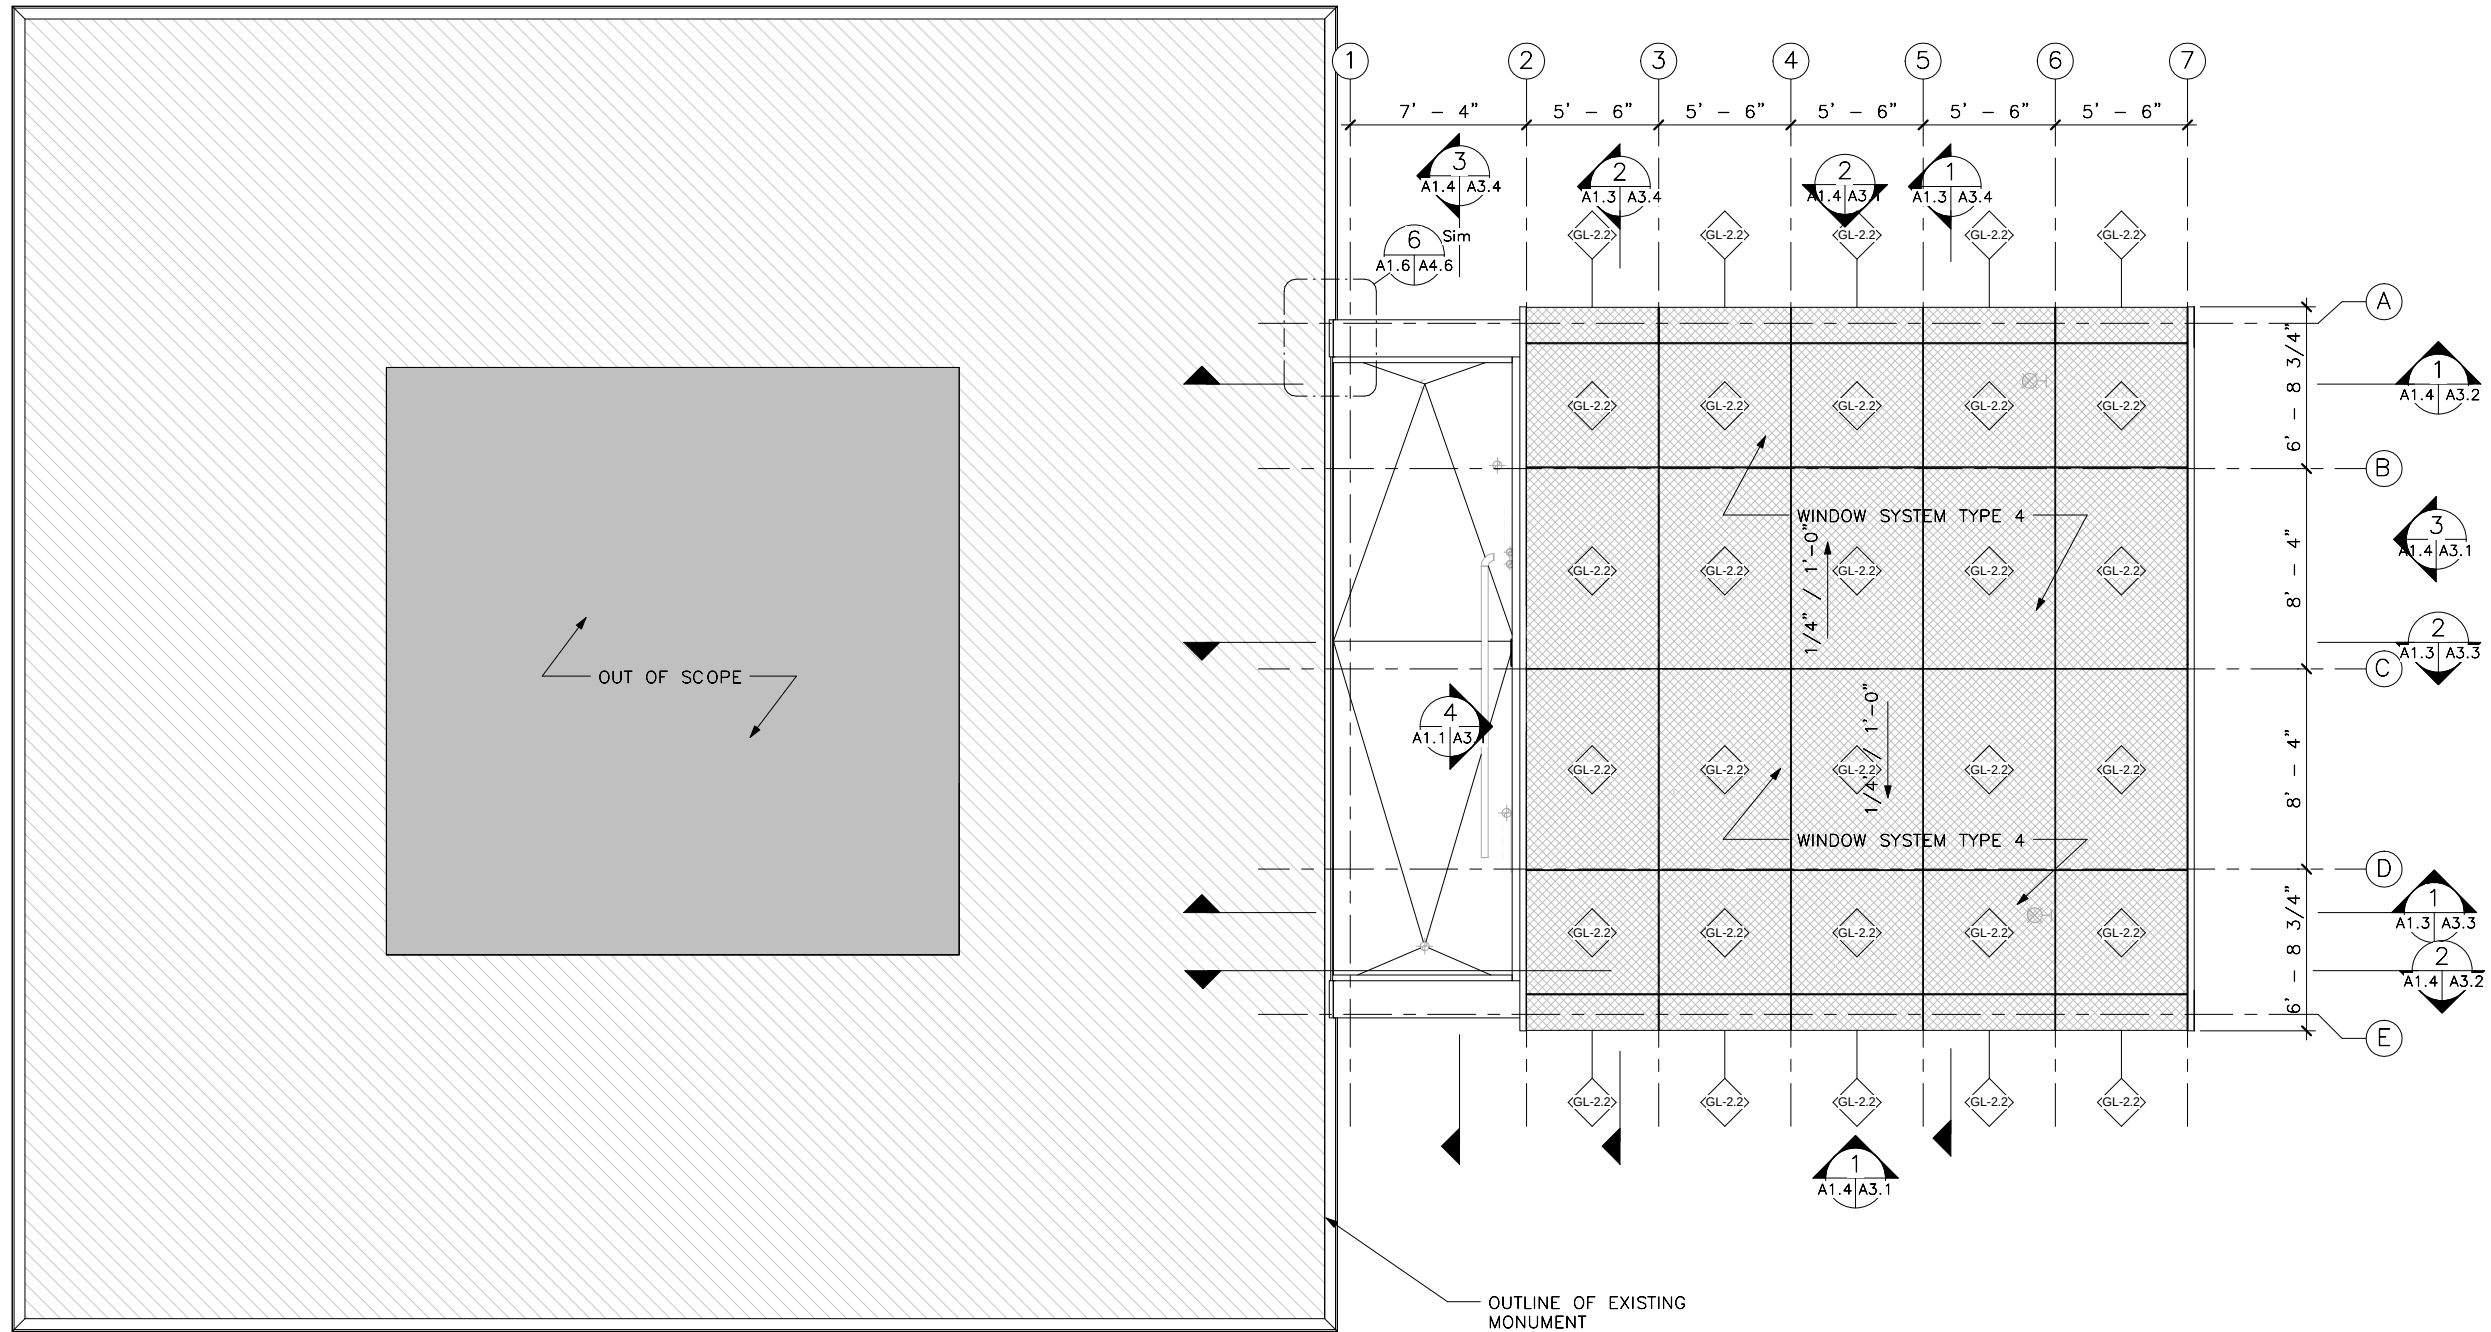


DESIGNED: LD @ADD SA TECH. REVIEW: LD DATE: 12/30/2016	SUB SHEET NO. A1.7	TITLE OF SHEET ROOF PLAN 100% DRAFT CONSTRUCTION DOCUMENTS WASHINGTON MONUMENT NATIONAL MALL AND MEMORIAL PARKS	DRAWING NO. 807 101713A PMIS/PKG NO. NAMA 151073 SHEET 32 of 129
---	---------------------------	---	---

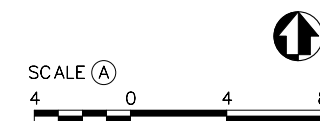


DESIGNED: LD	SUB SHEET NO. A2.1	TITLE OF SHEET REFLECTED CEILING PLAN 100% DRAFT CONSTRUCTION DOCUMENTS WASHINGTON MONUMENT NATIONAL MALL AND MEMORIAL PARKS	DRAWING NO. 807
SA			101713A
TECH. REVIEW: LD			PMIS/PKG NO. NAMA 151073
DATE: 12/30/2016			SHEET 33 of 129

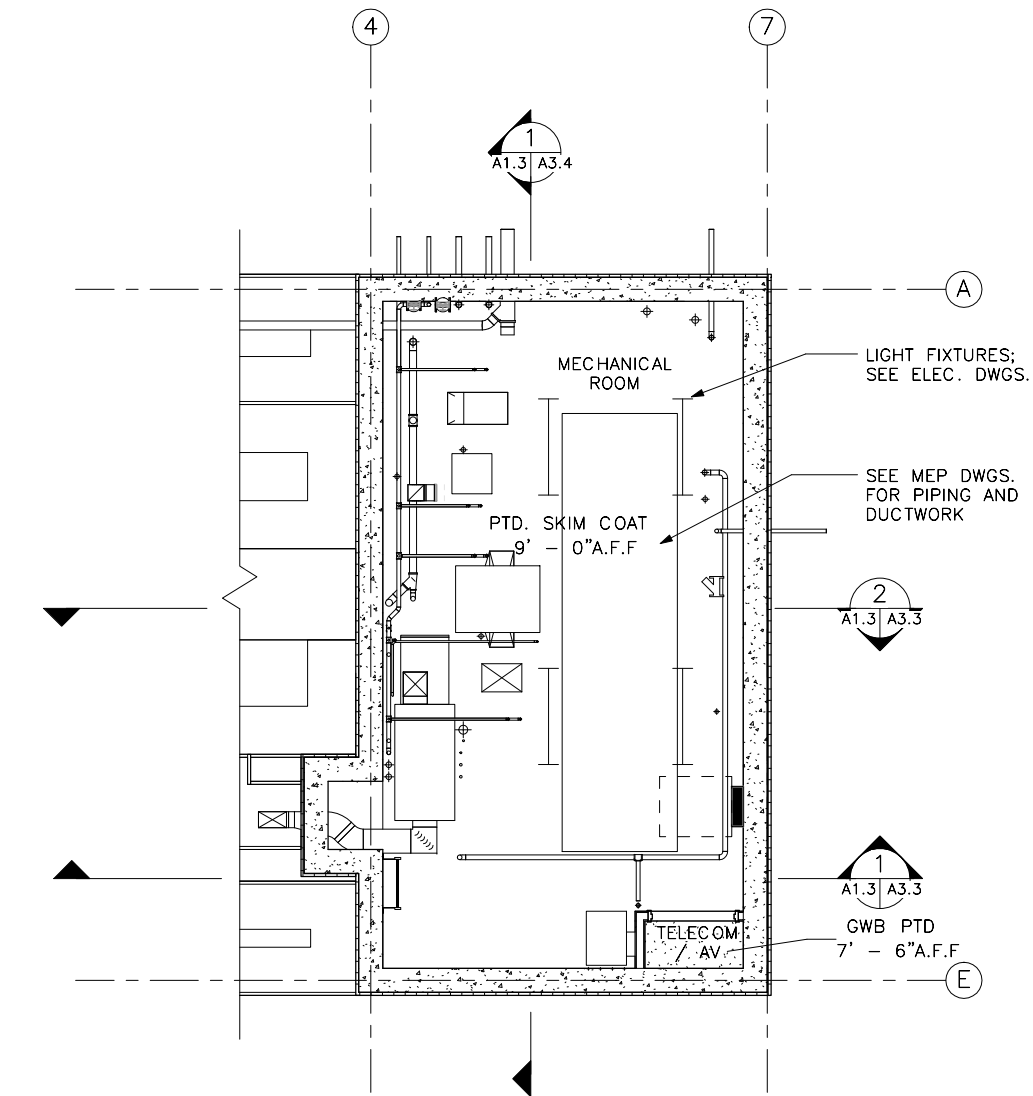


1 Lower Level
SCALE (A)

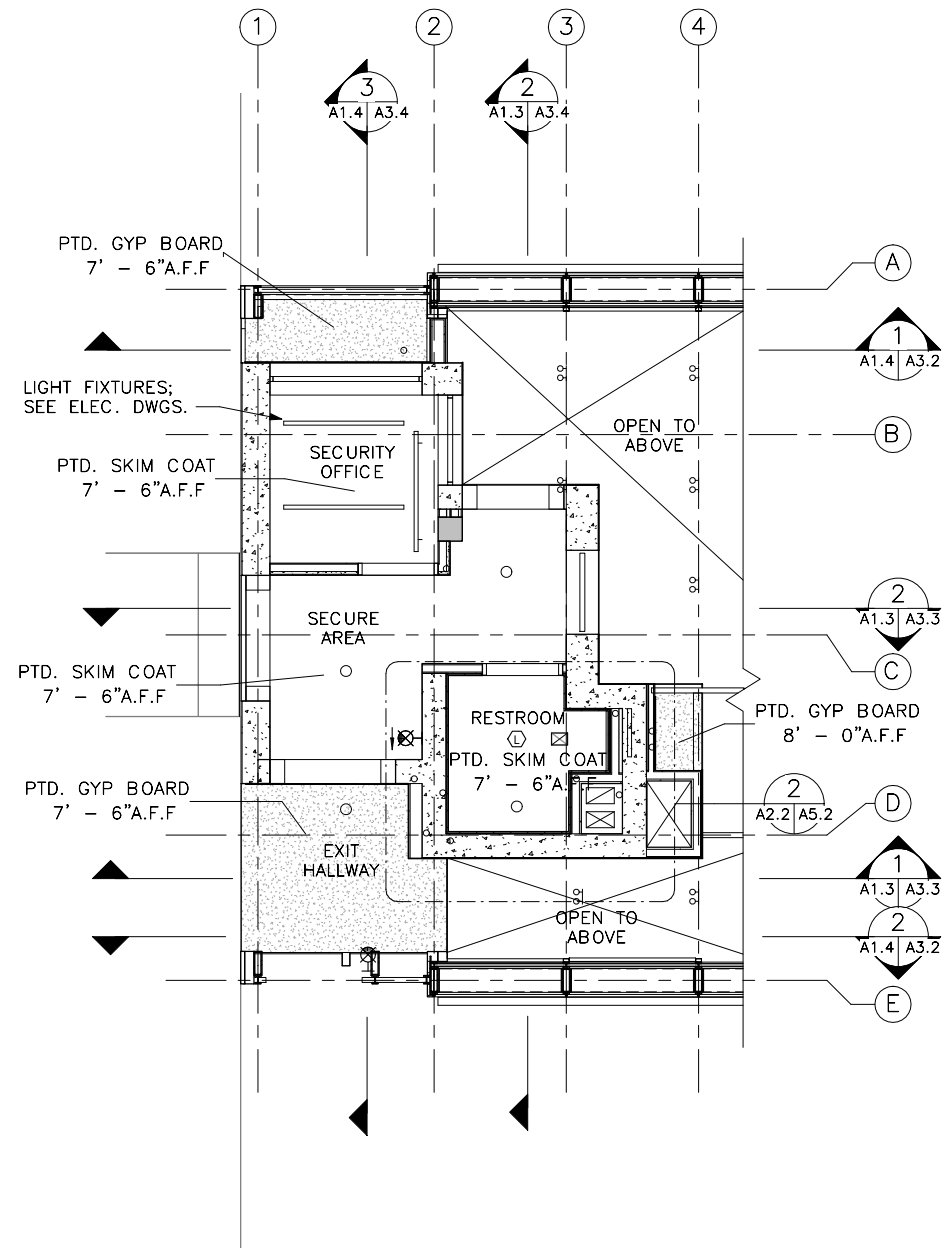


2 Low Roof
SCALE (A)

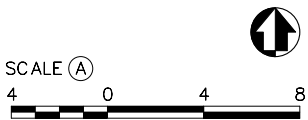


DESIGNED: LD SA TECH. REVIEW: LD DATE: 12/30/2016	SUB SHEET NO. A2.2	TITLE OF SHEET REFLECTED CEILING PLANS 100% DRAFT CONSTRUCTION DOCUMENTS WASHINGTON MONUMENT NATIONAL MALL AND MEMORIAL PARKS	DRAWING NO. 807 101713A PMIS/PKG NO. NAMA 151073 SHEET 34 of 129
---	---------------------------	--	---

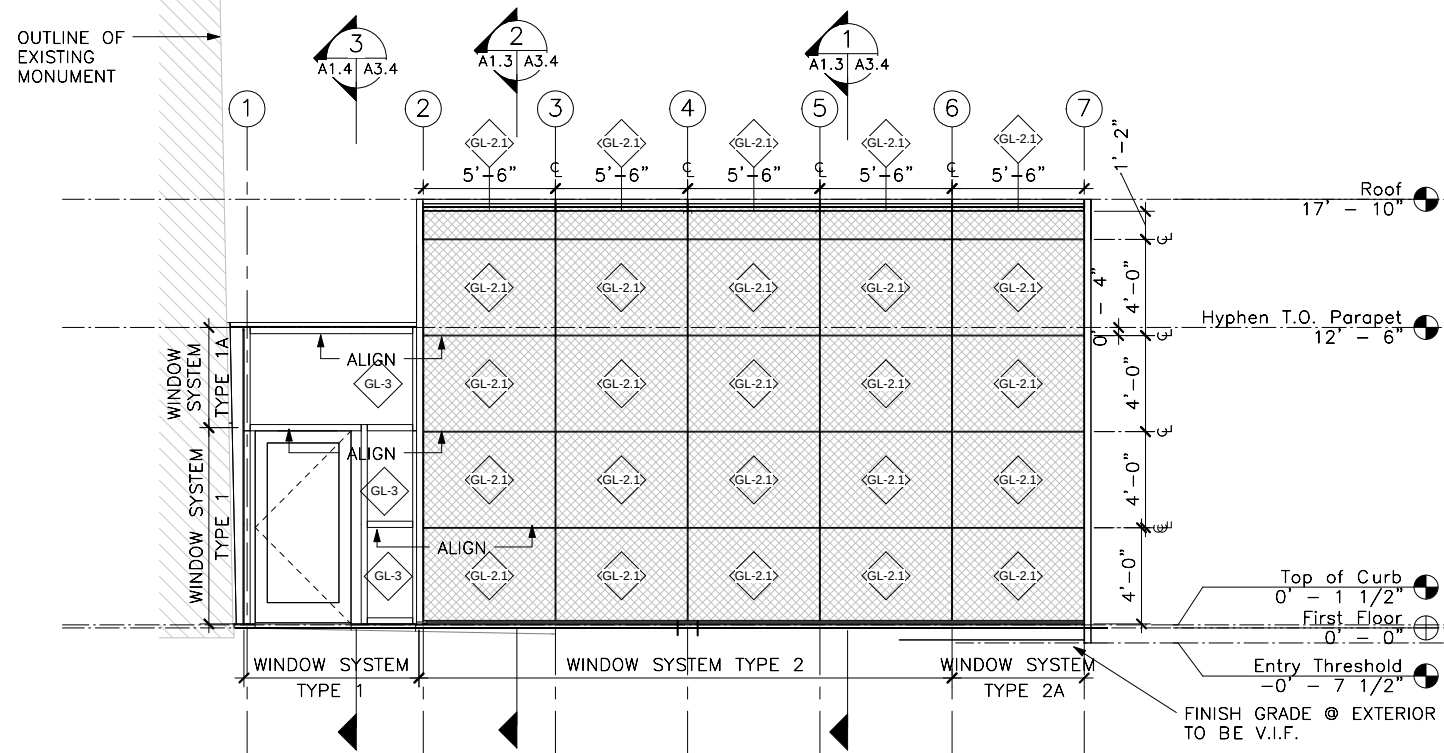


1 South
A3.1
SCALE (A)

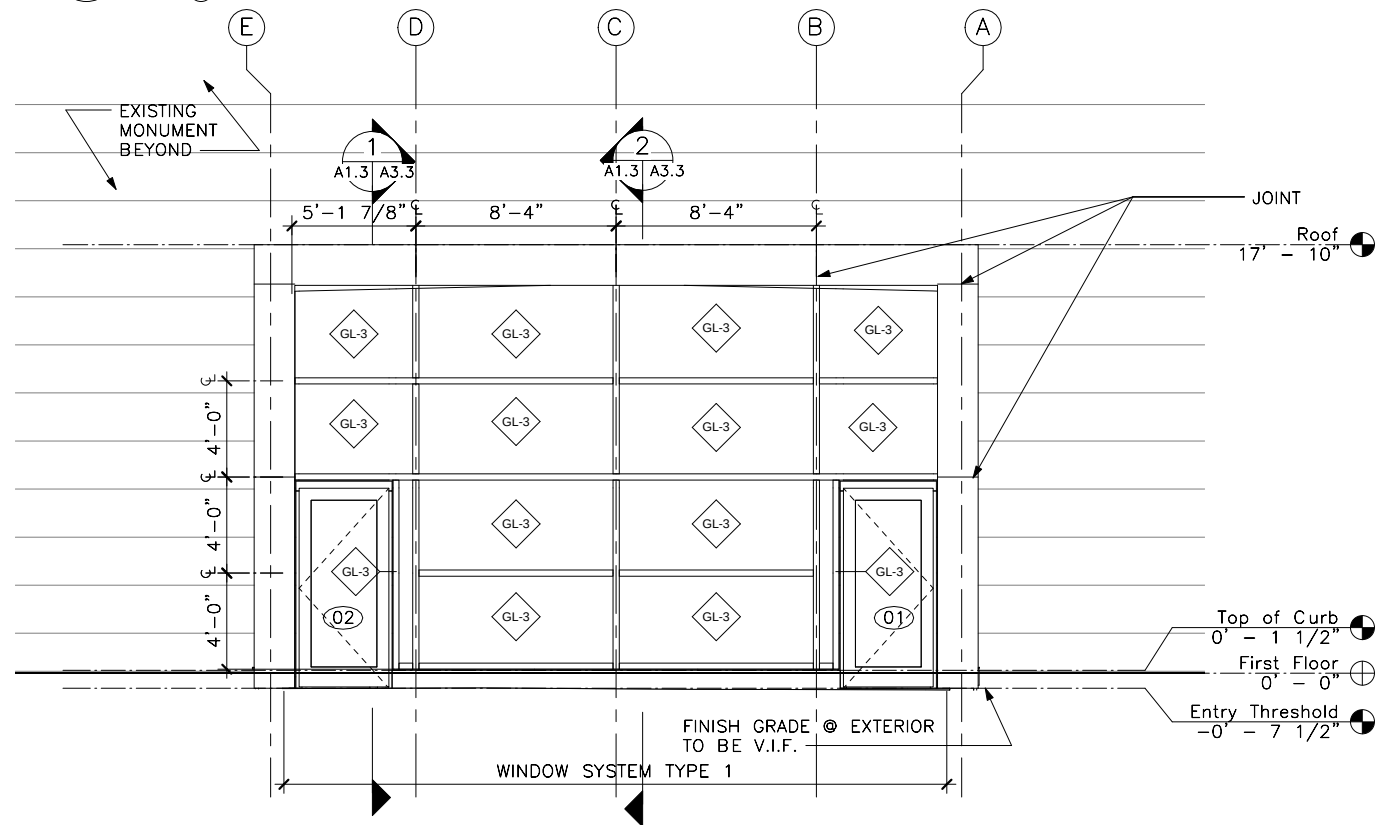

3 East
A3.1
SCALE (A)

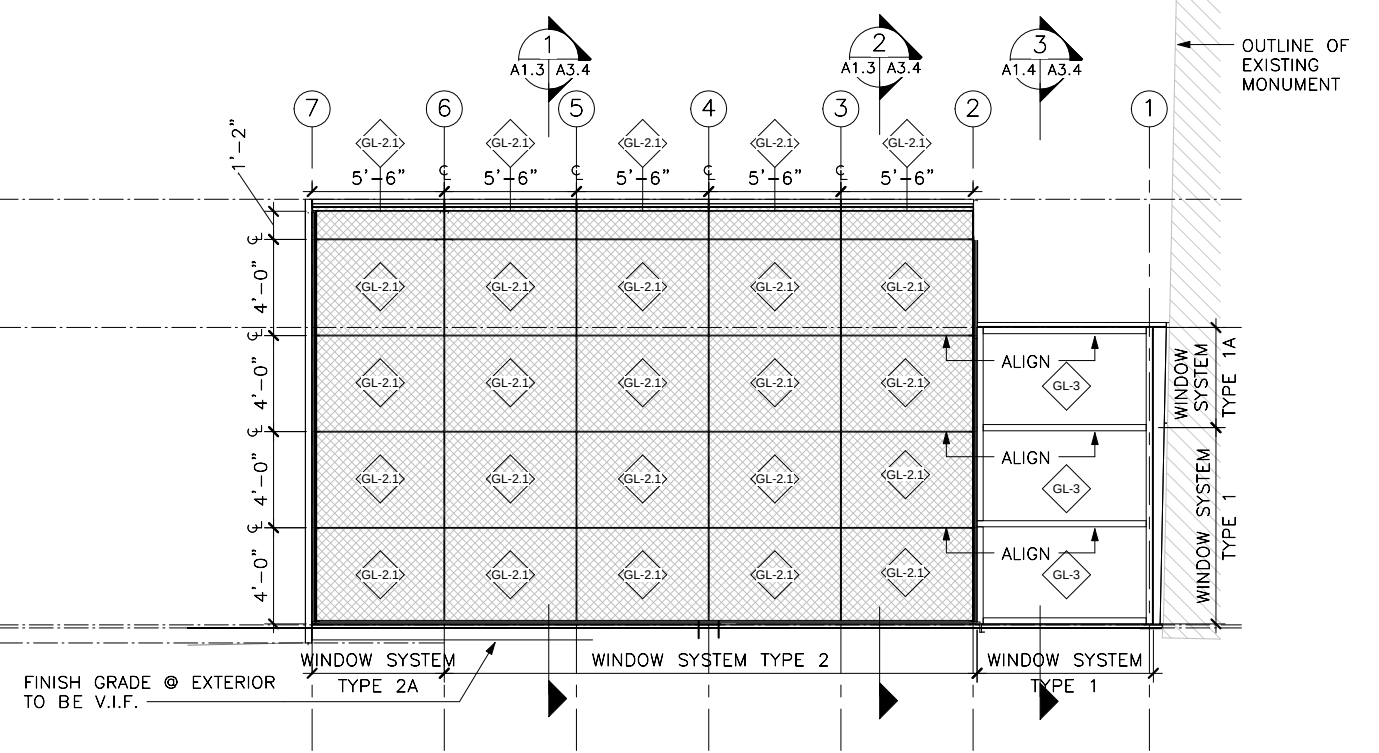


2 North
A3.1
SCALE (A)

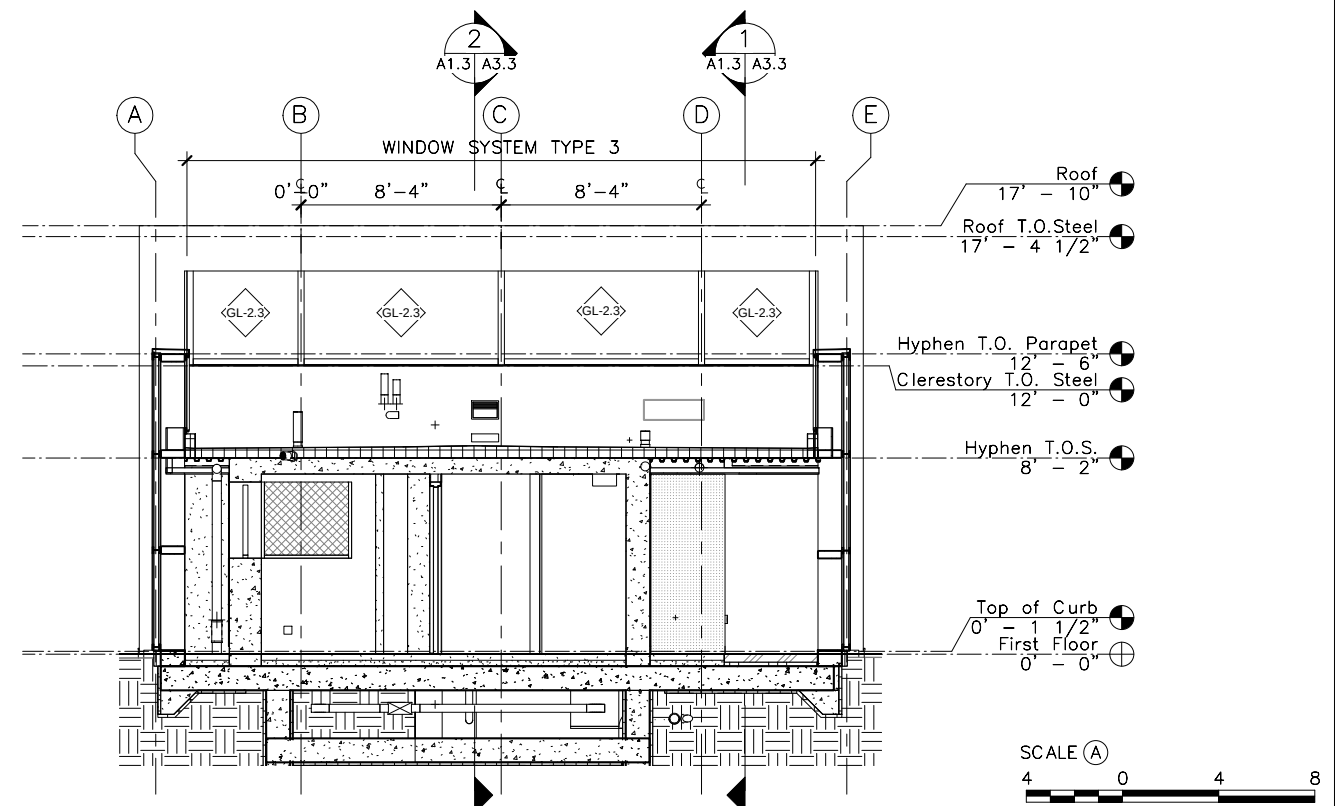


4 West
A3.1
SCALE (A)


DESIGNED: LD	SUB SHEET NO. A3.1	TITLE OF SHEET BUILDING ELEVATIONS	DRAWING NO. 807 101713A
SA			PMIS/PKG NO. NAMA 151073
TECH. REVIEW: LD			SHEET
DATE: 12/30/2016		100% DRAFT CONSTRUCTION DOCUMENTS WASHINGTON MONUMENT NATIONAL MALL AND MEMORIAL PARKS	35 of 129

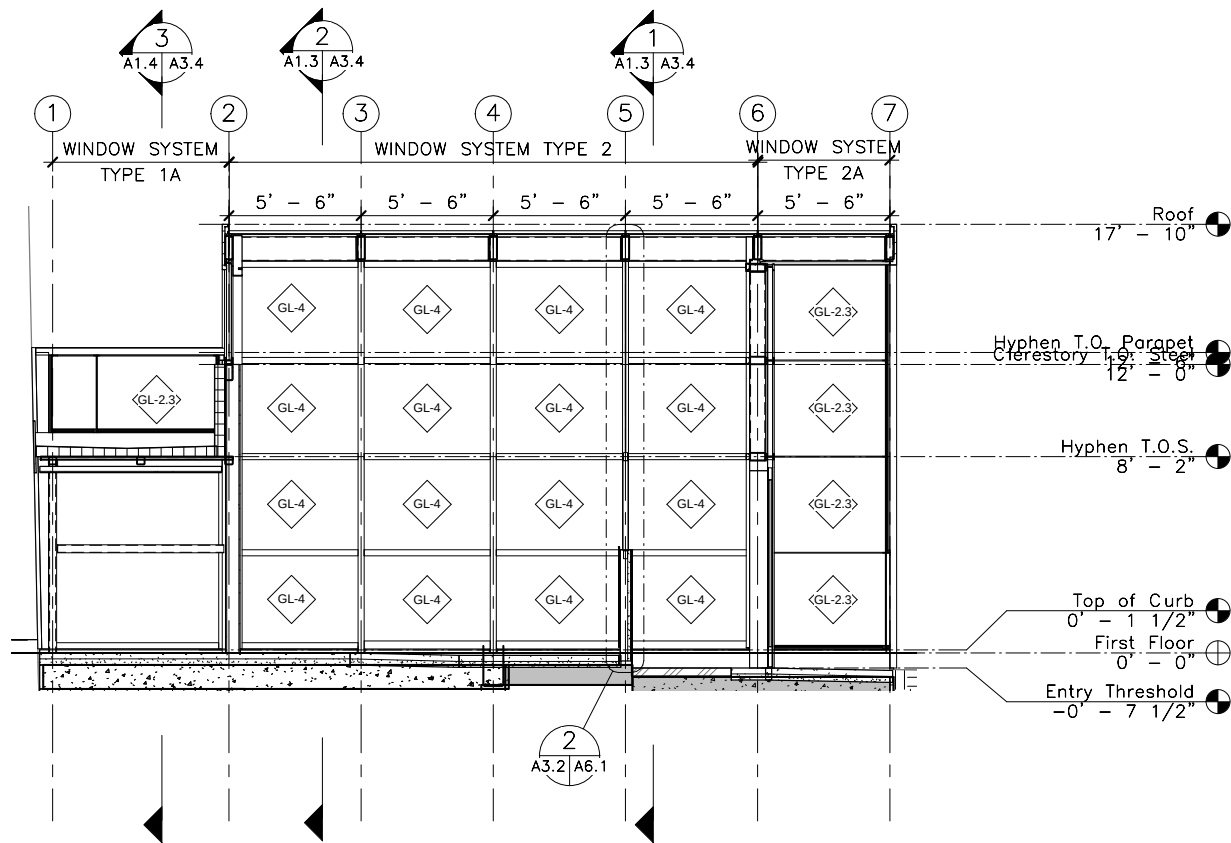


Window Types Inner
Layer North
1
A3.2
SCALE (A)

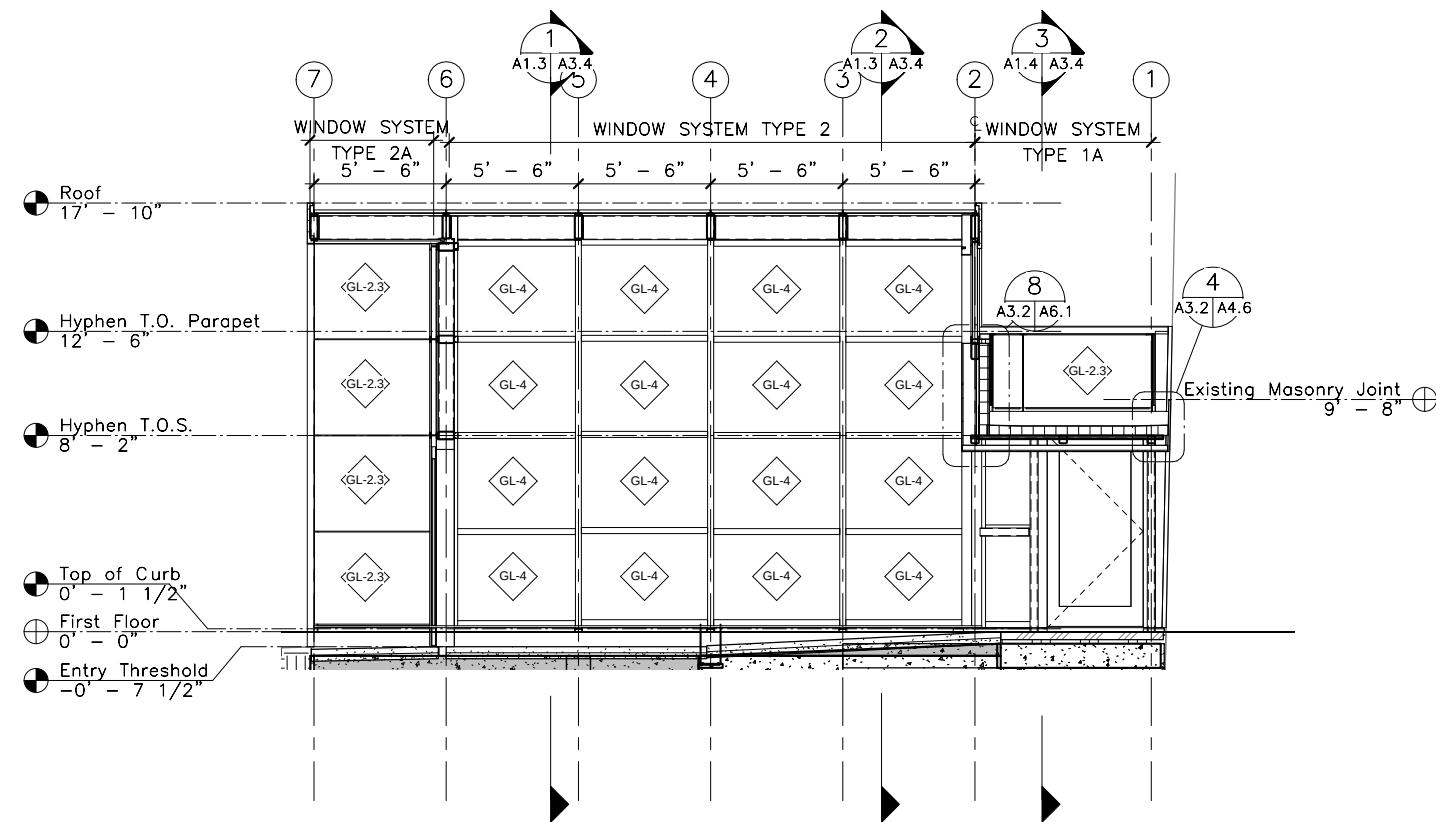

 
Window Types Inner
Layer South
2
A3.2
SCALE (A)



DESIGNED: LD	SUB SHEET NO. A3.2	TITLE OF SHEET BUILDING SECTIONS/ ELEVATIONS 100% DRAFT CONSTRUCTION DOCUMENTS WASHINGTON MONUMENT NATIONAL MALL AND MEMORIAL PARKS	DRAWING NO. 807
SA			101713
TECH. REVIEW: LD			PMIS/PKG NO. NAMA 151073
DATE: 12/30/2016			SHEET
			36 OF 129

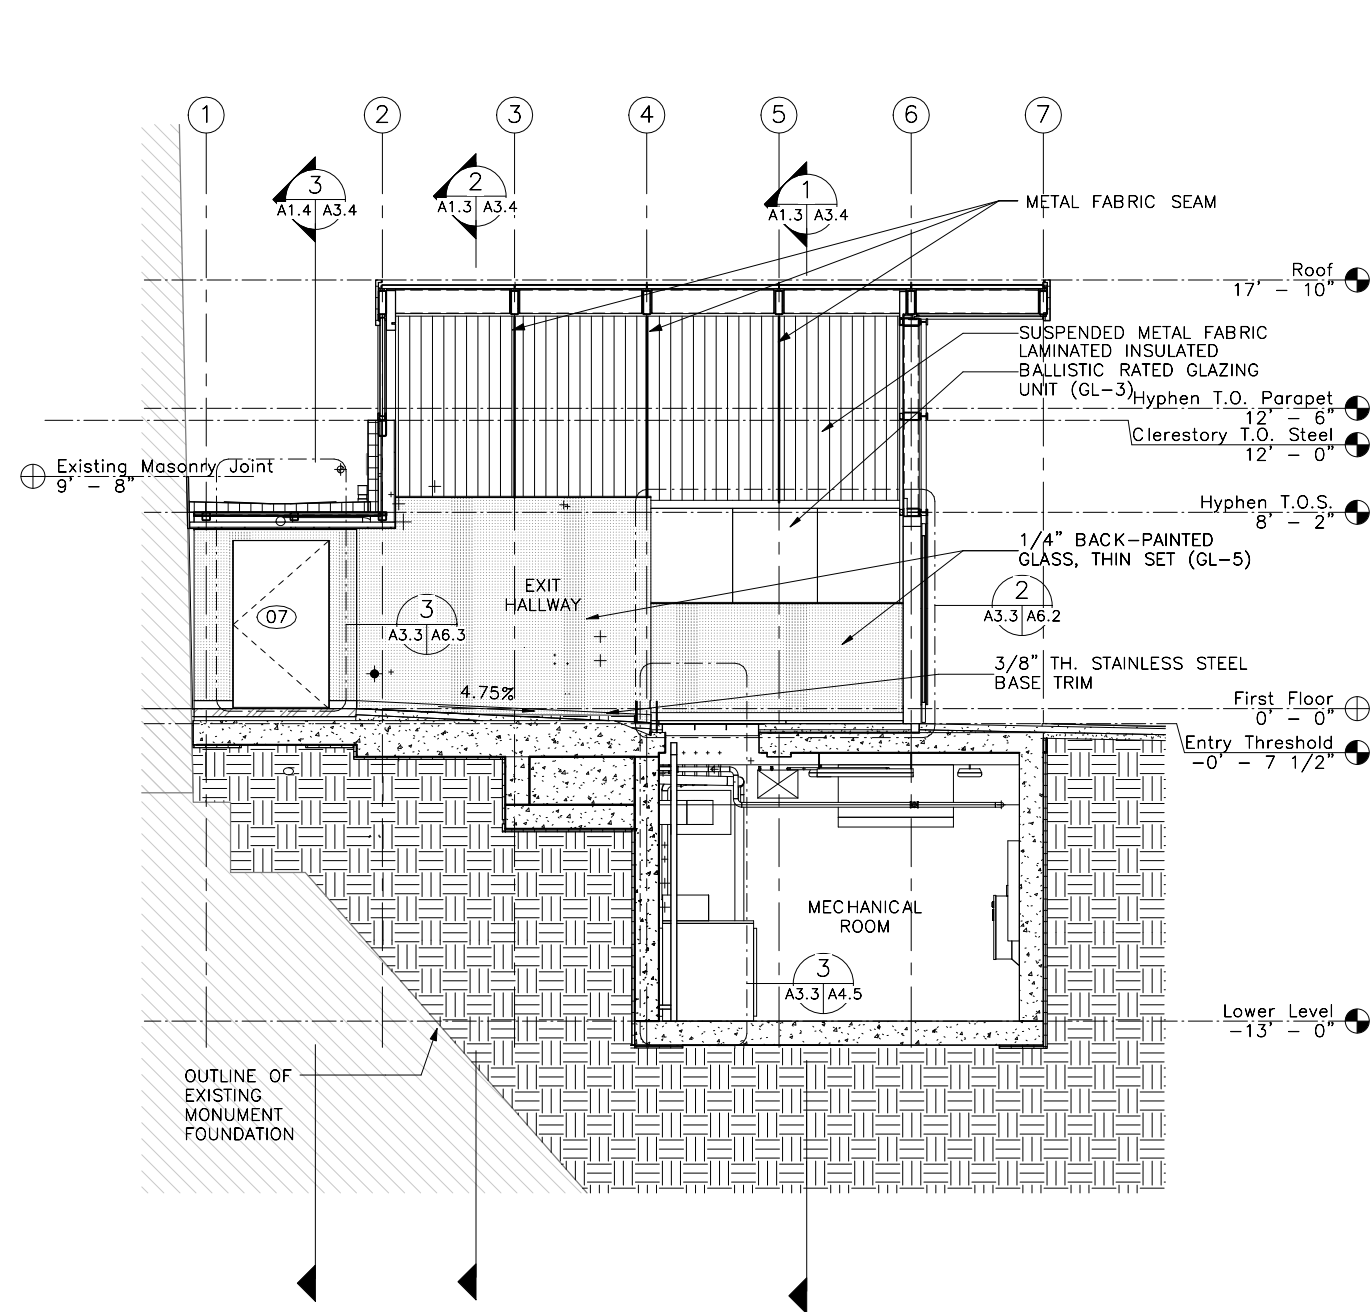

1 East-West Section 1
A3.3 SCALE (A)

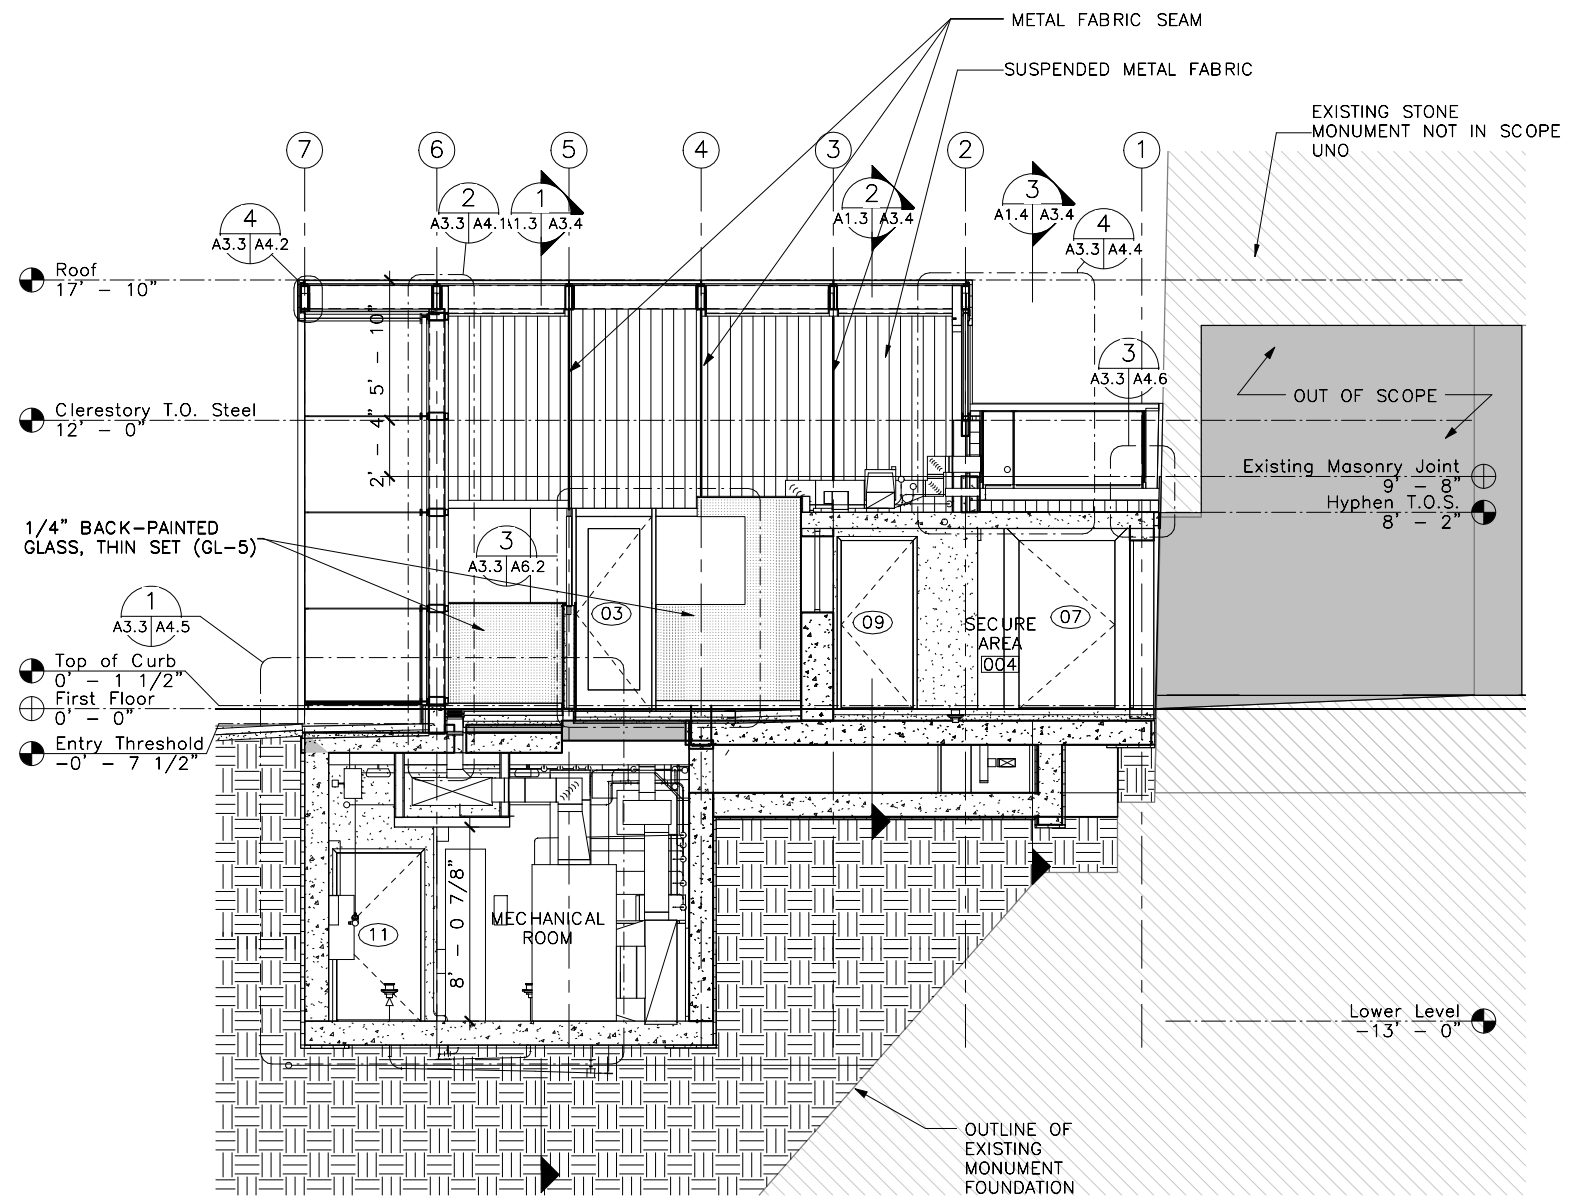

2 East-West Section 2
A3.3 SCALE (A)




DESIGNED:	SUB SHEET NO.	TITLE OF SHEET	DRAWING NO.
LD			807
SA			101713A
TECH. REVIEW:			PMIS/PKG NO.
LD			NAMA
DATE:			151073
12/30/2016			SHEET
			37 of 129


A3.3

BUILDING SECTIONS


100% DRAFT CONSTRUCTION DOCUMENTS
WASHINGTON MONUMENT
NATIONAL MALL AND MEMORIAL PARKS

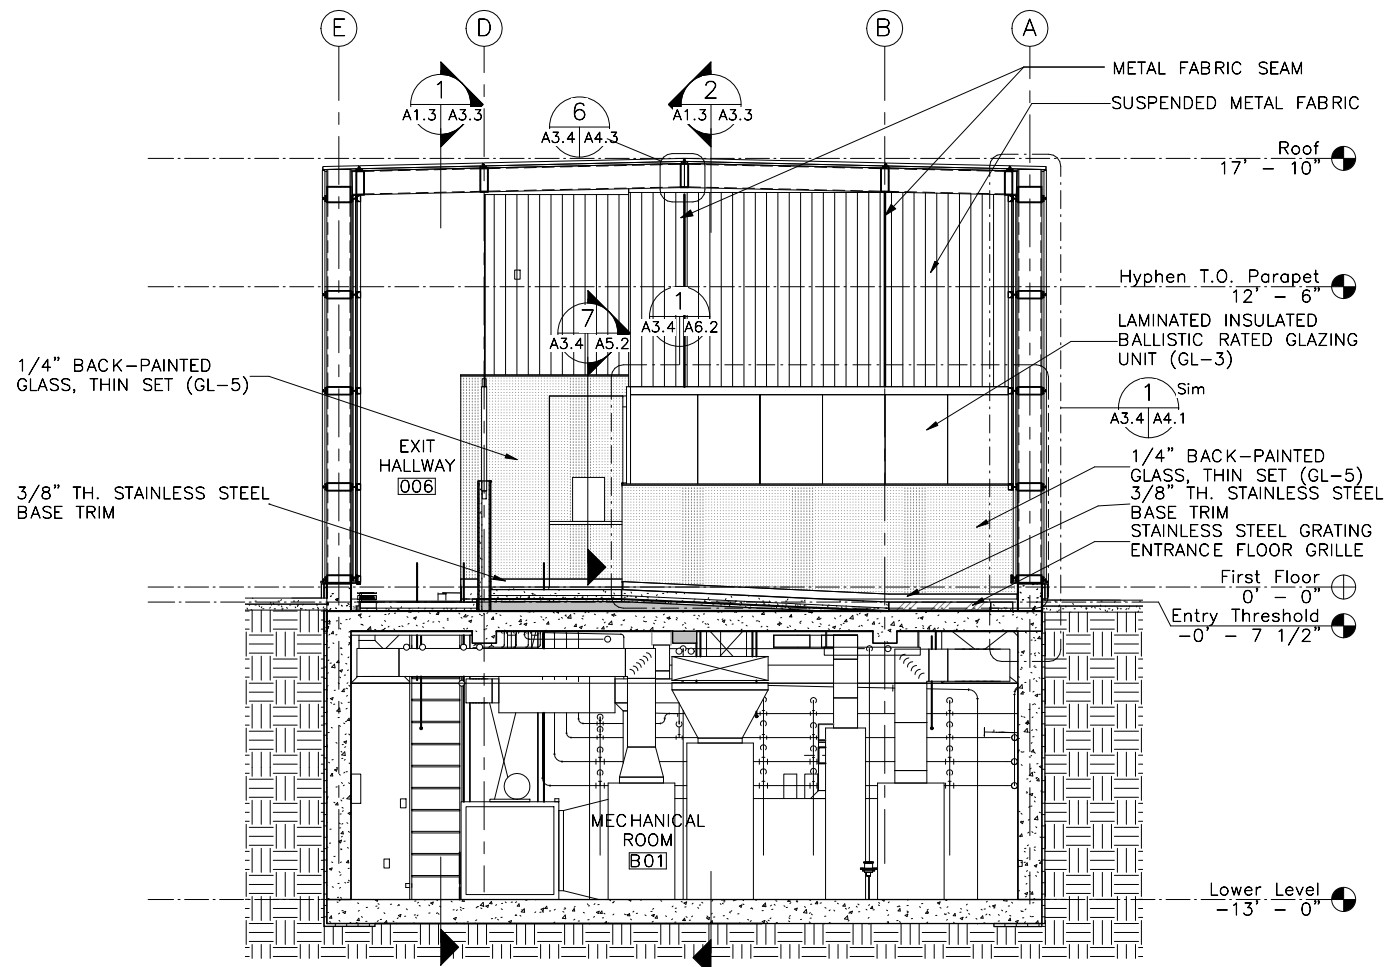


1
A3.4
North-South Section
Through Queueing
SCALE (A)

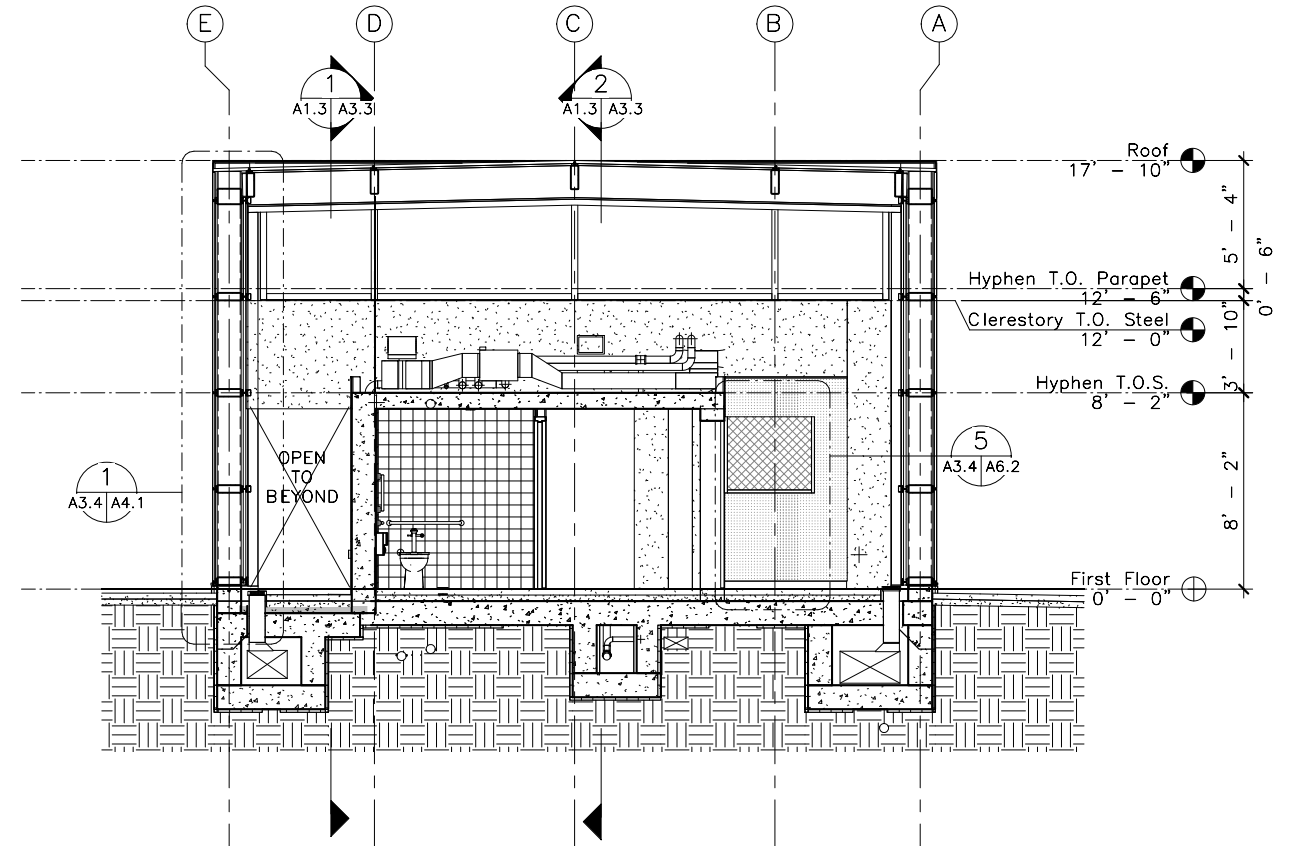

2
A3.4
North-South Section
Through Secure Area
SCALE (A)

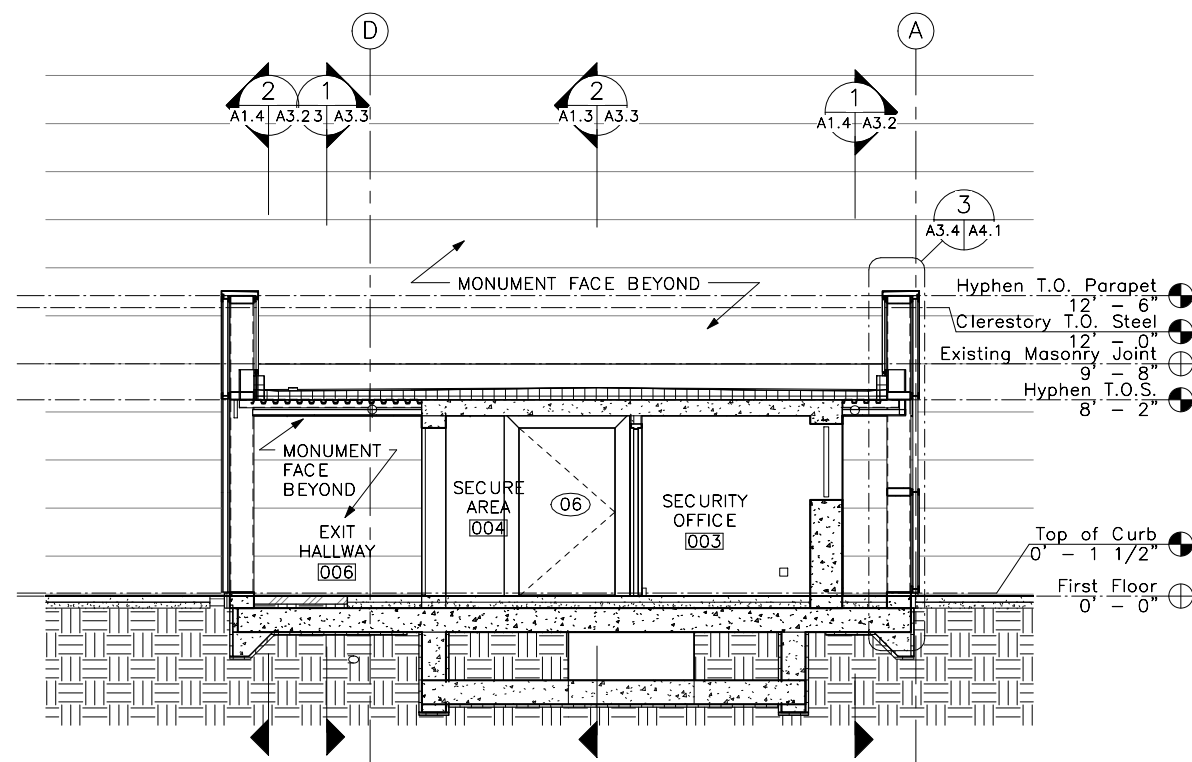




3
A3.4
North-South Section
Through Hyphen
SCALE (A)

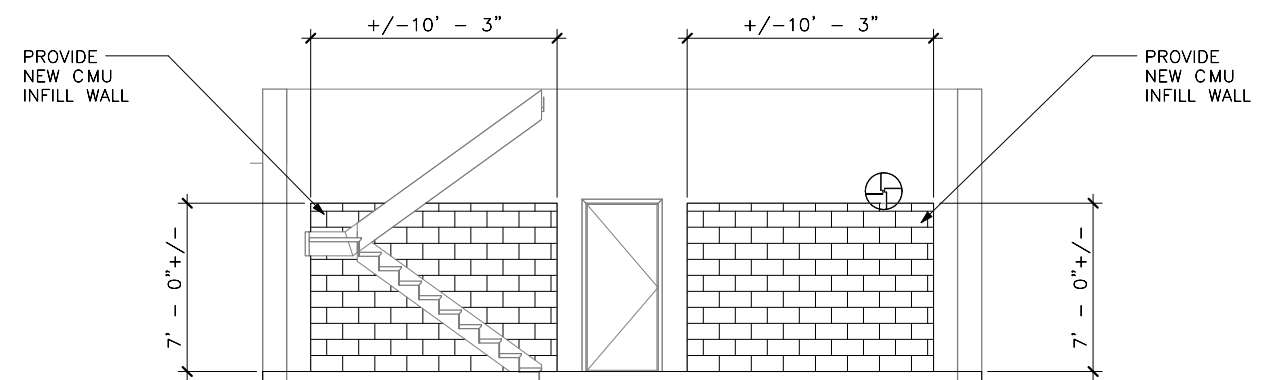


4
A3.4
Existing Bunker 2 -
East Elevation
SCALE (A)




DESIGNED: LD AD TECH. REVIEW: LD DATE: 12/30/2016	SUB SHEET NO. A3.4	TITLE OF SHEET BUILDING SECTIONS 100% DRAFT CONSTRUCTION DOCUMENTS WASHINGTON MONUMENT NATIONAL MALL AND MEMORIAL PARKS	DRAWING NO. 807 101713A PMIS/PKG NO. NAMA 151073 SHEET 38 of 129
---	---------------------------	---	---

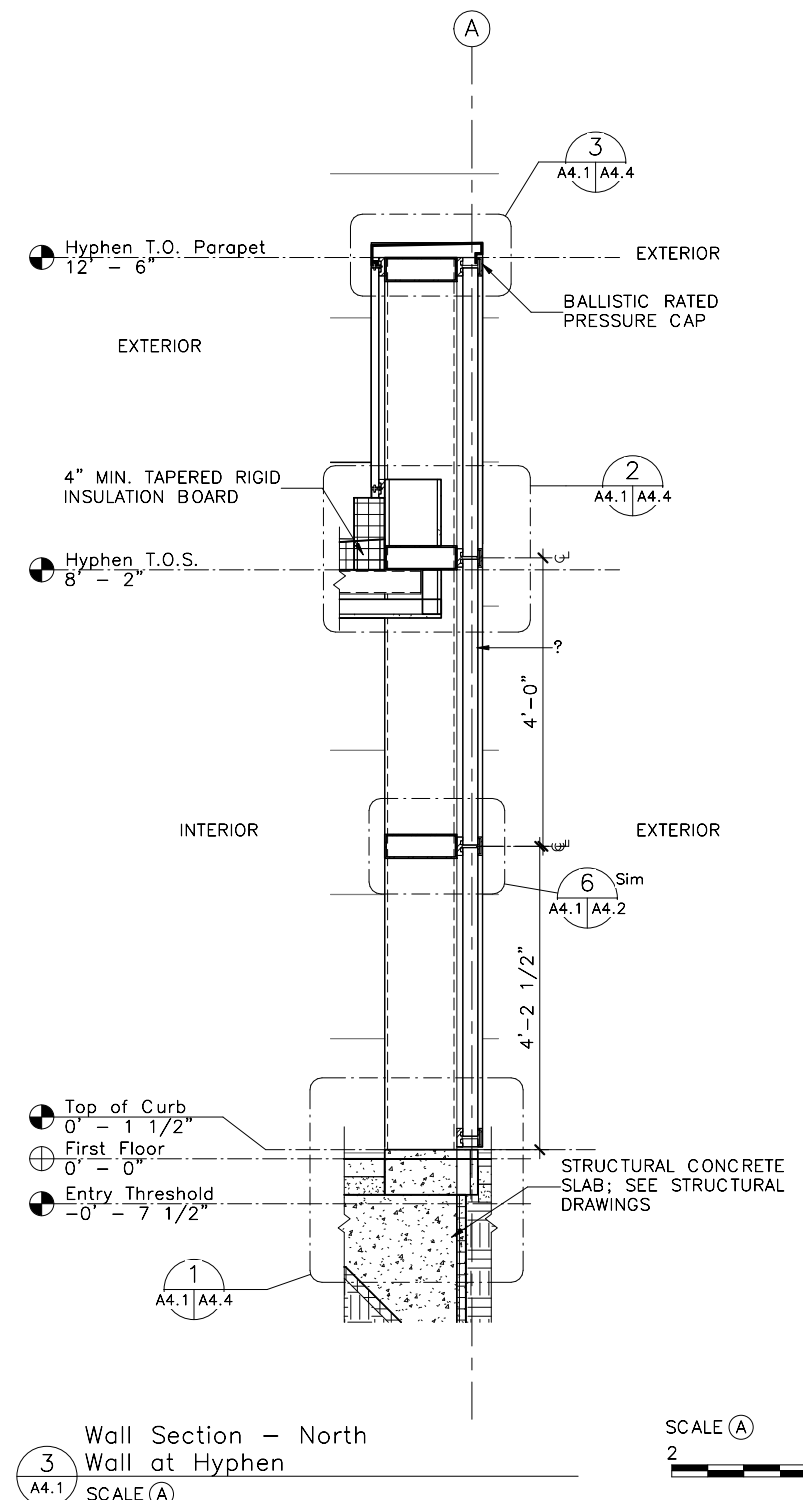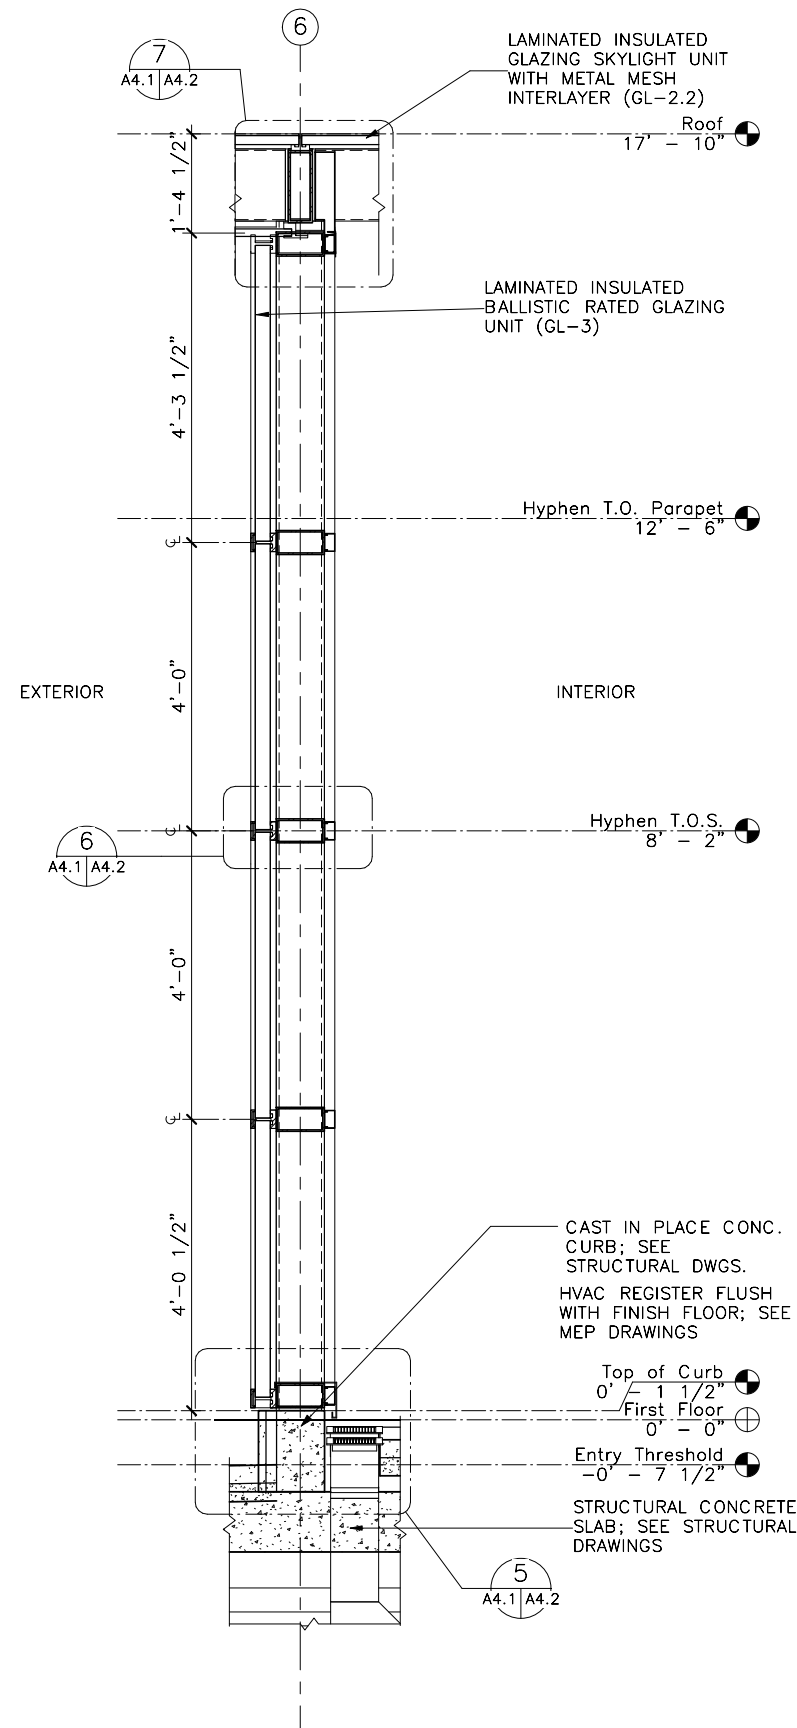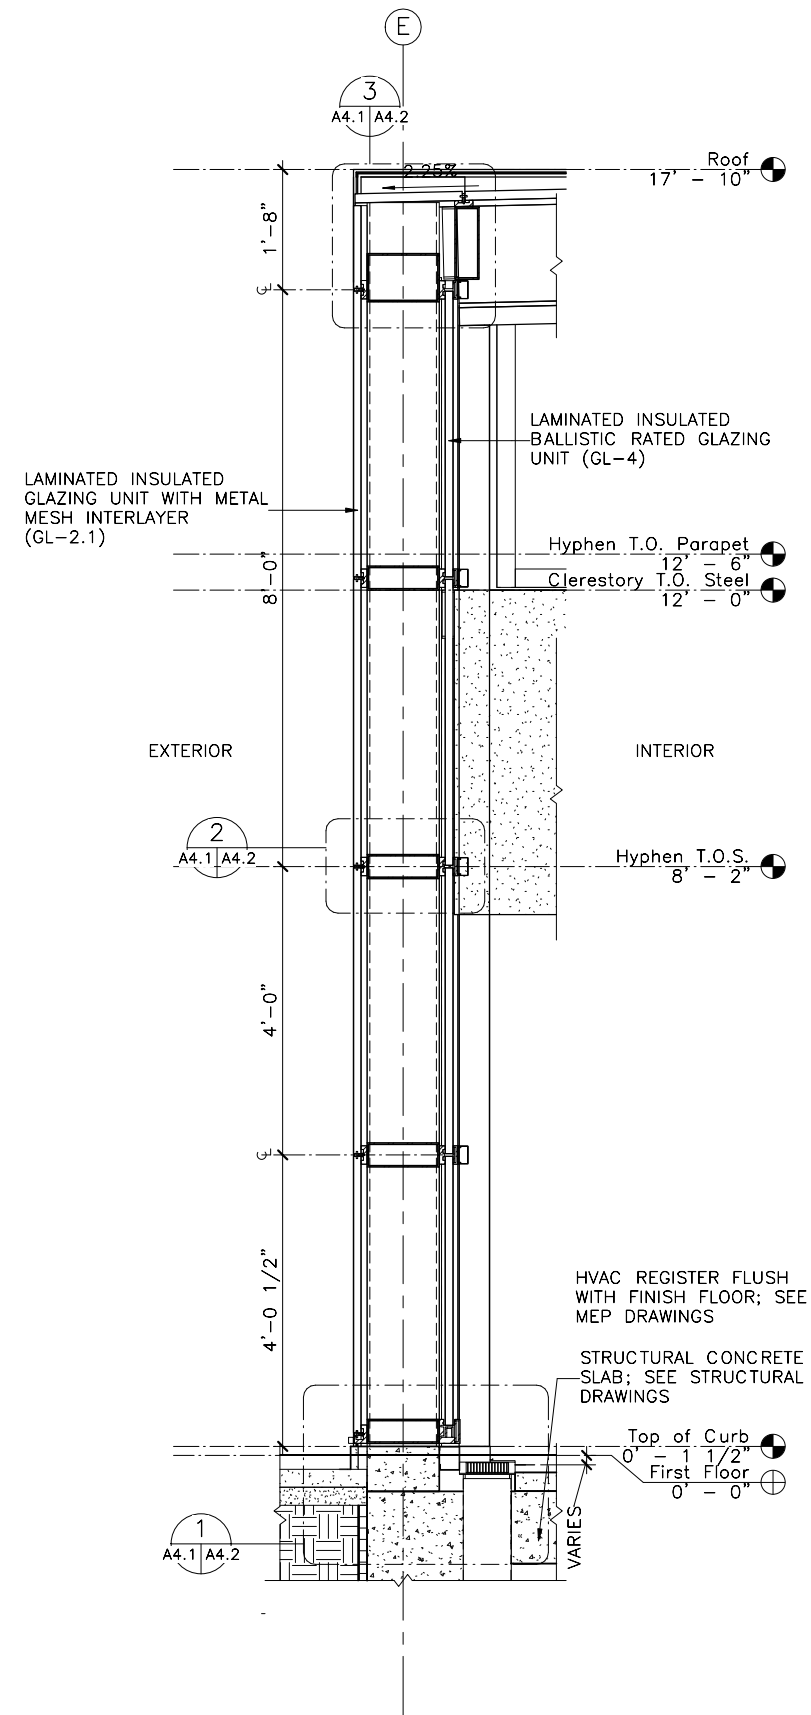


DESIGNED: Designer	SUB SHEET NO.	TITLE OF SHEET	DRAWING NO.
Author	A4.1	WALL SECTIONS	807
TECH. REVIEW:		100% DRAFT CONSTRUCTION DOCUMENTS	PMIS/PKG NO.
Checker		WASHINGTON MONUMENT	NAMA
DATE:		NATIONAL MALL AND MEMORIAL PARKS	151073
12/30/2016			SHEET
			39 of 129

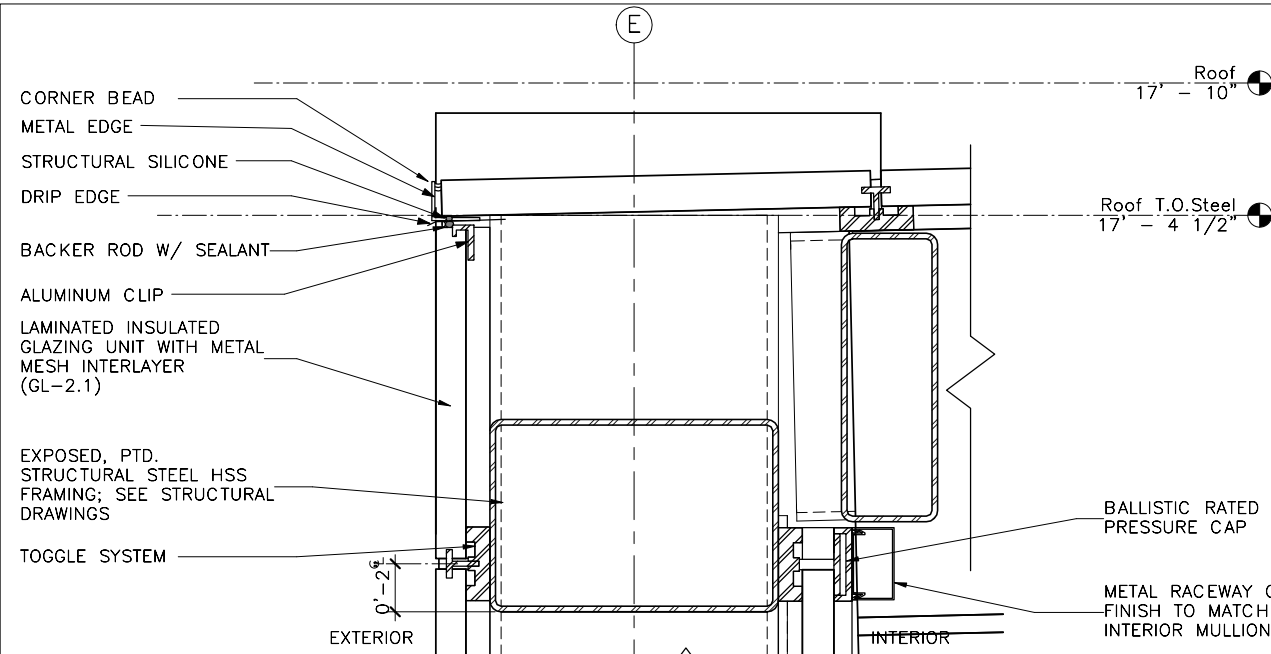


3 Detail - Roof South
A4.2 SCALE (A)

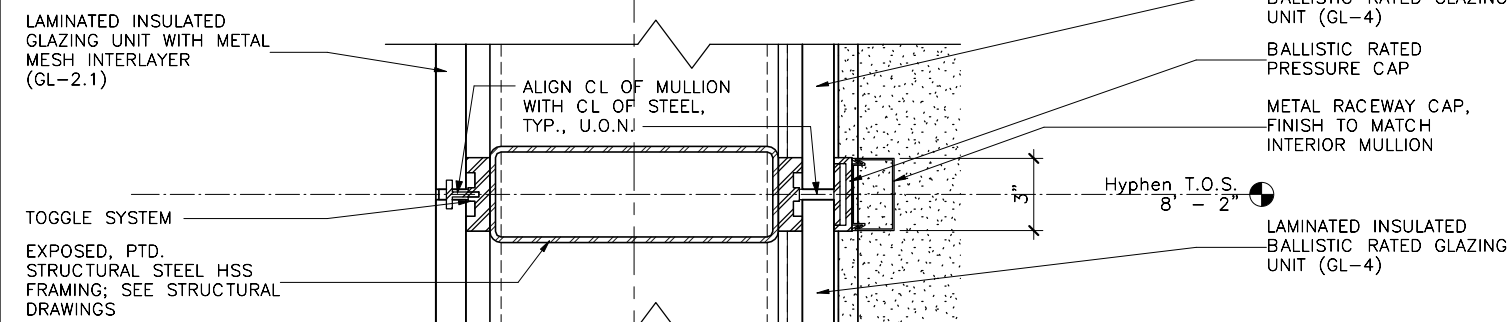


2 Detail - Wall South
A4.2 SCALE (A)

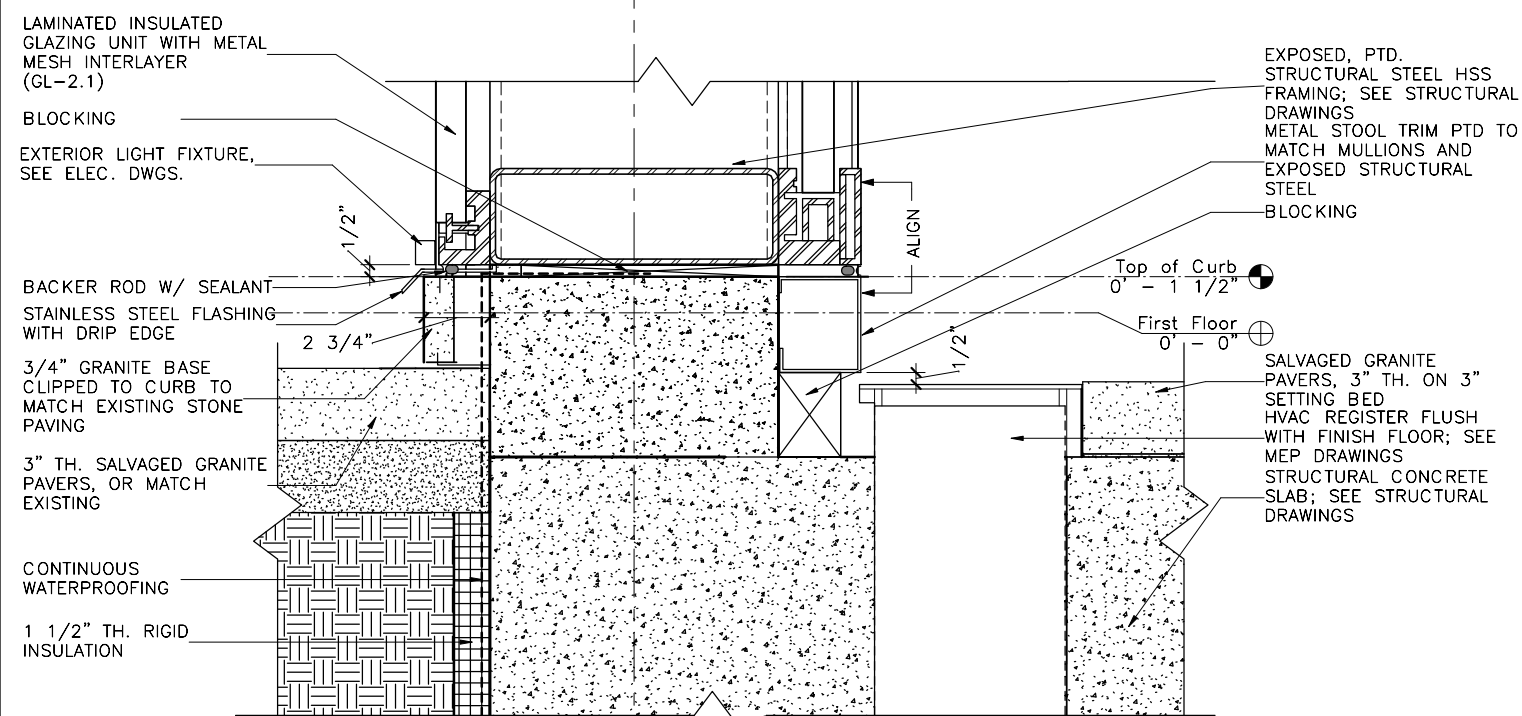


1 Detail - Wall Base South
A4.2 SCALE (A)

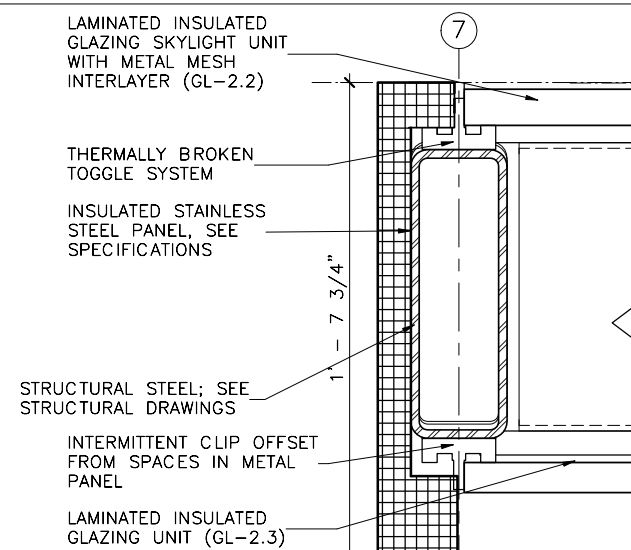


4 Section Detail - East Wall at Roof
A4.2 SCALE (A)

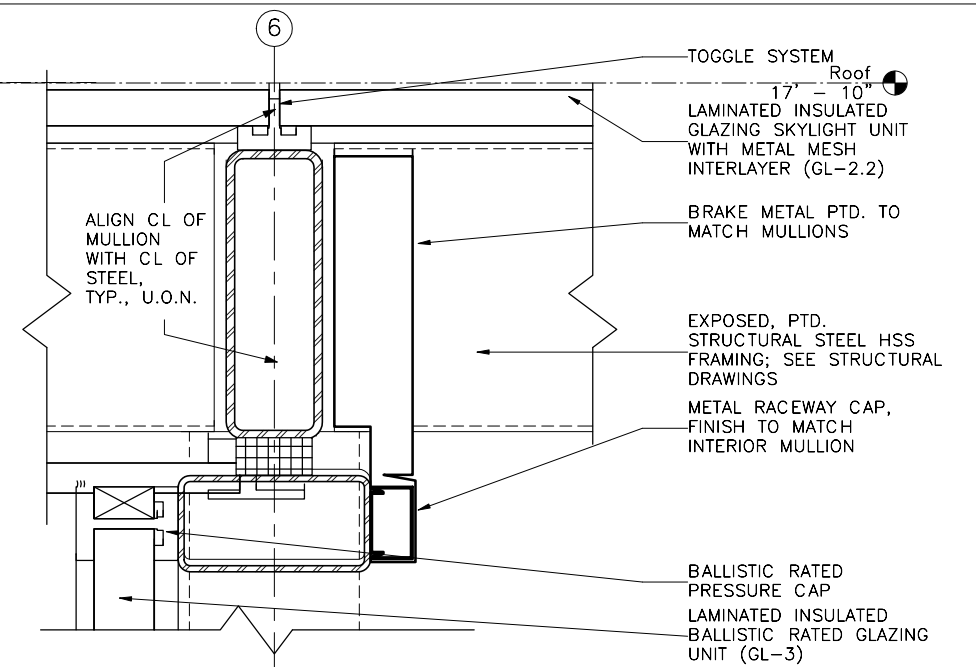

7 Detail - Roof East
A4.2 SCALE (A)

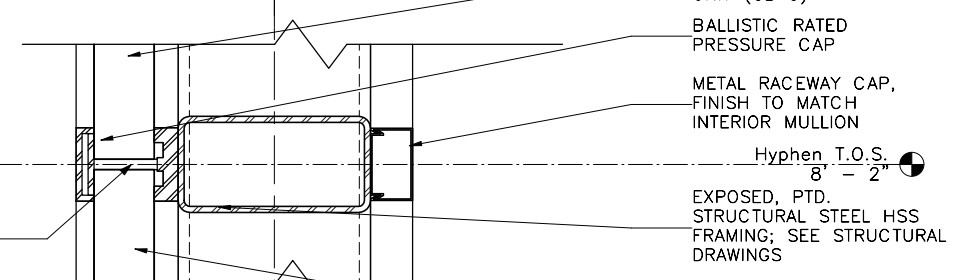


6 Detail - Wall East
A4.2 SCALE (A)

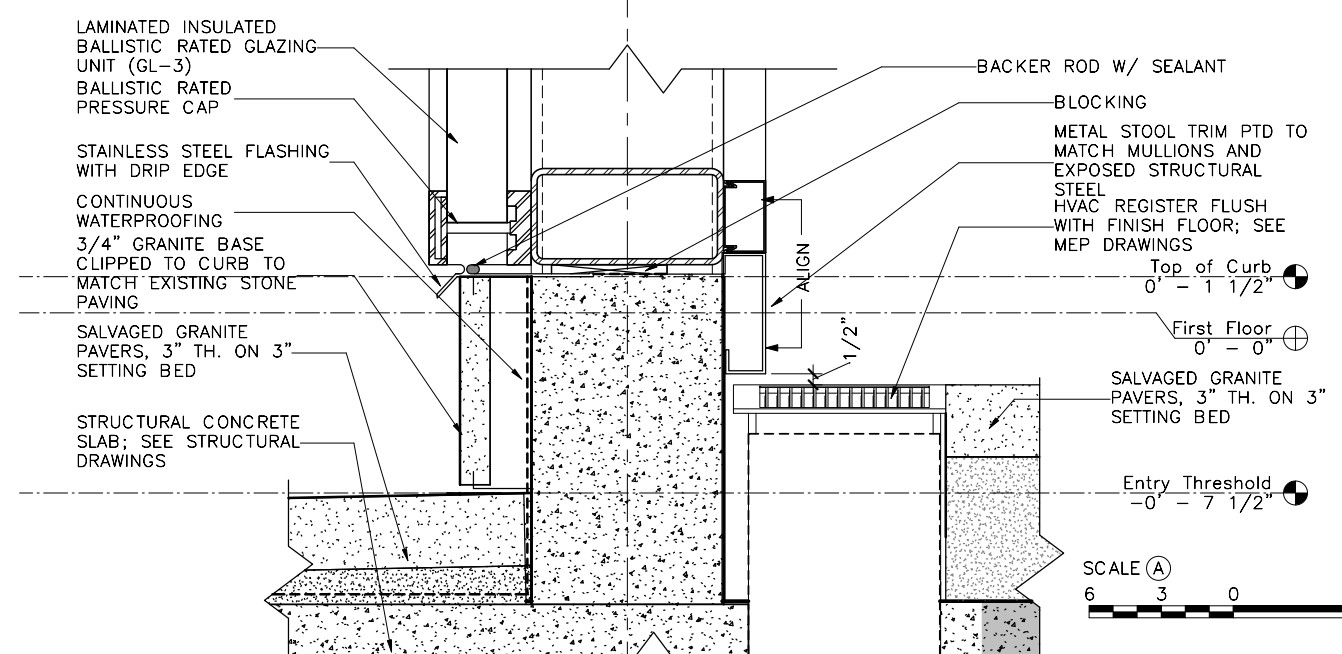


5 Detail - Wall Base East
A4.2 SCALE (A)


DESIGNED: LD ADD	SUB SHEET NO. A4.2	TITLE OF SHEET BUILDING DETAILS	DRAWING NO. 807
TECH. REVIEW: LD		100% DRAFT CONSTRUCTION DOCUMENTS WASHINGTON MONUMENT NATIONAL MALL AND MEMORIAL PARKS	PMIS/PKG NO. 101713A
DATE: 12/30/2016			NAMA 151073
			SHEET 40 of 129

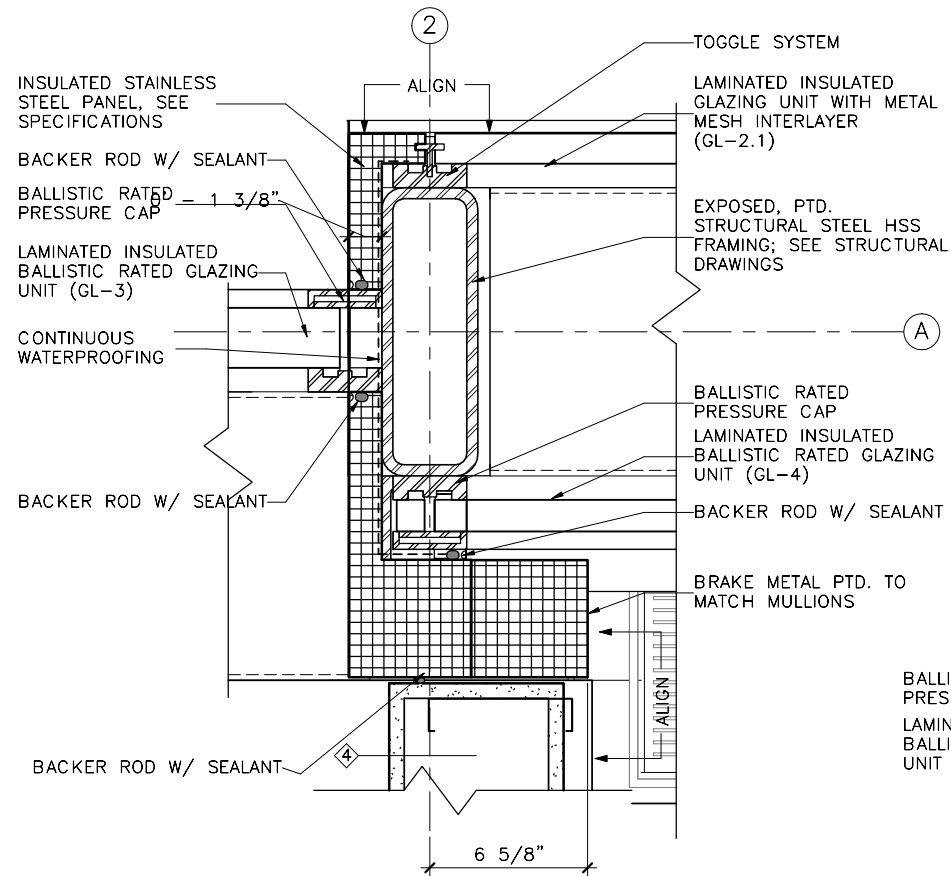


2 Plan Detail - North
Wall 2
A4.3 SCALE (B)

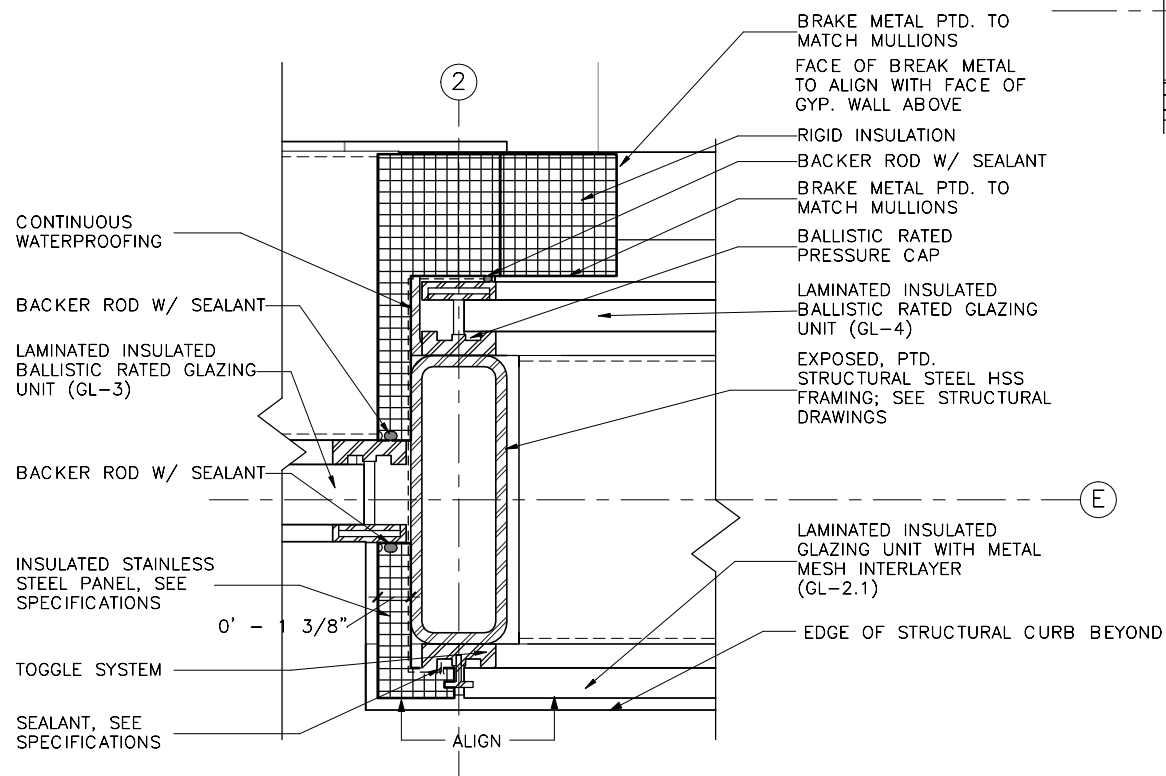


1 Plan Detail - South
Wall 1
A4.3 SCALE (B)

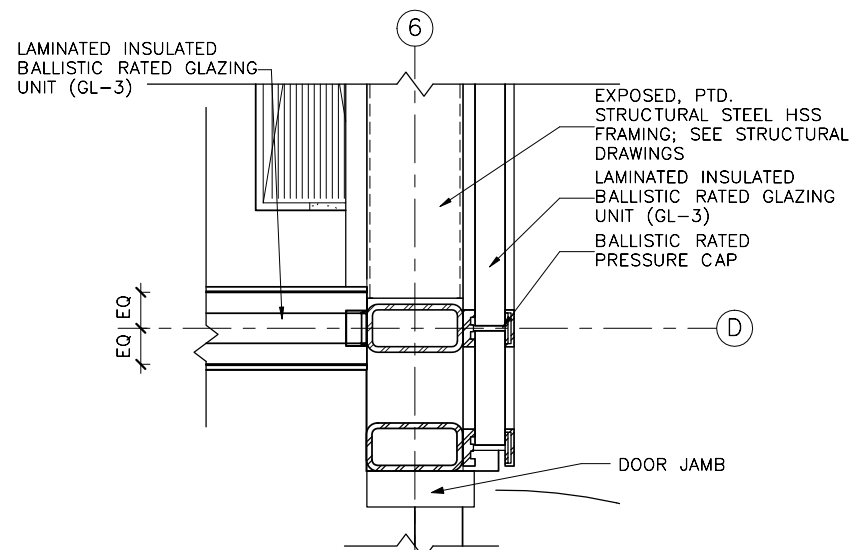


5 Plan Detail - East Wall
A4.3 SCALE (A)

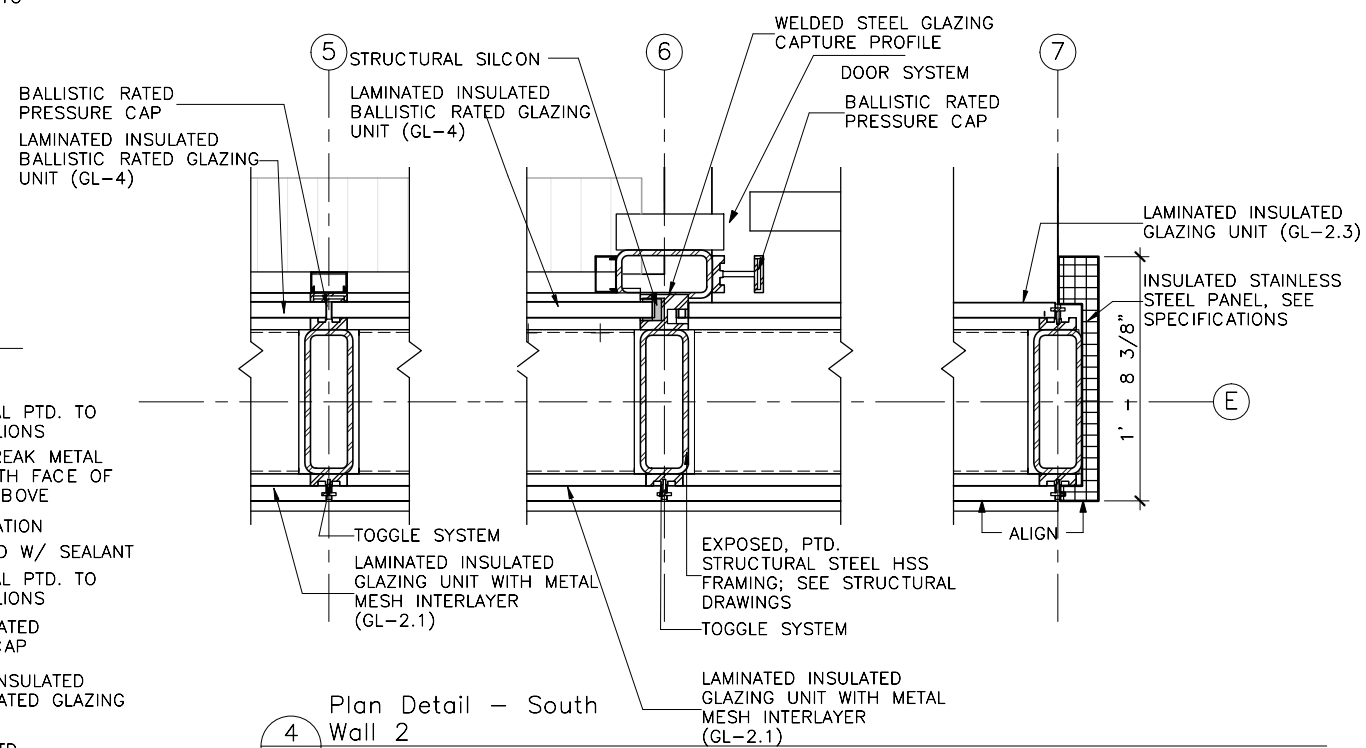


4 Plan Detail - South
Wall 2
A4.3 SCALE (A)

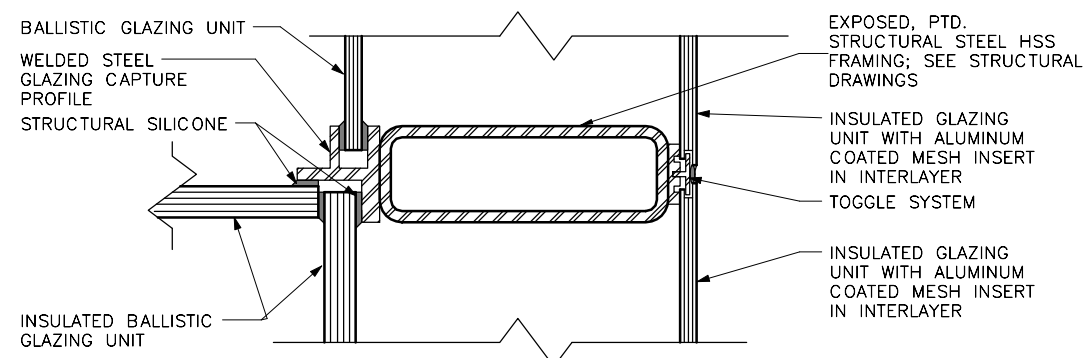

3 PLAN DETAIL - GLAZING
AT WALL INTERFACE
A4.3 SCALE (B)

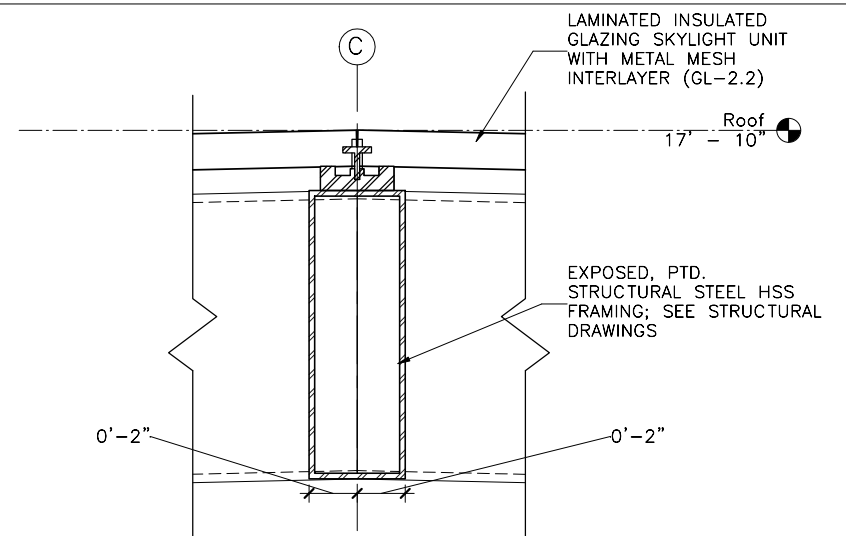


6 Section Detail - Roof
Peak
A4.3 SCALE (B)

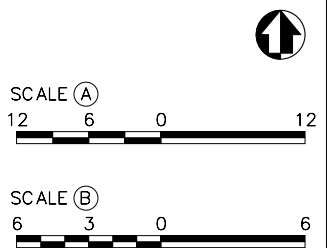


DESIGNED: LD GADD SA	SUB SHEET NO. A4.3	TITLE OF SHEET BUILDING DETAILS	DRAWING NO. 807 101713A
TECH. REVIEW: LD		100% DRAFT CONSTRUCTION DOCUMENTS WASHINGTON MONUMENT NATIONAL MALL AND MEMORIAL PARKS	PMIS/PKG NO. NAMA 151073
DATE: 12/30/2016			SHEET 41 of 129

12/30/2016 1:22:02 PM

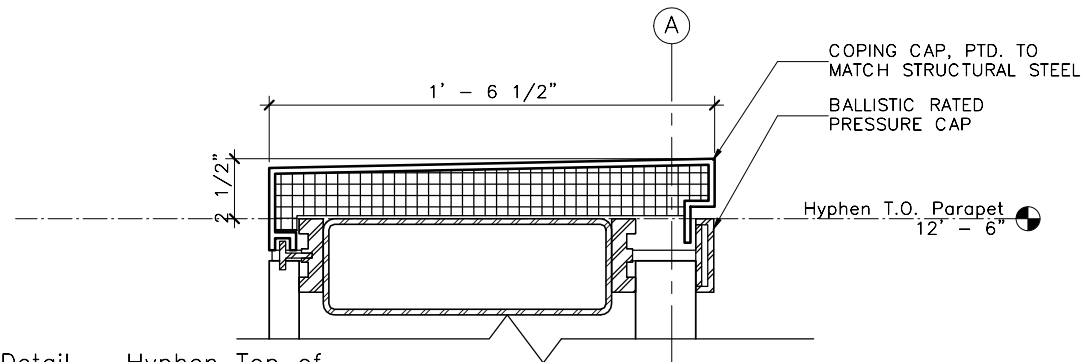


Detail - Hyphen Top of Parapet

3
A4.4
SCALE (B)

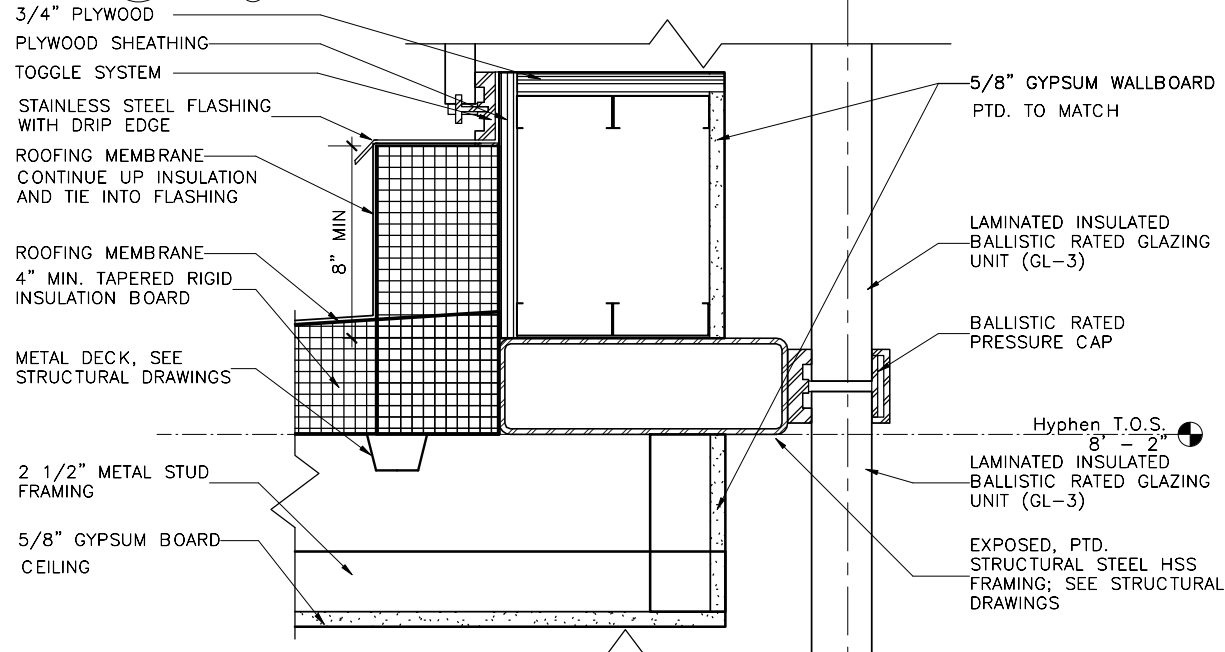


Detail - Hyphen Roof North

2
A4.4
SCALE (B)

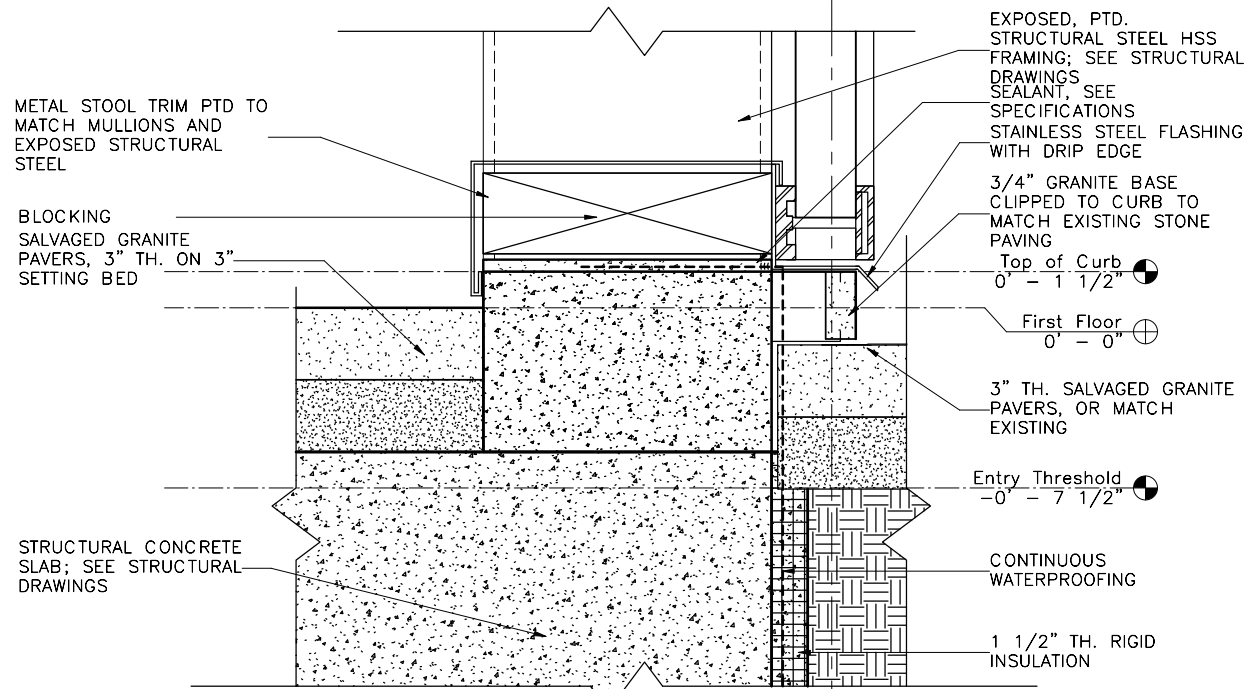

Detail - Wall Base Hyphen North

1
A4.4
SCALE (B)

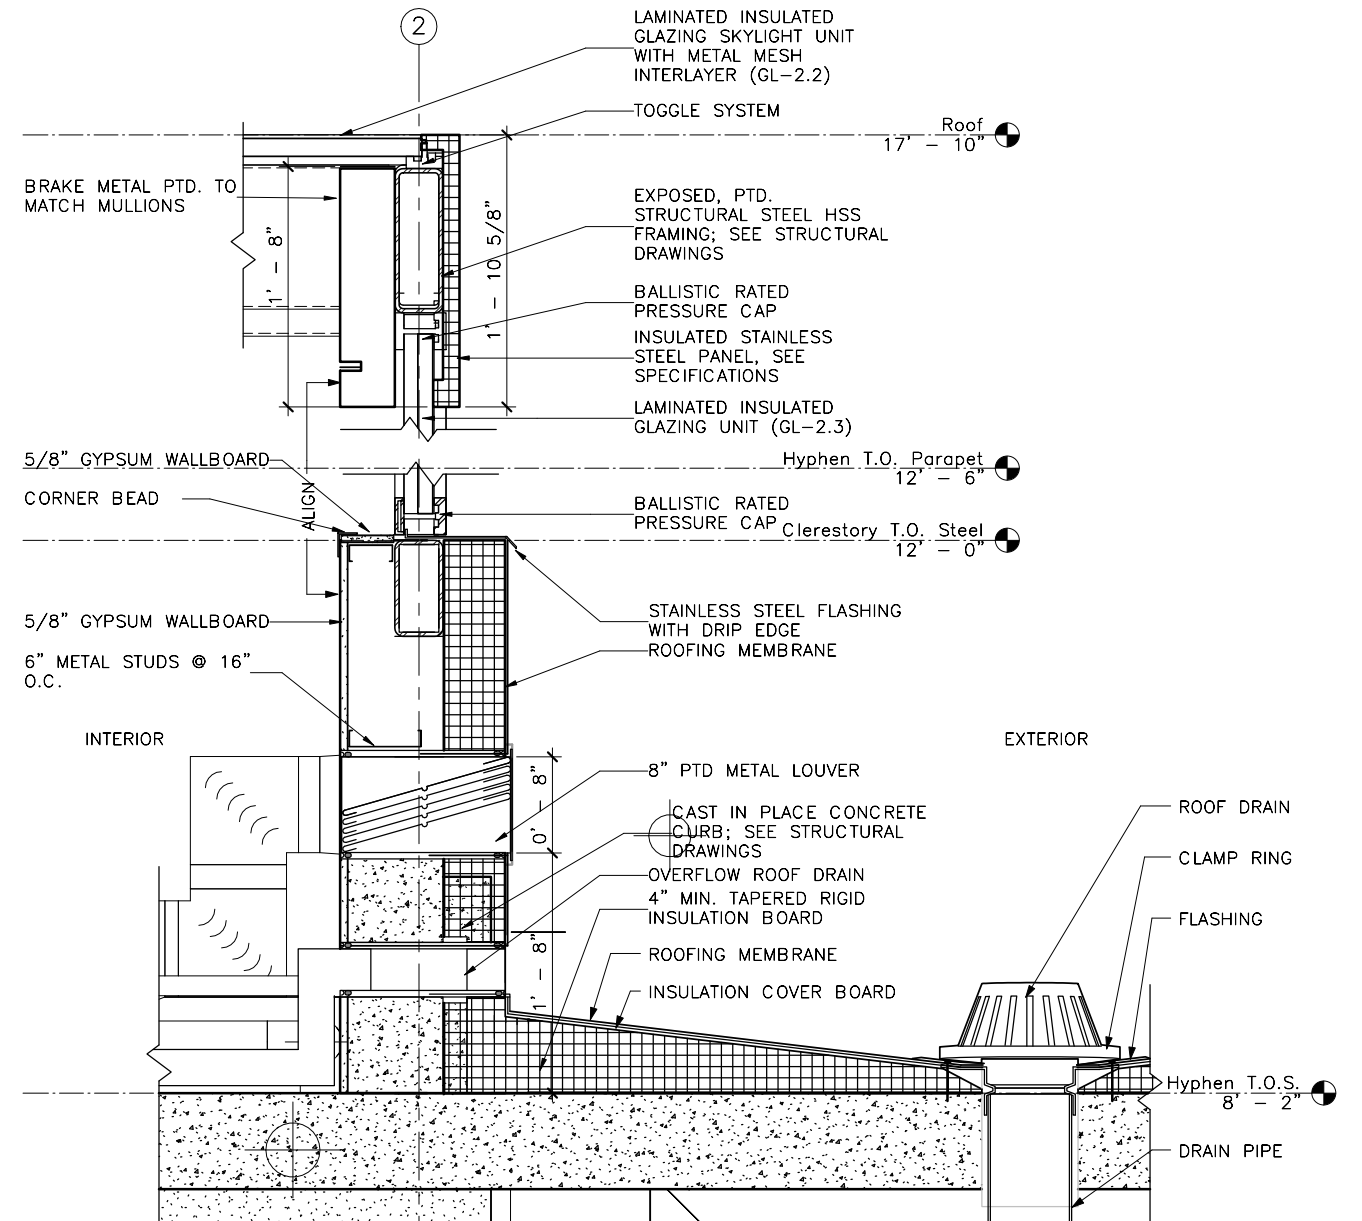

Section Detail - West Wall at Roof

4
A4.4
SCALE (A)


SCALE (A)
12 6 0 12

SCALE (B)
6 3 0 6


DESIGNED:	SUB SHEET NO.	TITLE OF SHEET	DRAWING NO.
LD			807
SA			101713A
TECH. REVIEW:			PMIS/PKG NO.
LD			NAMA
DATE:			151073
12/30/2016			SHEET
			42 of 129

100% DRAFT CONSTRUCTION DOCUMENTS
WASHINGTON MONUMENT
NATIONAL MALL AND MEMORIAL PARKS


BUILDING DETAILS
A4.4

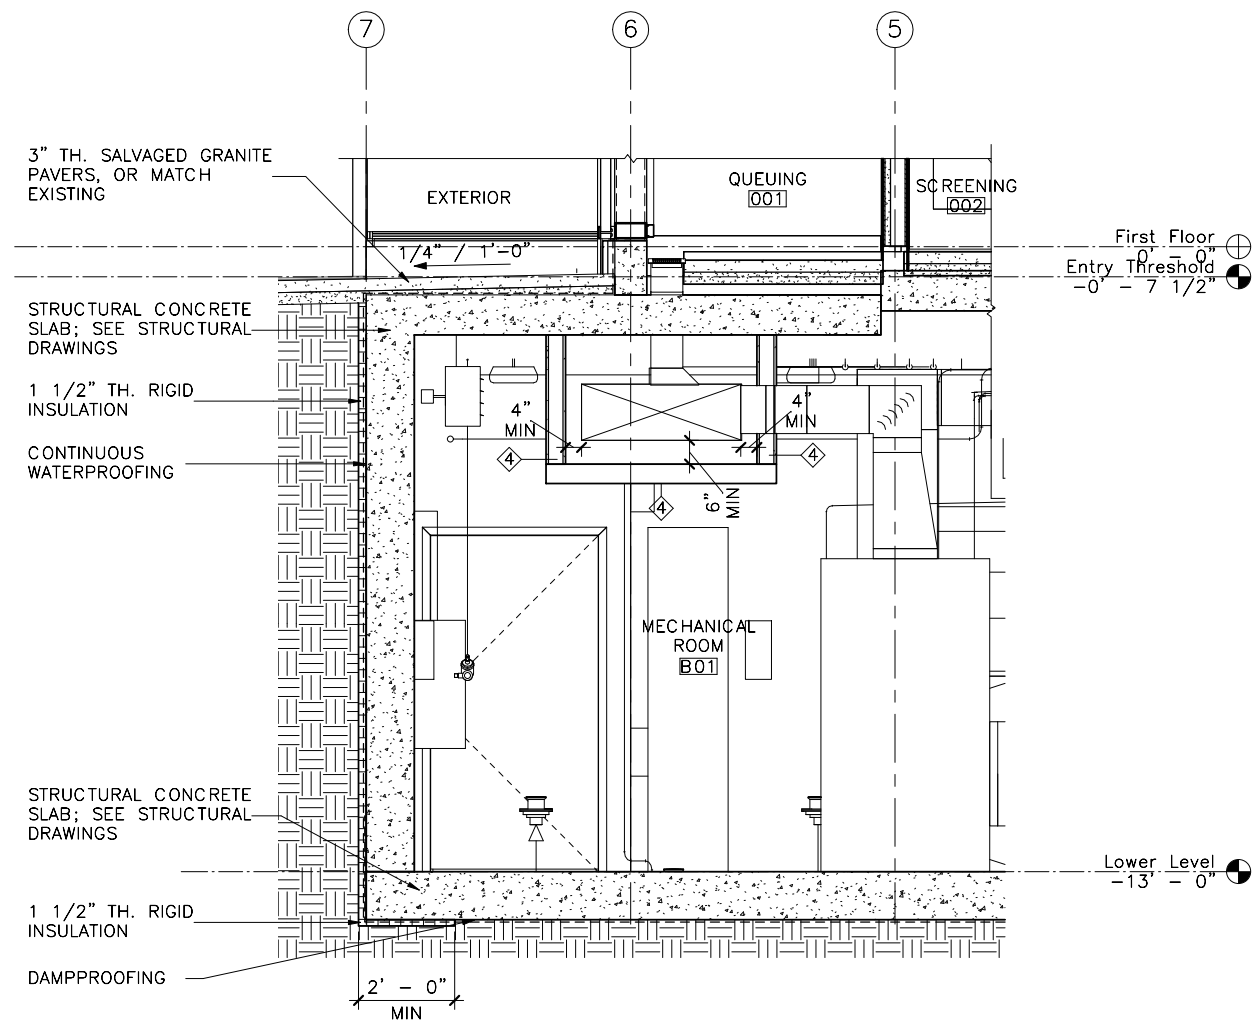


East-West Section 2 -
1 Callout 1
A4.5 SCALE (A)

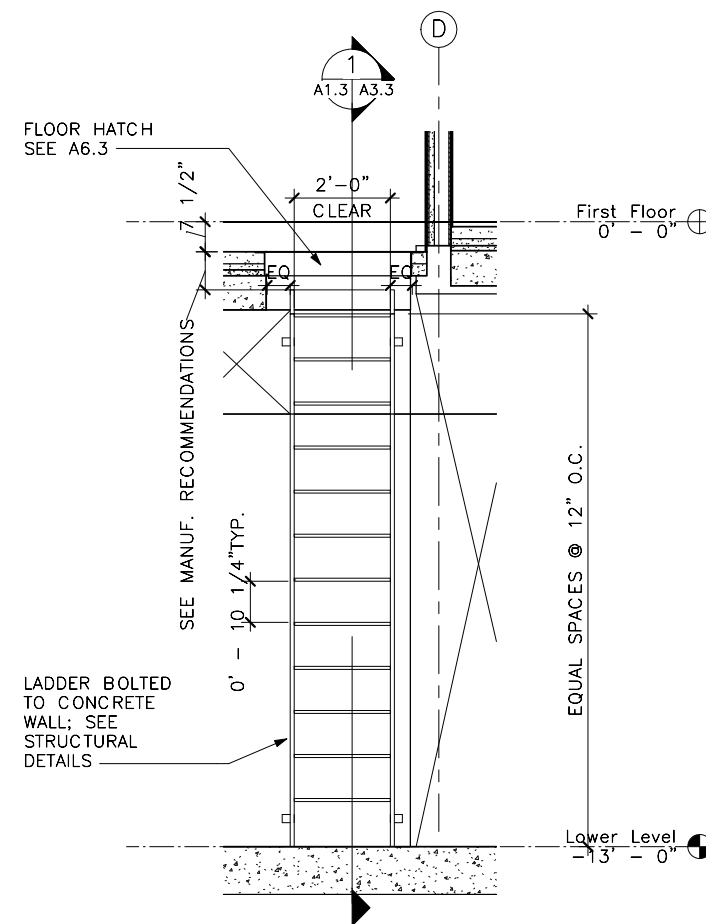


Section Detail - Floor
Hatch & Ladder Detail
2
A4.5 SCALE (A)

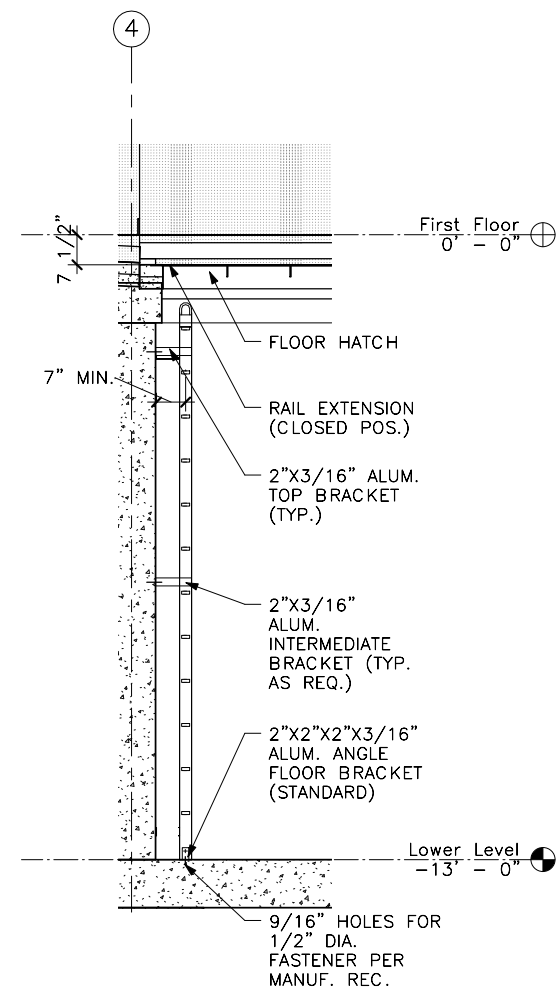

 East-West Section 1 -
3 Callout 1
A4.5 SCALE (A)




DESIGNED: LD	SUB SHEET NO. A4.5	TITLE OF SHEET LOWER LEVEL DETAILS	DRAWING NO. 807 101713A
SA			PMIS/PKG NO. NAMA 151073
TECH. REVIEW: LD			SHEET
DATE: 12/30/2016		100% DRAFT CONSTRUCTION DOCUMENTS WASHINGTON MONUMENT NATIONAL MALL AND MEMORIAL PARKS	43 of 129

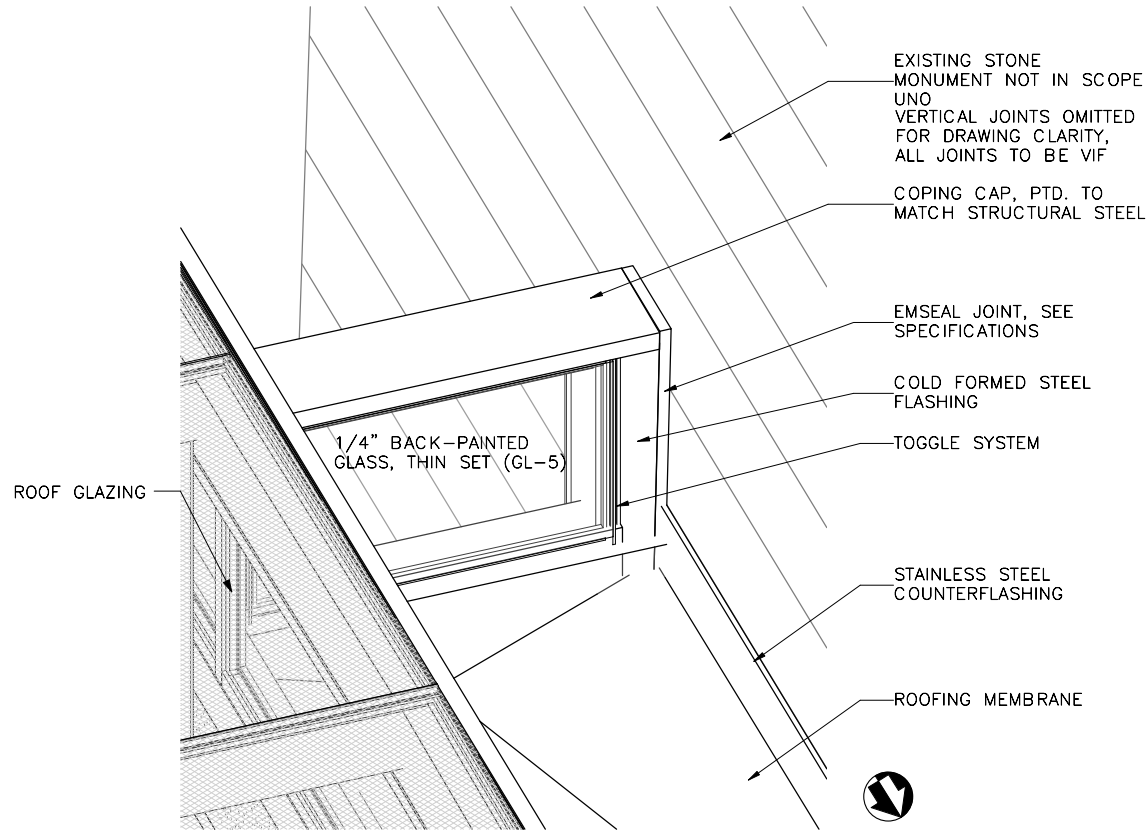


2
A4.6
SCALE (E)

AXON VIEW OF ROOF AT MONUMENT CONNECTION

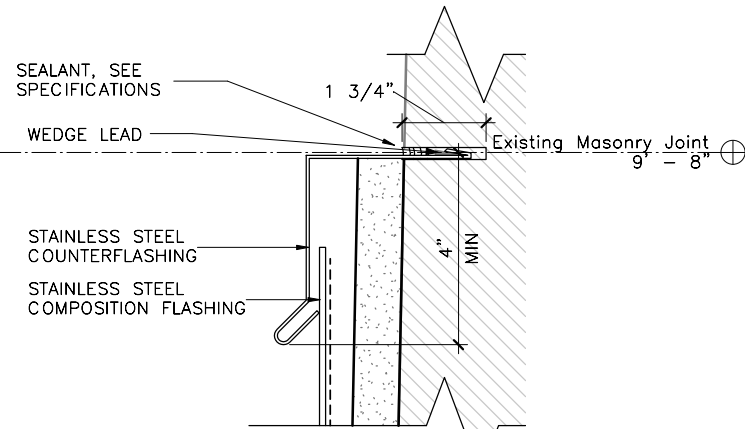

5
A4.6
SCALE (C)


Detail - Grout at Existing Masonry Joint

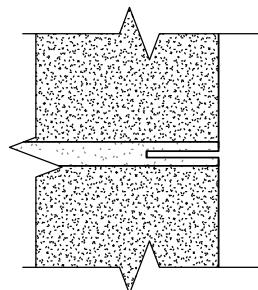


1
A4.6
SCALE (D)

Mortar Removal Procedures






- MAKE NARROW CUT ALONG CENTER OF JOINT
- DEPTH OF CUT TO BE 3/4" ADJACENT MASONRY UNITS

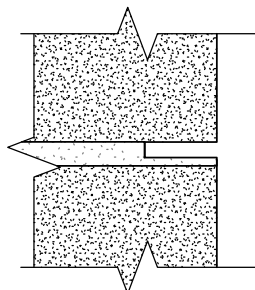

- REMOVE MORTAR FROM ONE SIDE OF JOINT
- USE HAND TOOLS ONLY DIRECT EFFORT FROM MASONRY EDGE TO CENTER OF JOINT DO NOT WIDEN FACE OF JOINT

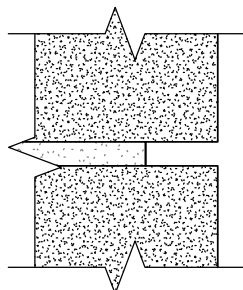

1. REPEAT STEP 2 TO REMOVE MORTAR FROM OPPOSITE SIDE OF JOINT 3/4" MIN. DEPTH OF REMOVAL, OR UNTIL SOUND MORTAR IS REACHED
2. REMOVE ALL DUST AND DEBRIS FROM JOINT

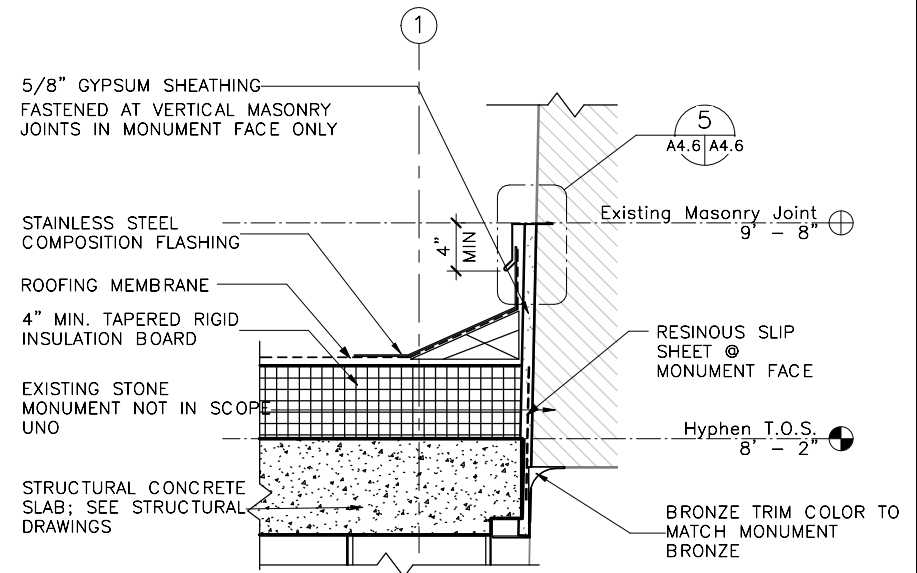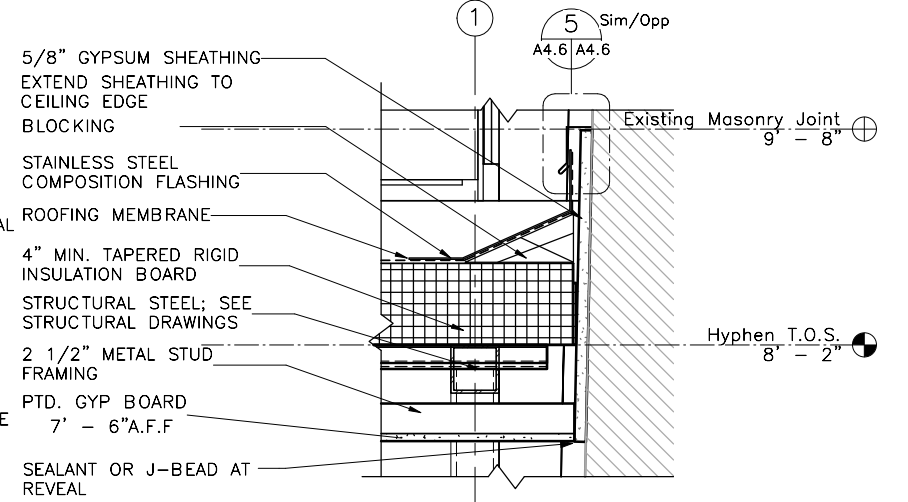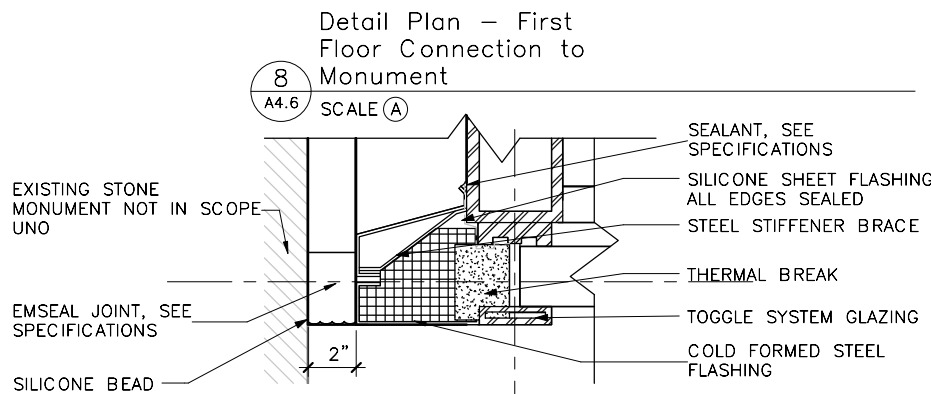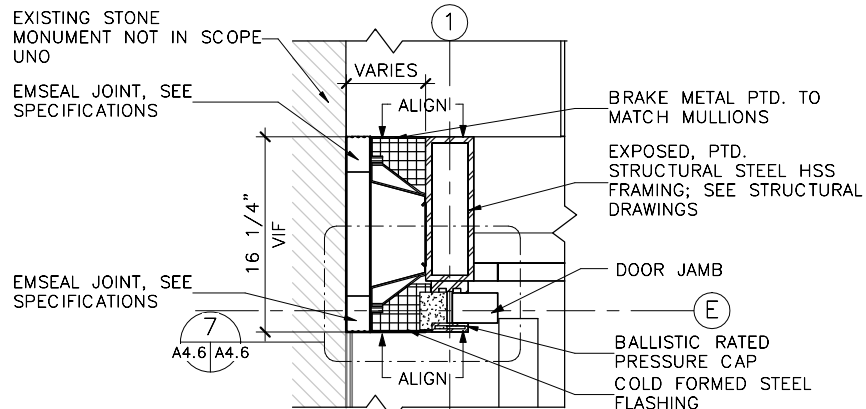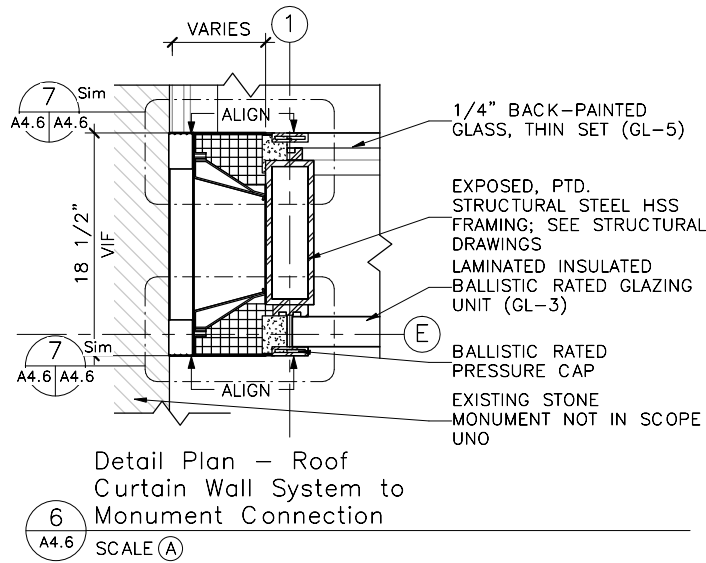

SCALE (E)

2 0 2

SCALE (D)

1 0 1 2

SCALE (C)

2 0 2 4


SCALE (B)

6 3 0 6


SCALE (A)

12 6 0 12


DESIGNED: LD	SUB SHEET NO. A4.6	TITLE OF SHEET ROOF DETAILS	DRAWING NO. 807 101713A
SA			PMIS/PKG NO. NAMA 151073
TECH. REVIEW: LD			SHEET 44 of 129
DATE: 12/30/2016		100% DRAFT CONSTRUCTION DOCUMENTS WASHINGTON MONUMENT NATIONAL MALL AND MEMORIAL PARKS	

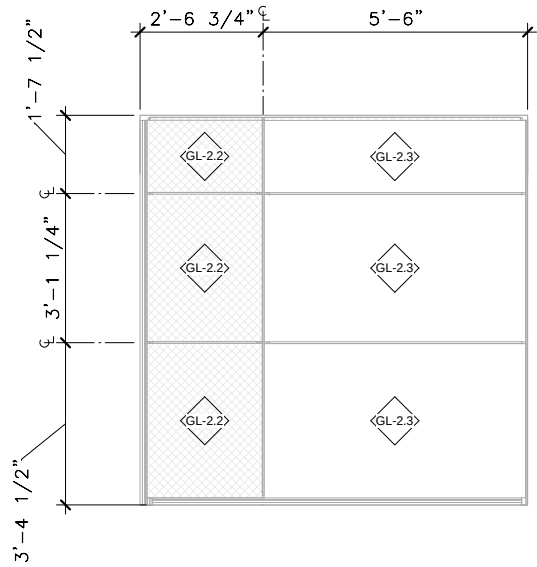


4 CURTAIN WALL MOCKUP
ROOF PLAN
SCALE (A)

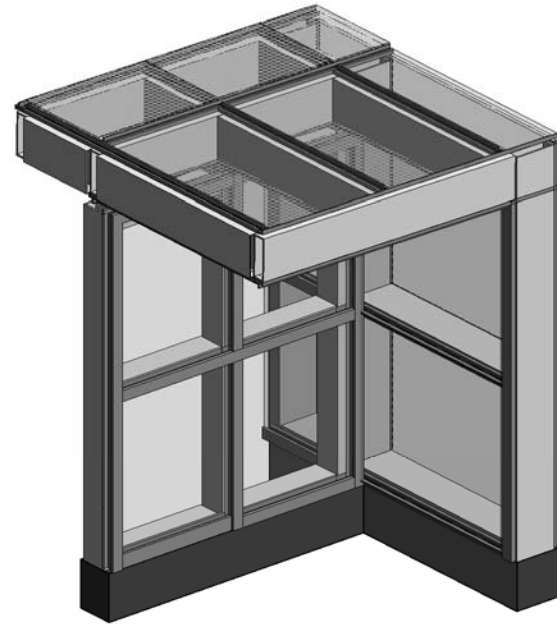


5 CURTAIN WALL MOCKUP
3D VIEW
SCALE (A)

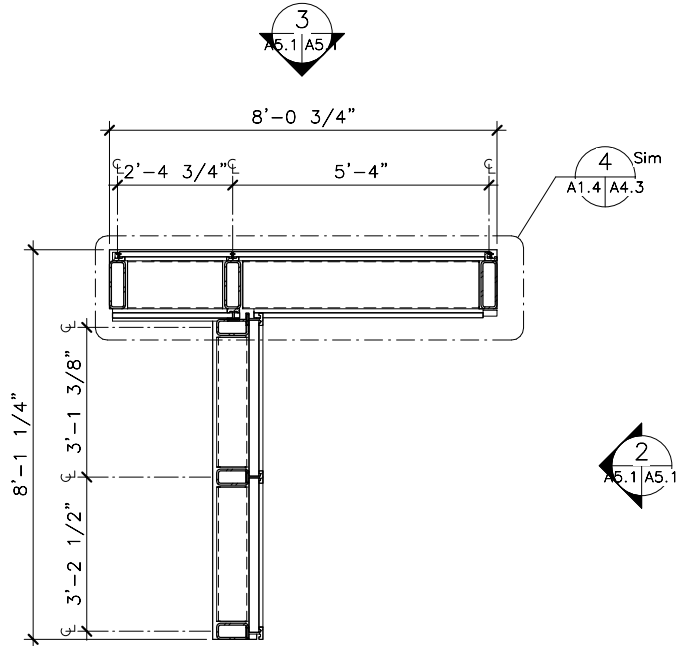

1 CURTAIN WALL MOCKUP
PLAN
SCALE (A)

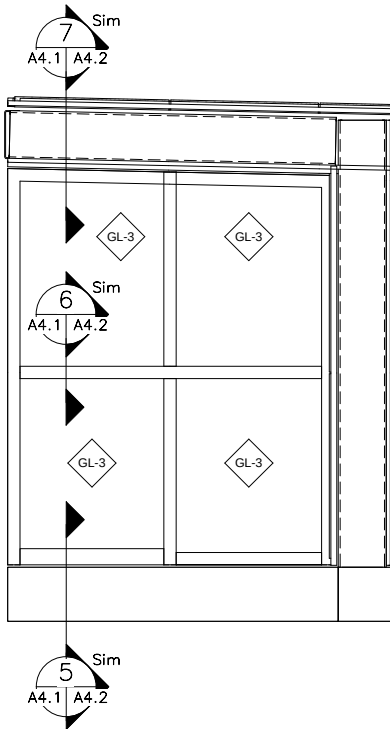








2 CURTAIN WALL MOCKUP
EAST ELEVATION
SCALE (A)

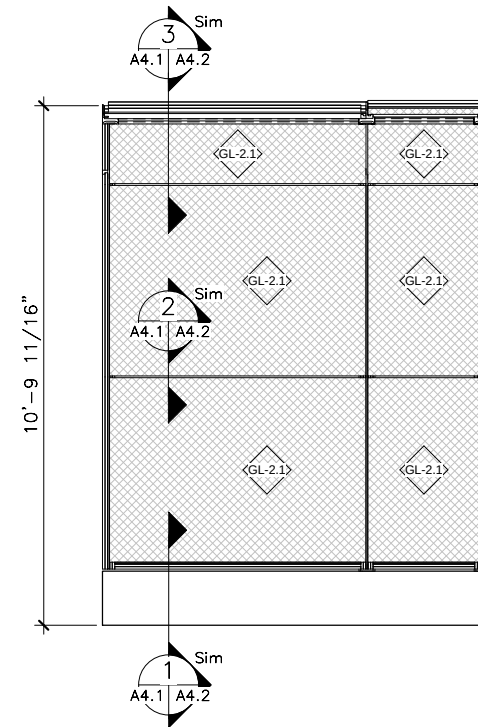

3 CURTAIN WALL MOCKUP
NORTH ELEVATION
SCALE (A)




DESIGNED: Designer	SUB SHEET NO. A5.1	TITLE OF SHEET ELEVATIONS – CURTAIN WALL MOCK-UP 100% DRAFT CONSTRUCTION DOCUMENTS WASHINGTON MONUMENT NATIONAL MALL AND MEMORIAL PARKS	DRAWING NO. 807
Author			101713A
TECH. REVIEW: Checker			PMIS/PKG NO. NAMA 151073
DATE: 12/30/2016			SHEET 45 of 129

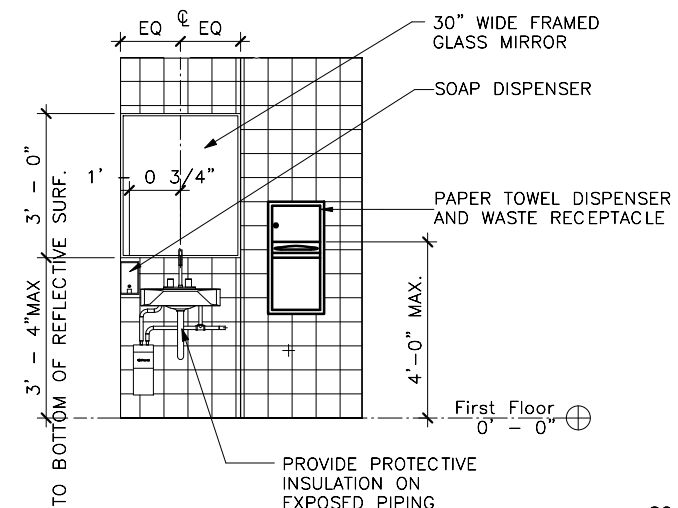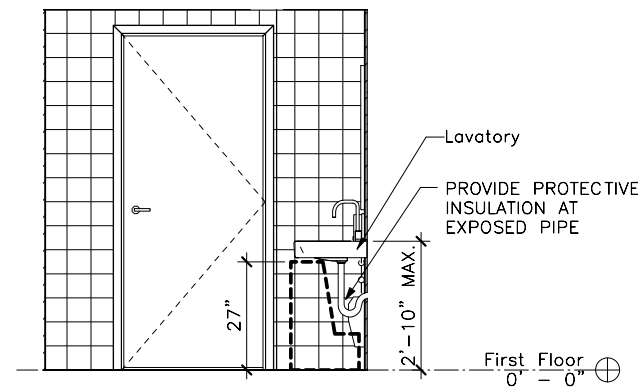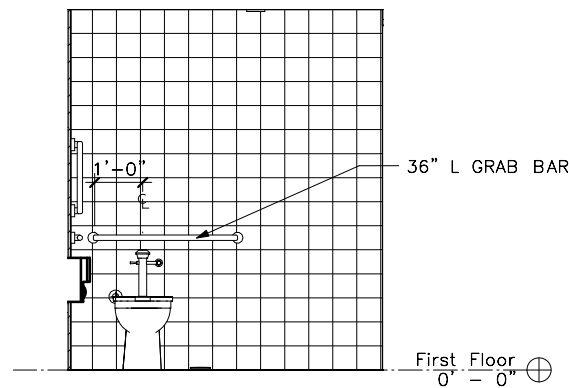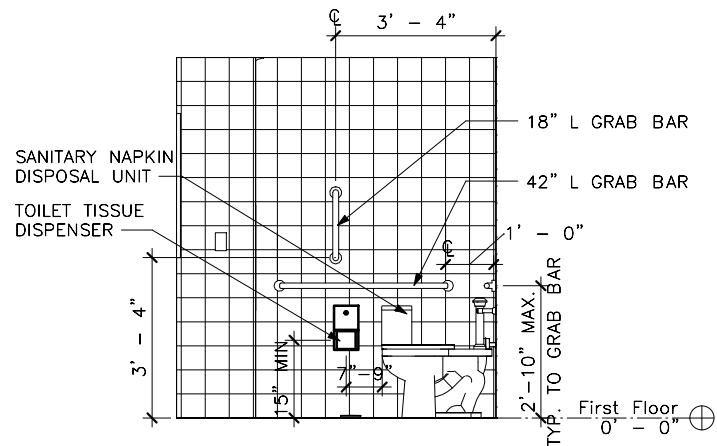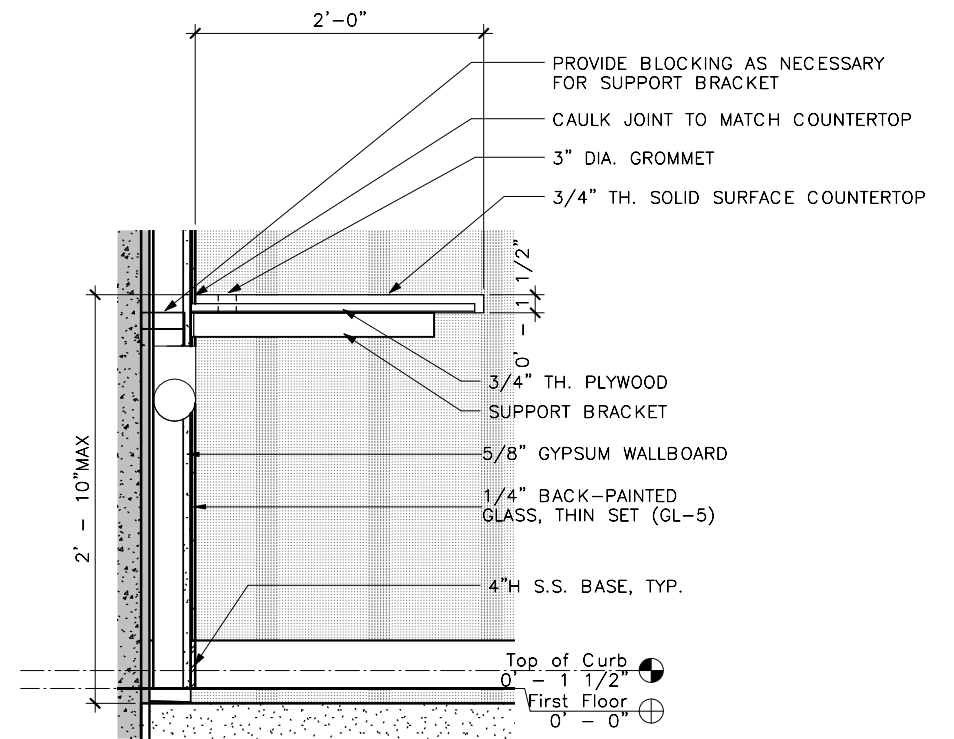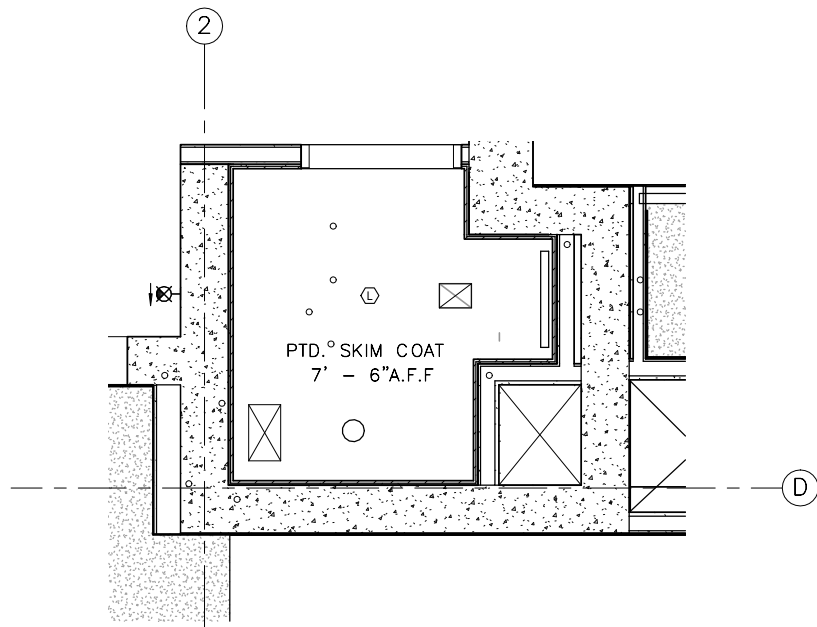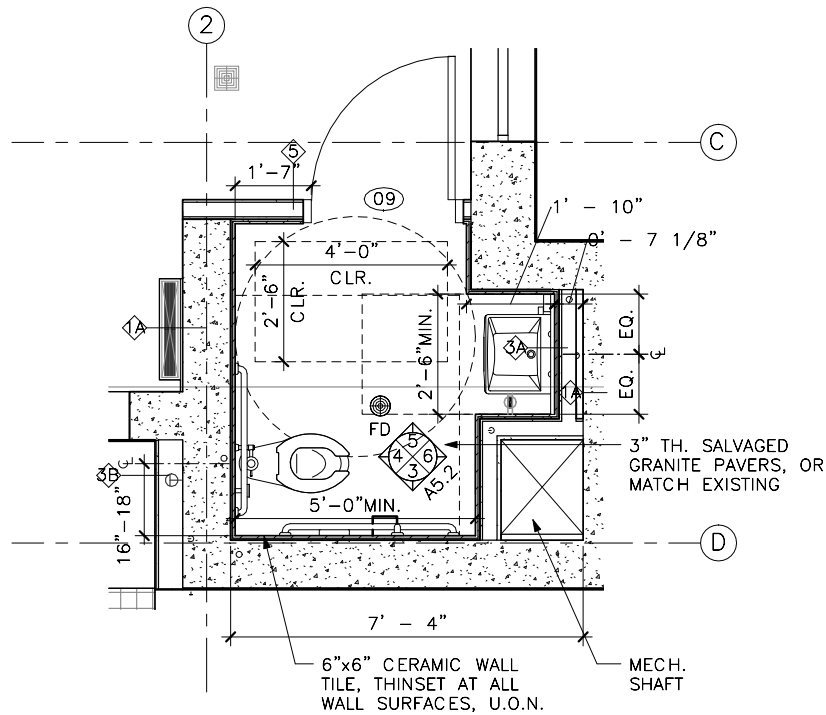


SCALE (B)
12 6 0 12

SCALE (A)
2 0 2 4


DESIGNED: LD	SUB SHEET NO. A5.2	TITLE OF SHEET INTERIOR DETAILS	DRAWING NO. 807 101713A
SA			PMIS/PKG NO. NAMA 151073
TECH. REVIEW: LD		100% DRAFT CONSTRUCTION DOCUMENTS WASHINGTON MONUMENT NATIONAL MALL AND MEMORIAL PARKS	SHEET 46 of 129
DATE: 12/30/2016			

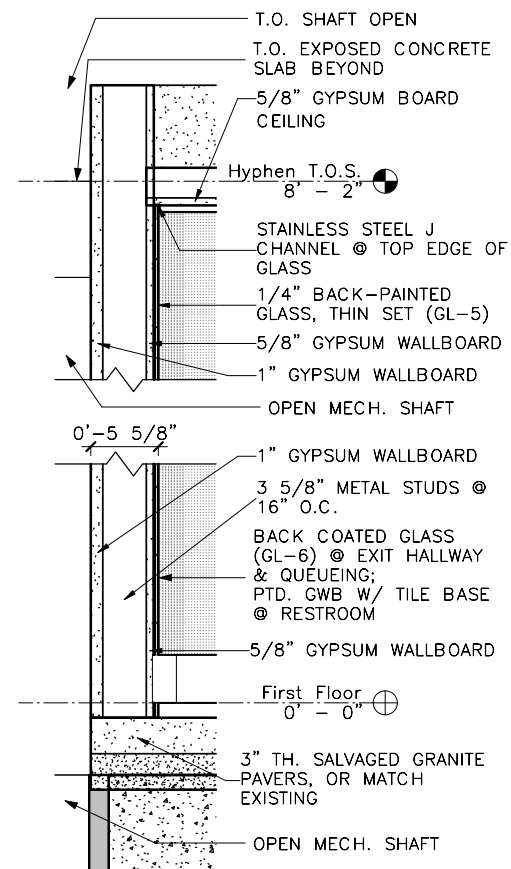


6 Type 6 - Shaft Wall
A6.1 SCALE (A)

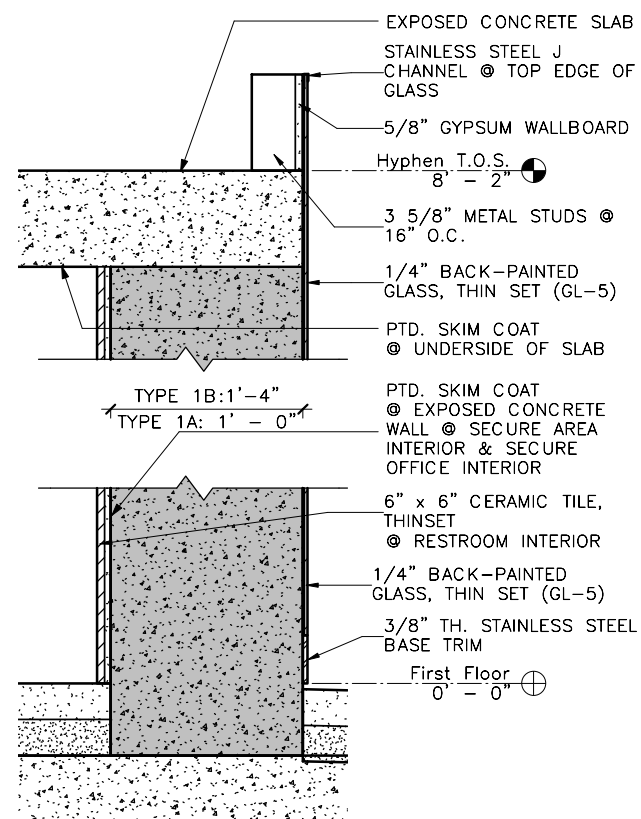


1 Type 1 - Interior CIP Blast Wall
A6.1 SCALE (A)

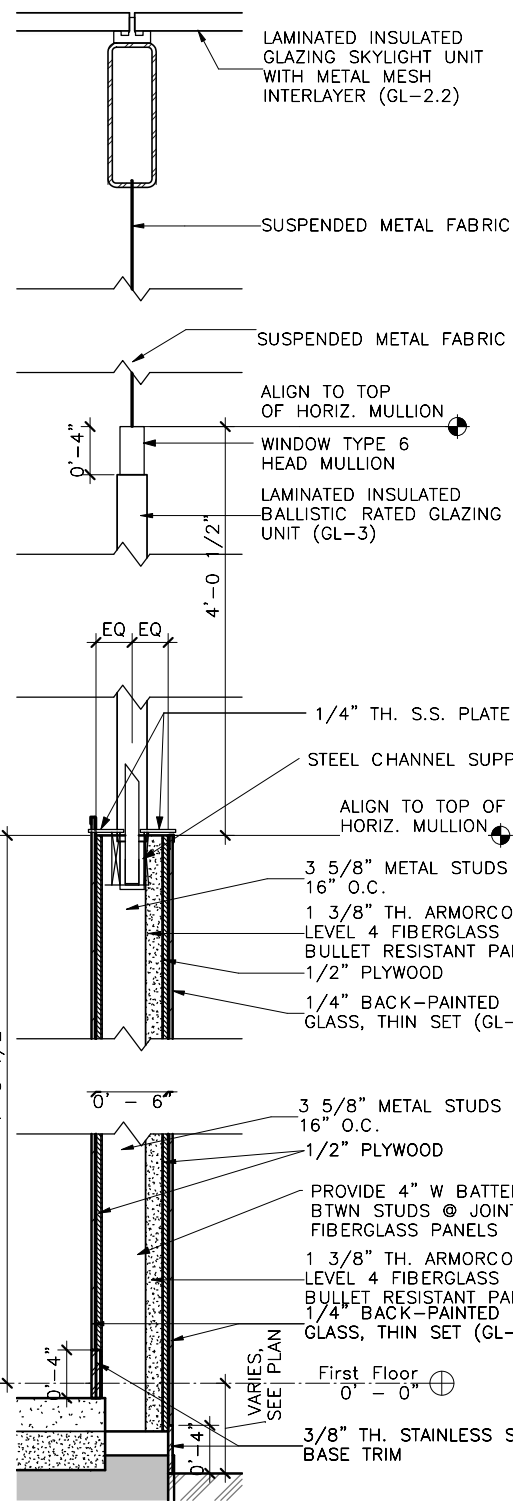


2 Type 2 - Interior Ballistic Rated Partition
A6.1 SCALE (A)

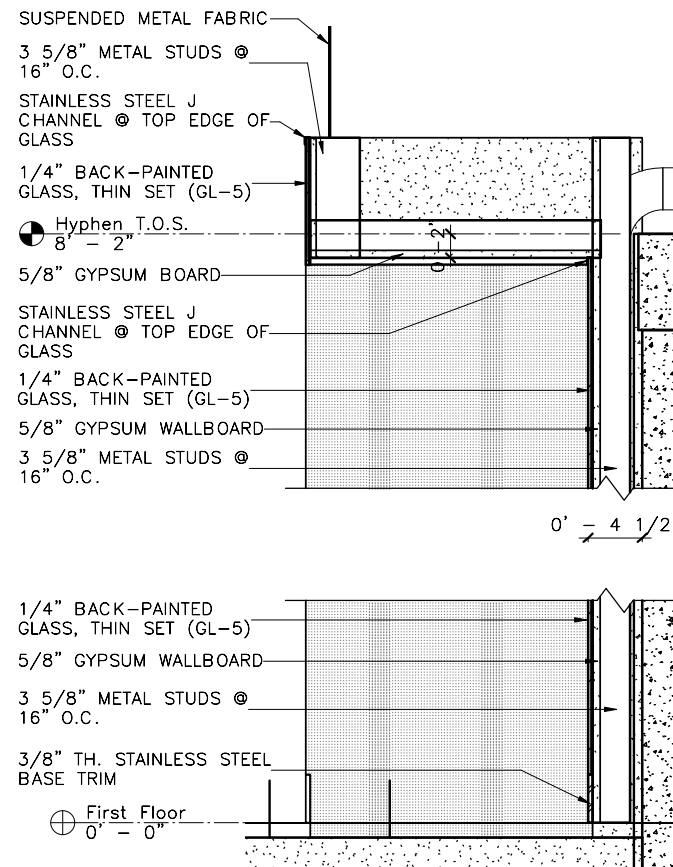



7 Ceiling Detail/
Partition Type 7 - Furring
A6.1 SCALE (A)

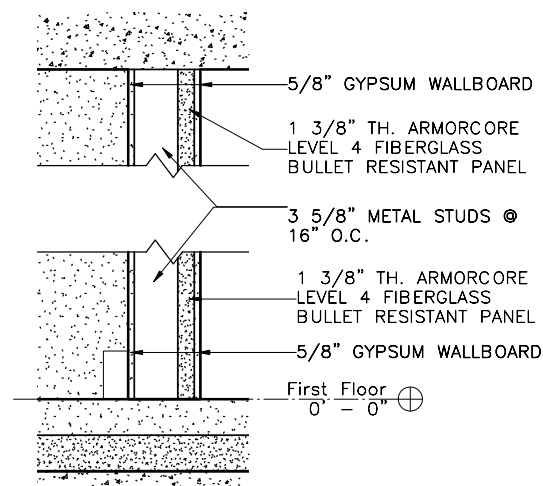


3 Type 3 - Interior Ballistic Rated Partition
A6.1 SCALE (A)

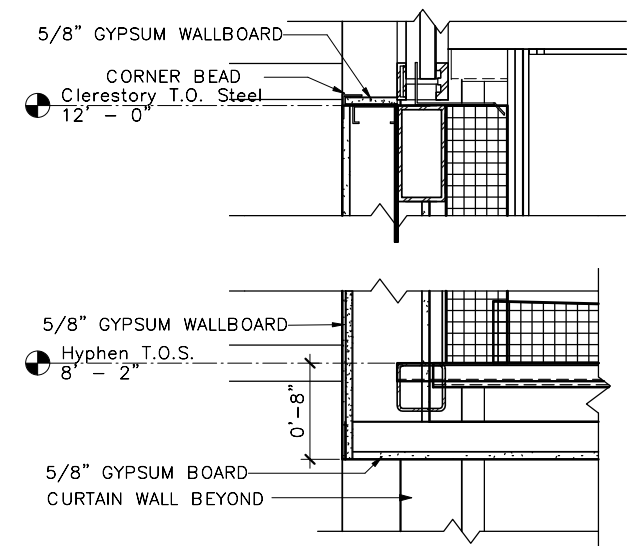

8 Ceiling Detail
A6.1 SCALE (A)

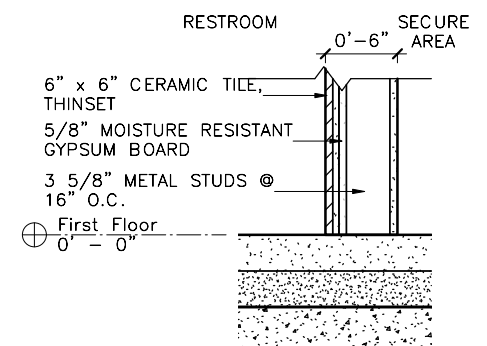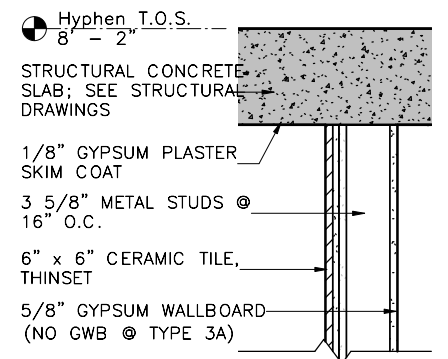


5 Type 3 - Restroom
A6.1 SCALE (A)

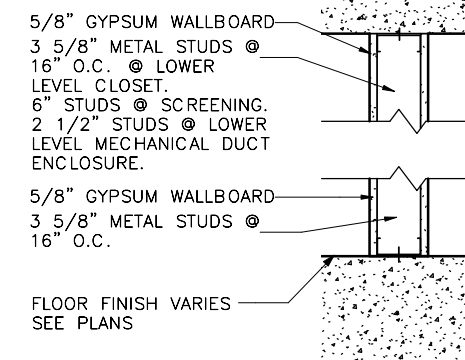


4 Partition Type 4 - 1Hr Rated
A6.1 SCALE (A)

SCALE (A)
12 6 0 12


DESIGNED: LD	SUB SHEET NO. A6.1	TITLE OF SHEET PARTITION TYPES	DRAWING NO. 807 101713A
SA			PMIS/PKG NO. NAMA 151073
TECH. REVIEW: LD			SHEET
DATE: 12/30/2016		100% DRAFT CONSTRUCTION DOCUMENTS WASHINGTON MONUMENT NATIONAL MALL AND MEMORIAL PARKS	47 of 129

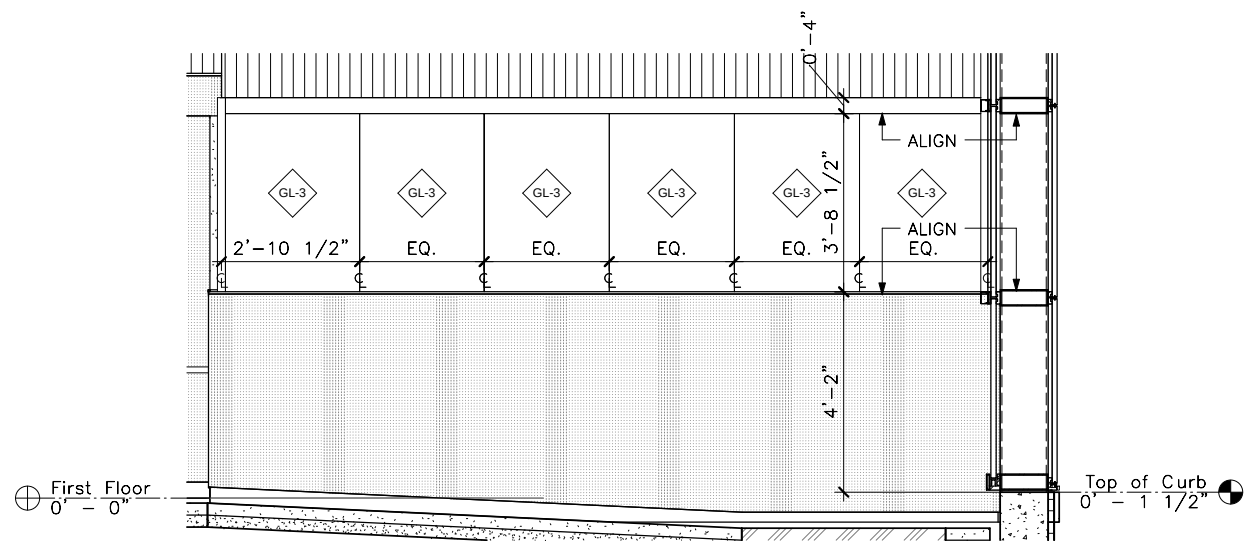


Window Type 6 -
Queueing West
1
A6.2 SCALE (A)

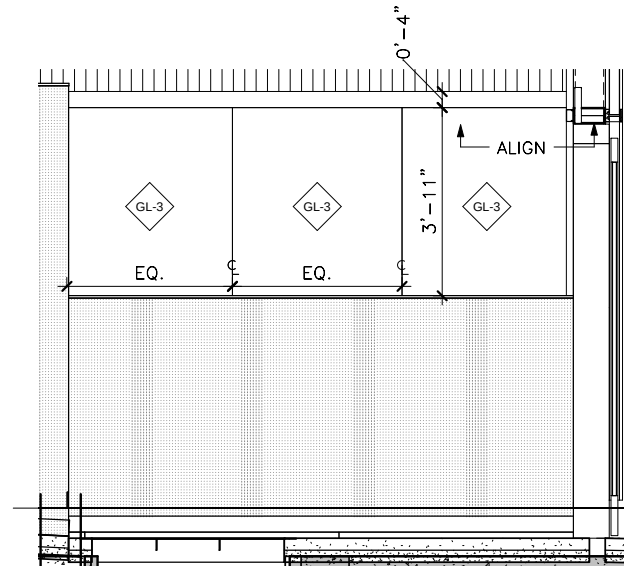


Window Type 6 -
Queueing South
2
A6.2 SCALE (A)

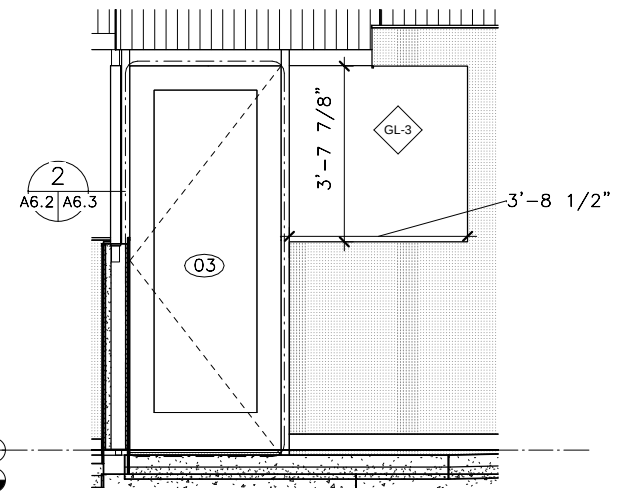


Window Type 6 -
Screening South
3
A6.2 SCALE (A)

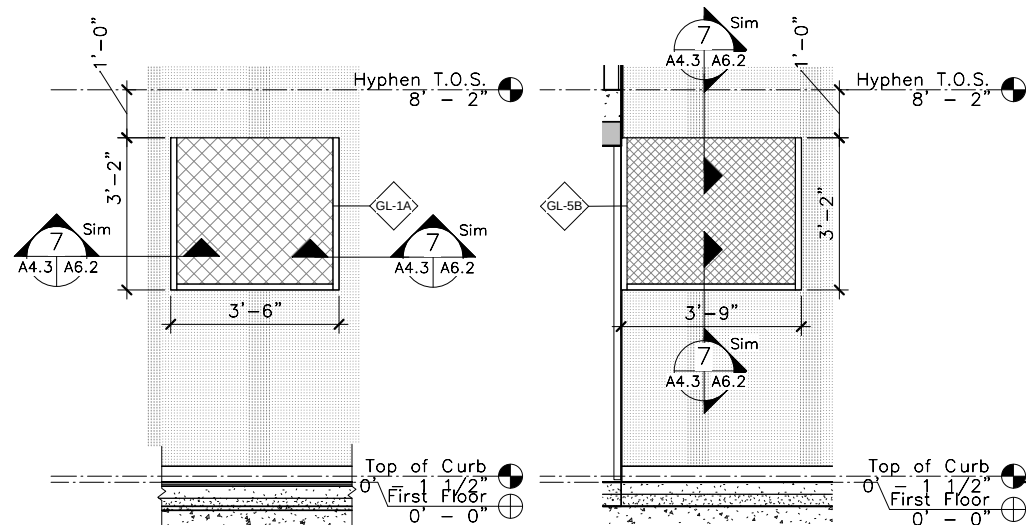


Window Type 7 -
Secure Area
4
A6.2 SCALE (B)

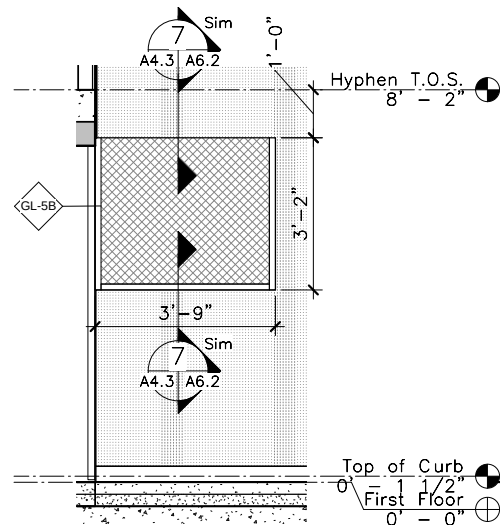

Window Type 8 -
Security Office East
5
A6.2 SCALE (A)

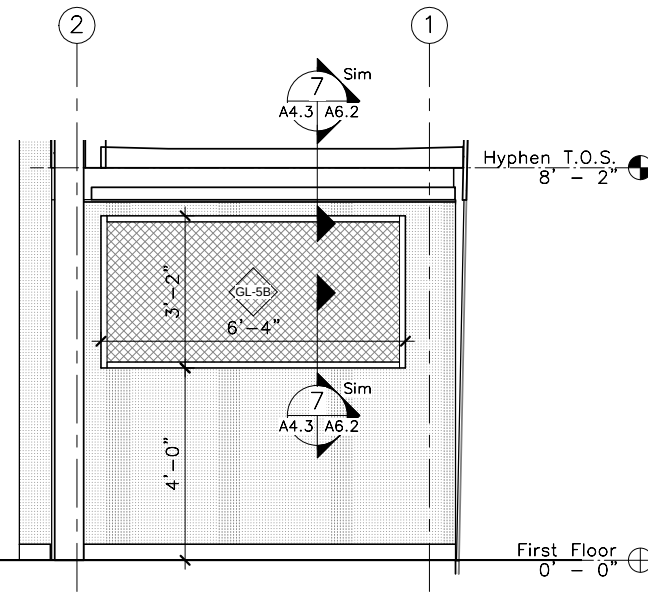

Window Type 9 -
Security Office North
6
A6.2 SCALE (B)

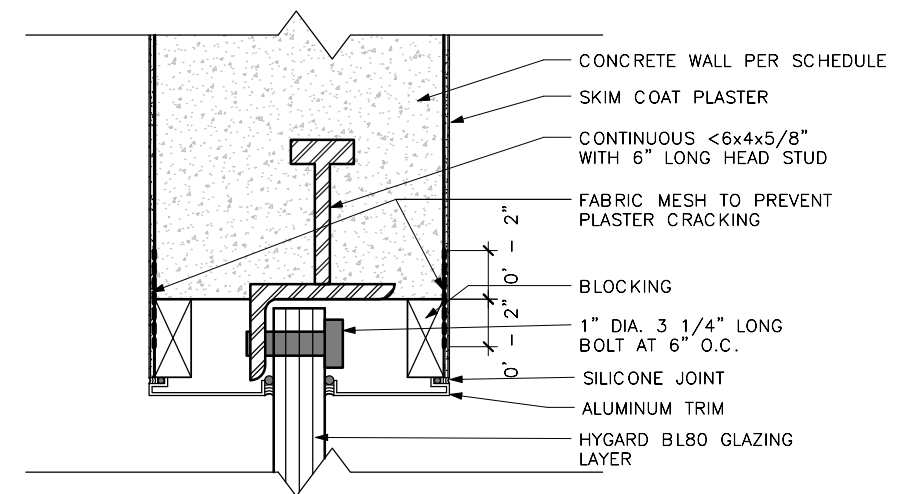


TYPICAL HYGARD
ANCHORAGE DETAIL
7
A6.2 SCALE (A)


SCALE (A)
2 0 2 4

SCALE (B)
6 3 0 6


DESIGNED: Designer A6.2	SUB SHEET NO. A6.2	TITLE OF SHEET WINDOW TYPES - INTERIOR 100% DRAFT CONSTRUCTION DOCUMENTS WASHINGTON MONUMENT NATIONAL MALL AND MEMORIAL PARKS	DRAWING NO. 807 101713A PMIS/PKG NO. NAMA 151073 SHEET 48 of 129
-------------------------------	-----------------------	--	---

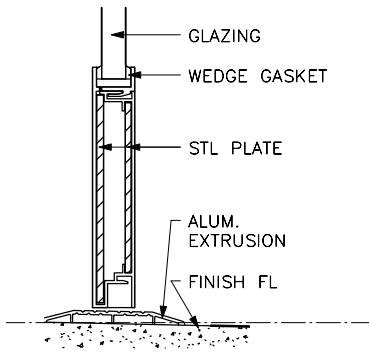


9 Door Threshold
A6.3 SCALE (B)

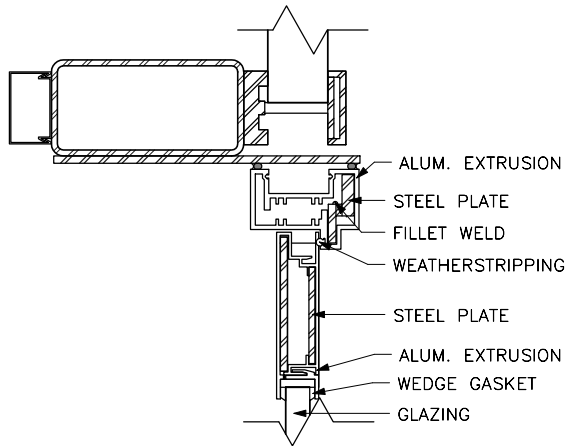


8 Door Head - CW
A6.3 SCALE (B)

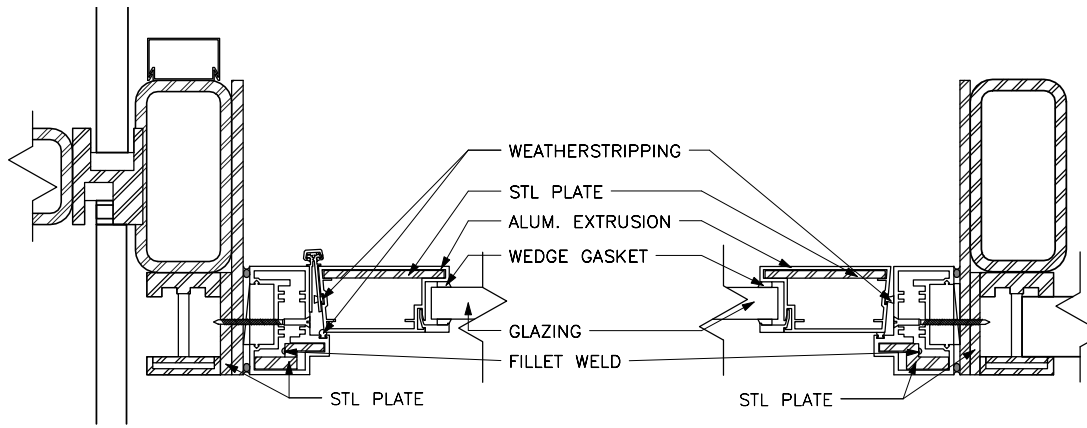


7 Door Jamb - CW Hinge
A6.3 SCALE (B)

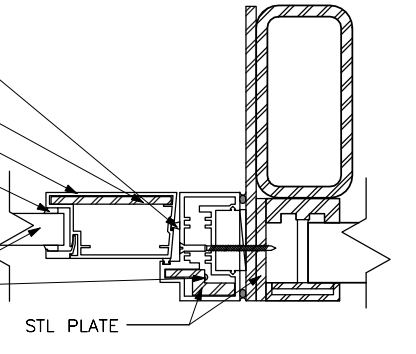


6 Door Jamb - CW Strike
A6.3 SCALE (B)

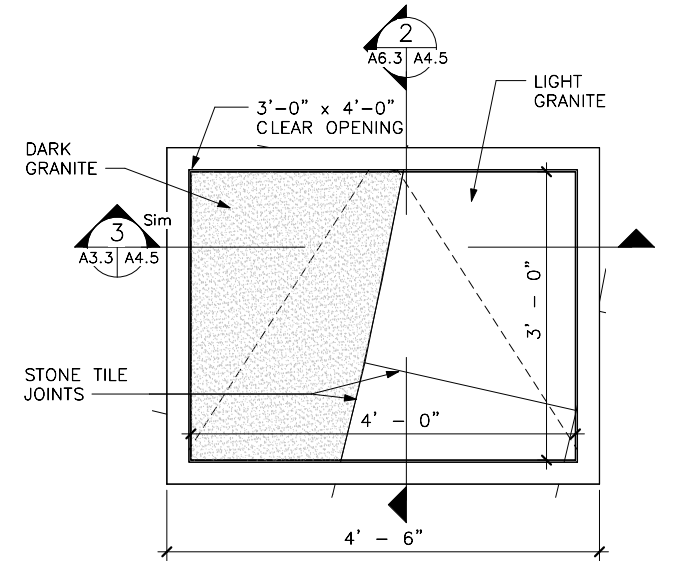


5 Floor Plan Detail -
Door 10
A6.3 SCALE (B)

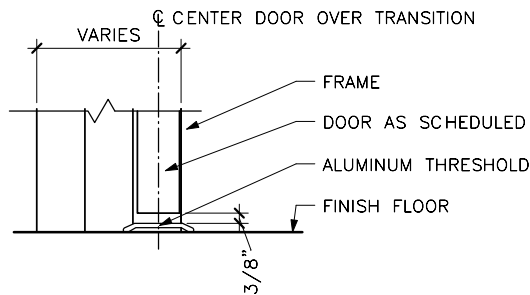


11 Metal Threshold
A6.3 SCALE (B)

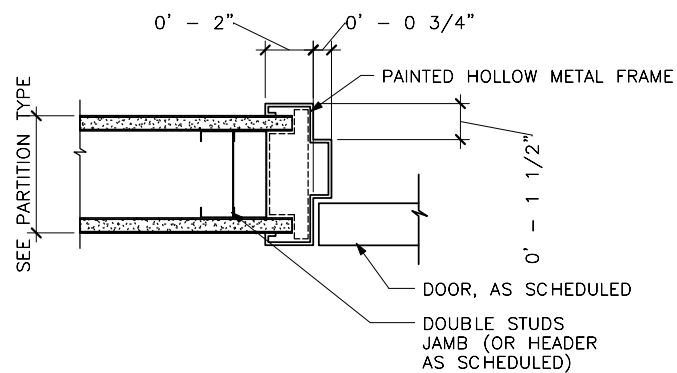


10 Typical HM Door Jamb
at GWB Wall (Head
Detail Similar)
A6.3 SCALE (B)

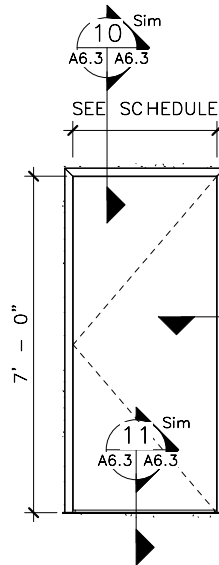


4 Door Elevations -
05, 09, 11
A6.3 SCALE (A)

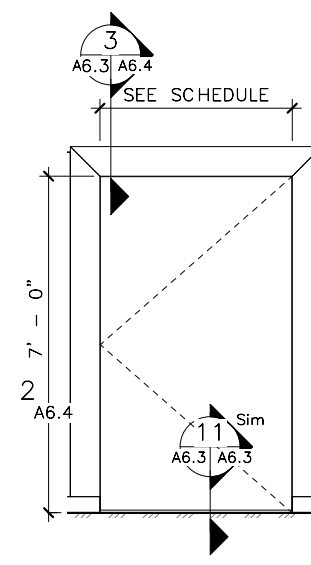

3 Door Elevations -
04, 06, 07
A6.3 SCALE (A)

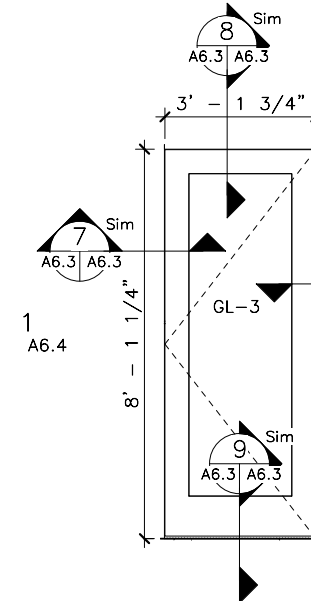


2 Door Elevations - 03
A6.3 SCALE (A)

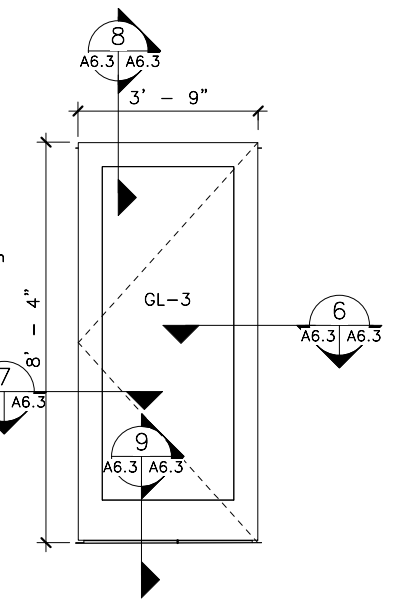


1 Door Elevations -
01, 02, 08
A6.3 SCALE (A)

DOOR SCHEDULE				
Door Tag	Opening Location	Width	Height	Rating
01	QUEUING	3' - 9"	8' - 4"	BALLISTIC RATED
02	EXIT HALLWAY	3' - 9"	8' - 4"	BALLISTIC RATED
03	QUEUING	3' - 1 7/8"	8' - 1 7/32"	BALLISTIC RATED
04	SECURE AREA	3' - 0"	7' - 0"	BLAST RATED
05	SECURITY OFFICE	3' - 0"	7' - 0"	-
06	SECURE AREA	4' - 0"	7' - 0"	BLAST RATED
07	SECURE AREA	4' - 0"	7' - 0"	BLAST RATED
08	EXIT HALLWAY	4' - 0"	8' - 0 15/32"	BALLISTIC RATED
09	RESTROOM	3' - 0"	7' - 0"	-
10	EXIT HALLWAY	3' - 6"	4' - 6"	-
11	MECHANICAL ROOM	3' - 6"	7' - 0"	-


GENERAL NOTES:
SEE SPECIFICATIONS FOR DOOR & FRAME
MATERIALS, BALLISTIC & BLAST RATINGS,
HARDWARE SCHEDULE.

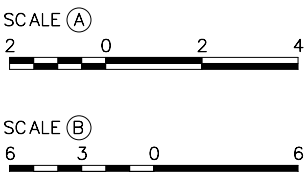


DESIGNED:	SUB SHEET NO.	TITLE OF SHEET	DRAWING NO.
LD	A6.3	DOOR TYPES	807
SA			101713A
TECH. REVIEW:			PMIS/PKG NO.
LD			NAMA
DATE:		100% DRAFT CONSTRUCTION DOCUMENTS	SHEET
12/30/2016		WASHINGTON MONUMENT	49 of 129
		NATIONAL MALL AND MEMORIAL PARKS	

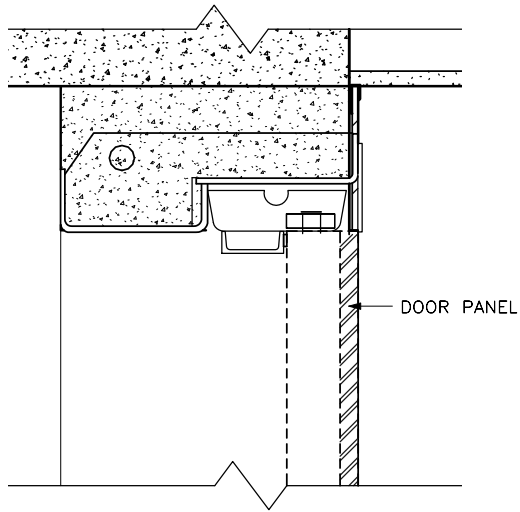


3 Door Head
A6.4 SCALE (A)

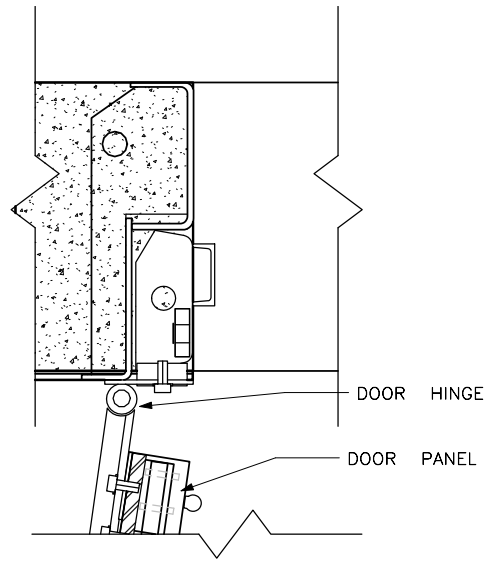


2 Door Jamb - Hinge
A6.4 SCALE (A)

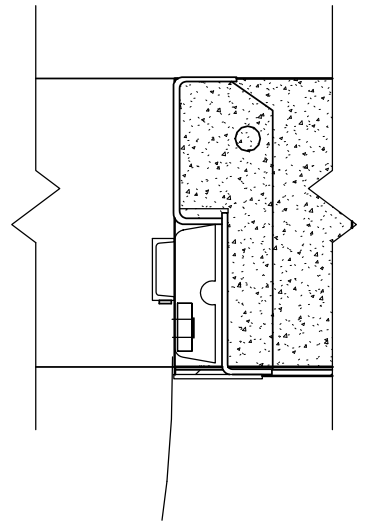

1 Door Jamb - Strike
A6.4 SCALE (A)

 


DESIGNED: LD	SUB SHEET NO. A6.4	TITLE OF SHEET DOOR DETAILS 100% DRAFT CONSTRUCTION DOCUMENTS WASHINGTON MONUMENT NATIONAL MALL AND MEMORIAL PARKS	DRAWING NO. 807
SA			101713A
TECH. REVIEW: LD			PMIS/PKG NO. NAMA 151073
DATE: 12/30/16			SHEET
			50 of 129

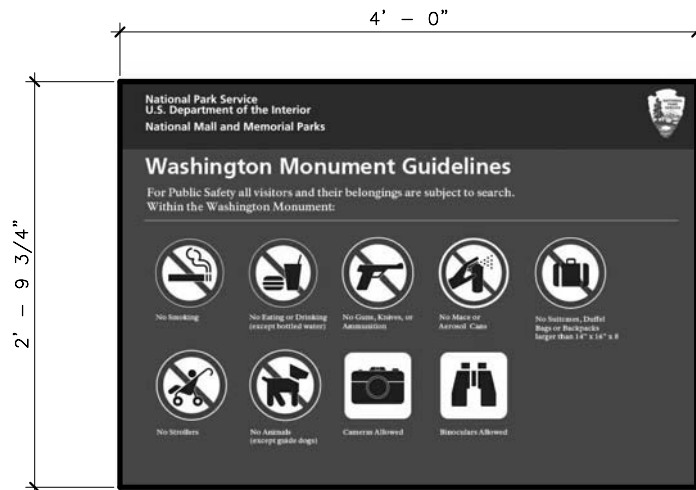


NOTE: EXISTING MONUMENT GUIDELINE SIGN TO BE RELOCATED TO NEW CONSTRUCTION.

1 Standard NPS Monument Guidelines
A7.1 SCALE (A)

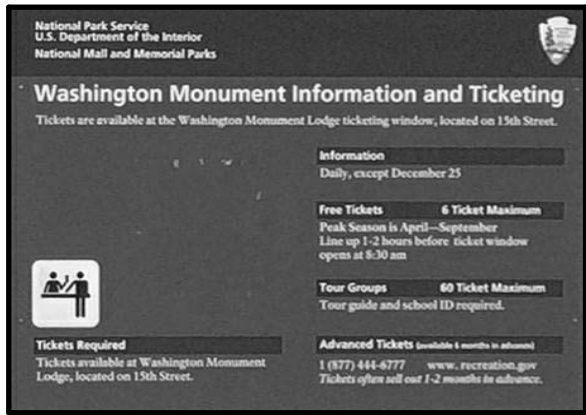


NOTE: EXISTING MONUMENT INFORMATION AND TICKETING SIGN TO BE RELOCATED TO NEW CONSTRUCTION.


2 Existing Monument Information and Ticketing Sign
A7.1 SCALE (A)

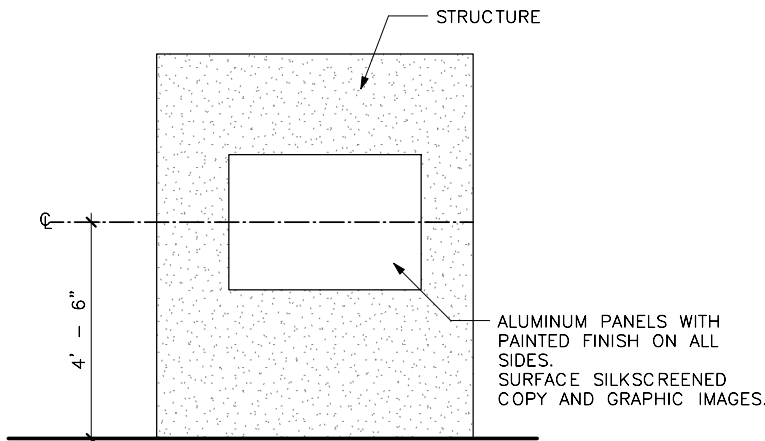

3 Sign Mounting Height
A7.1 SCALE (B)

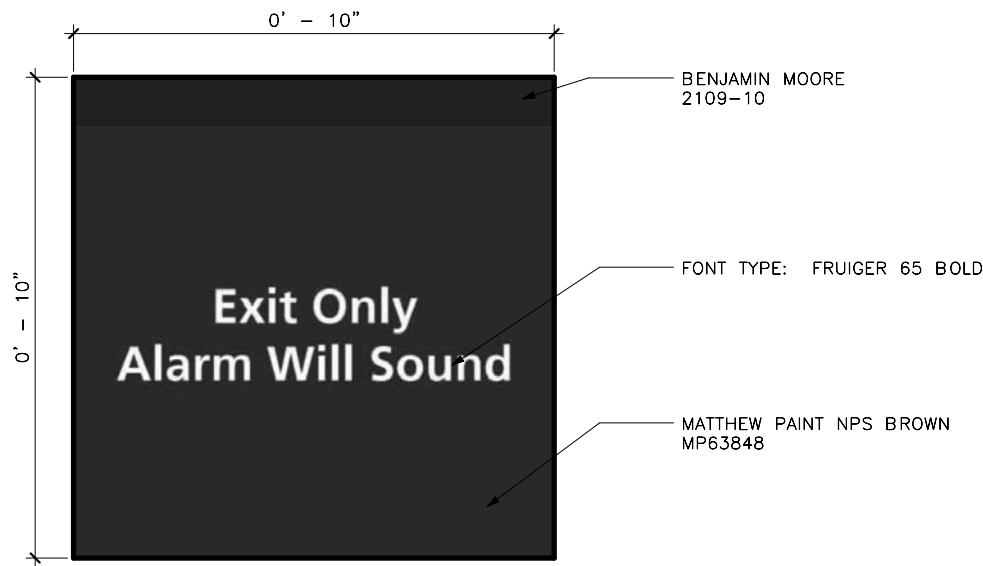

4 Exit Only Sign
A7.1 SCALE (A)

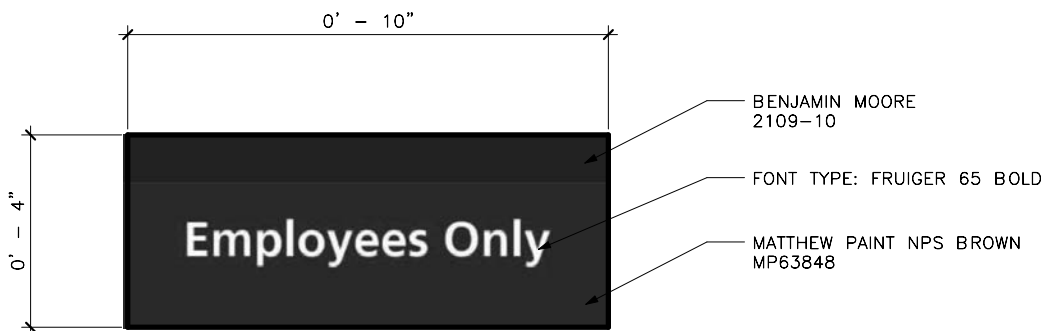

5 Employees Only Sign
A7.1 SCALE (A)

SCALE (A)
2 0 2 4
SCALE OF INCHES

SCALE (B)
2 0 2 4
SCALE OF FEET

DESIGNED:	SUB SHEET NO. A7.1	TITLE OF SHEET SIGNAGE 100% DRAFT CONSTRUCTION DOCUMENTS WASHINGTON MONUMENT NATIONAL MALL AND MEMORIAL PARKS	DRAWING NO.
LD			807
GOOD			101713A
AD			PMIS/PKG NO.
TECH. REVIEW:			NAMA
LD			151073
DATE:			SHEET
12/30/2016			51 of 129