
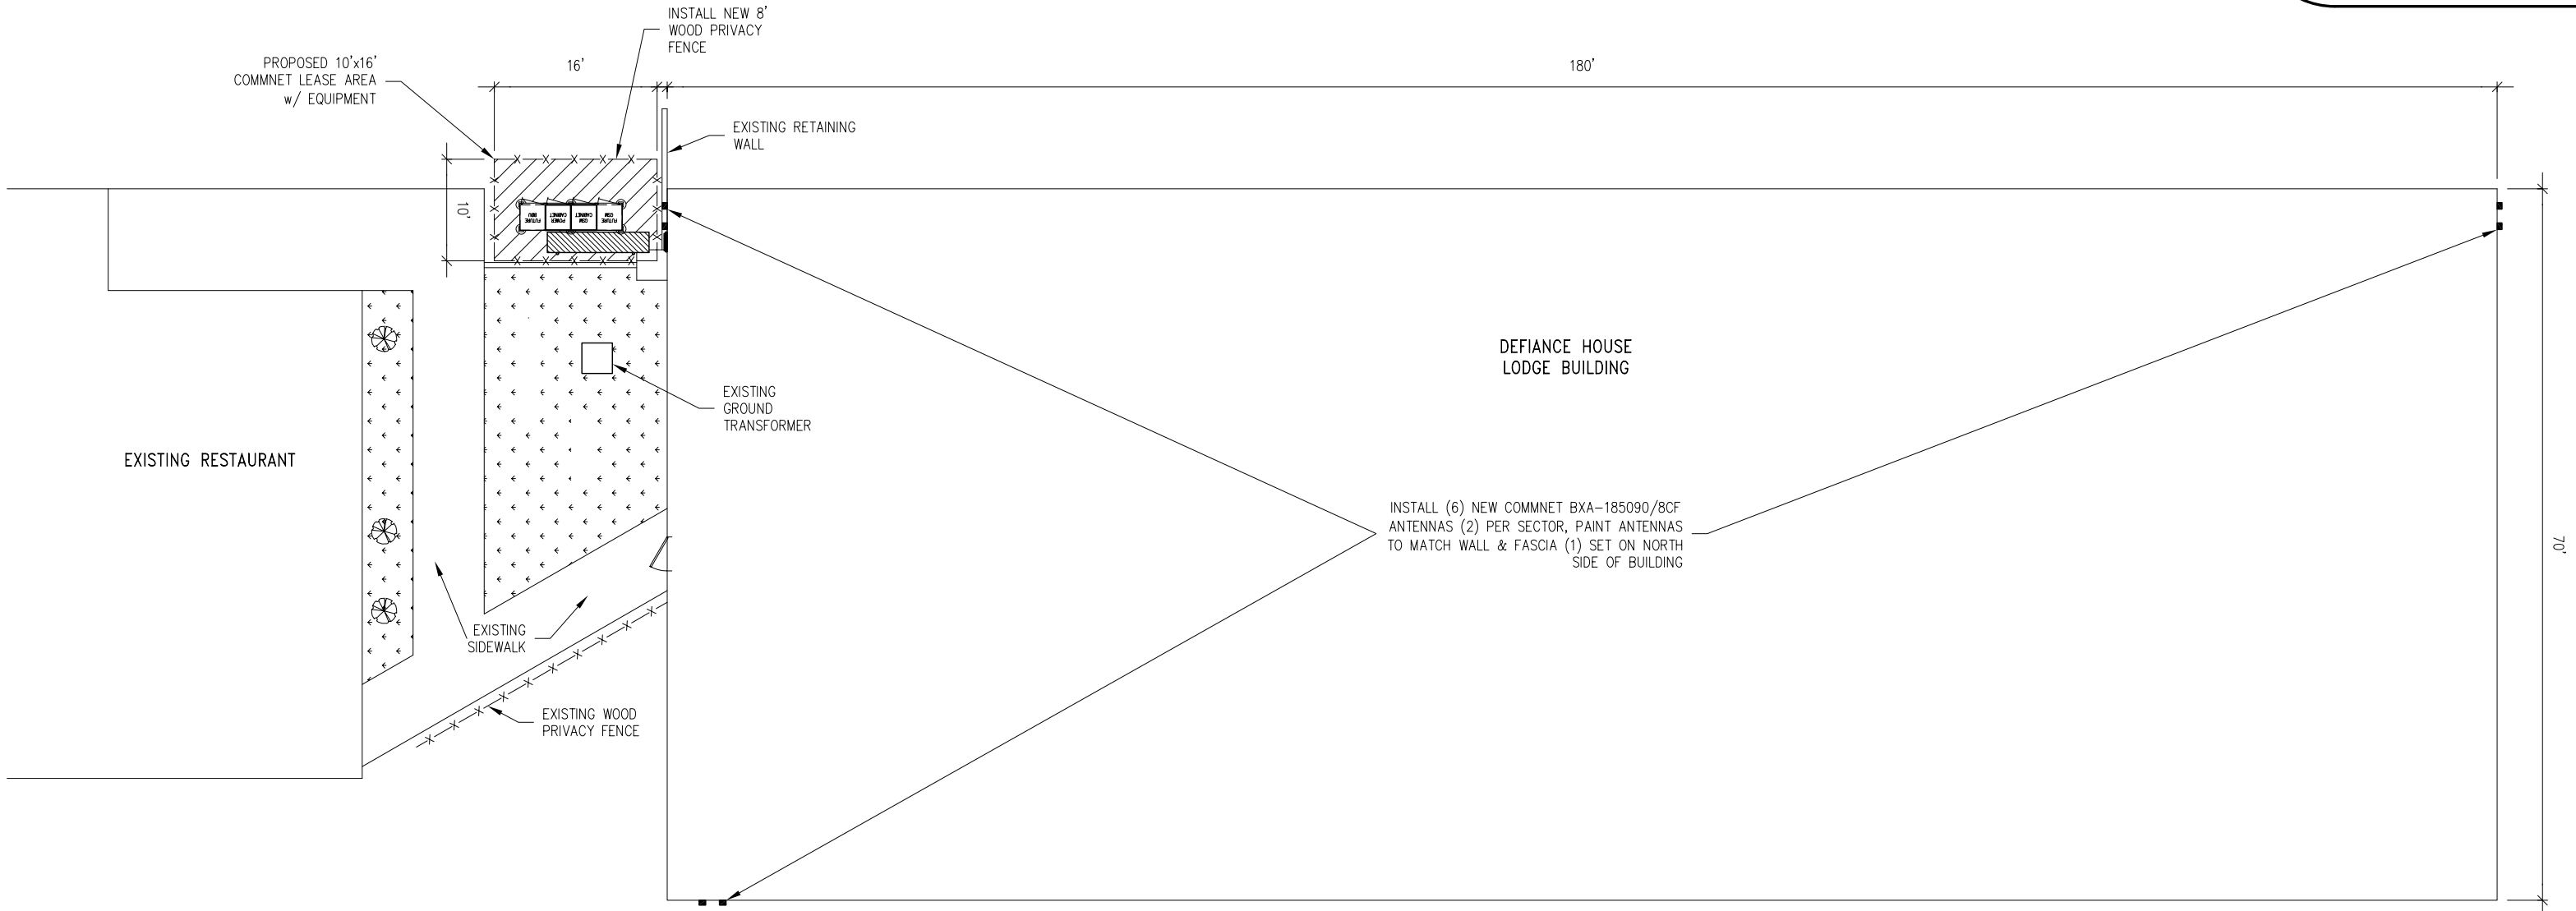


[illegible]

P.E. SEAL

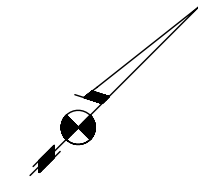

DWG BY: WBE	APRVD. BY:	 Commnet Wireless	PROJECT:	SHT. NAME: BULLFROG, UT SITE PLAN	A-2
DATE: 04/19/06	DATE:				
SCALE: 1/16"=1'-0"	DWG FILE:				

P.E. SEAL

DEFIANCE HOUSE
LODGE BUILDING

INSTALL (6) NEW COMMNET
BXA-185090/8CF ANTENNAS
(2) PER SECTOR, PAINT
ANTENNAS TO MATCH WALL &
FASCIA (1) SET ON NORTH
SIDE OF BUILDING

INSTALL COVERED COMMNET CABLE
LADDER ON SIDE OF BUILDING &
PAINT TO MATCH

EXISTING RETAINING WALL

INSTALL NEW 8' WOOD
PRIVACY FENCE

NEW 10'x16' LEASE AREA

SUPPORT SPECIALTY
MANUFACTURING 4-BAY RAILS
SYSTEM PART # LRFS-002
WITH 12" DIAMETER CASSIONS

FUTURE
GSM
CABINET
POWER
CABINET
FUTURE
BBU

EXISTING GROUND
TRANSFORMER

NEW COMMNET CABLE
TRAY IN LEASE AREA

EXISTING WOOD PRIVACY
FENCE

EXISTING SIDEWALK

EXISTING RESTAURANT

1

ENLARGED SITE PLAN

Scale: 1/8" = 1' - 0"



Commnet Wireless

PROJECT:

SHT. NAME:

BULLFROG, UT
ENLARGED SITE PLAN

A-3

DWG BY:

WBE

DATE:

04/19/06


SCALE:

1/8" = 1'-0"

APRVD. BY:

DATE:

DWG FILE:

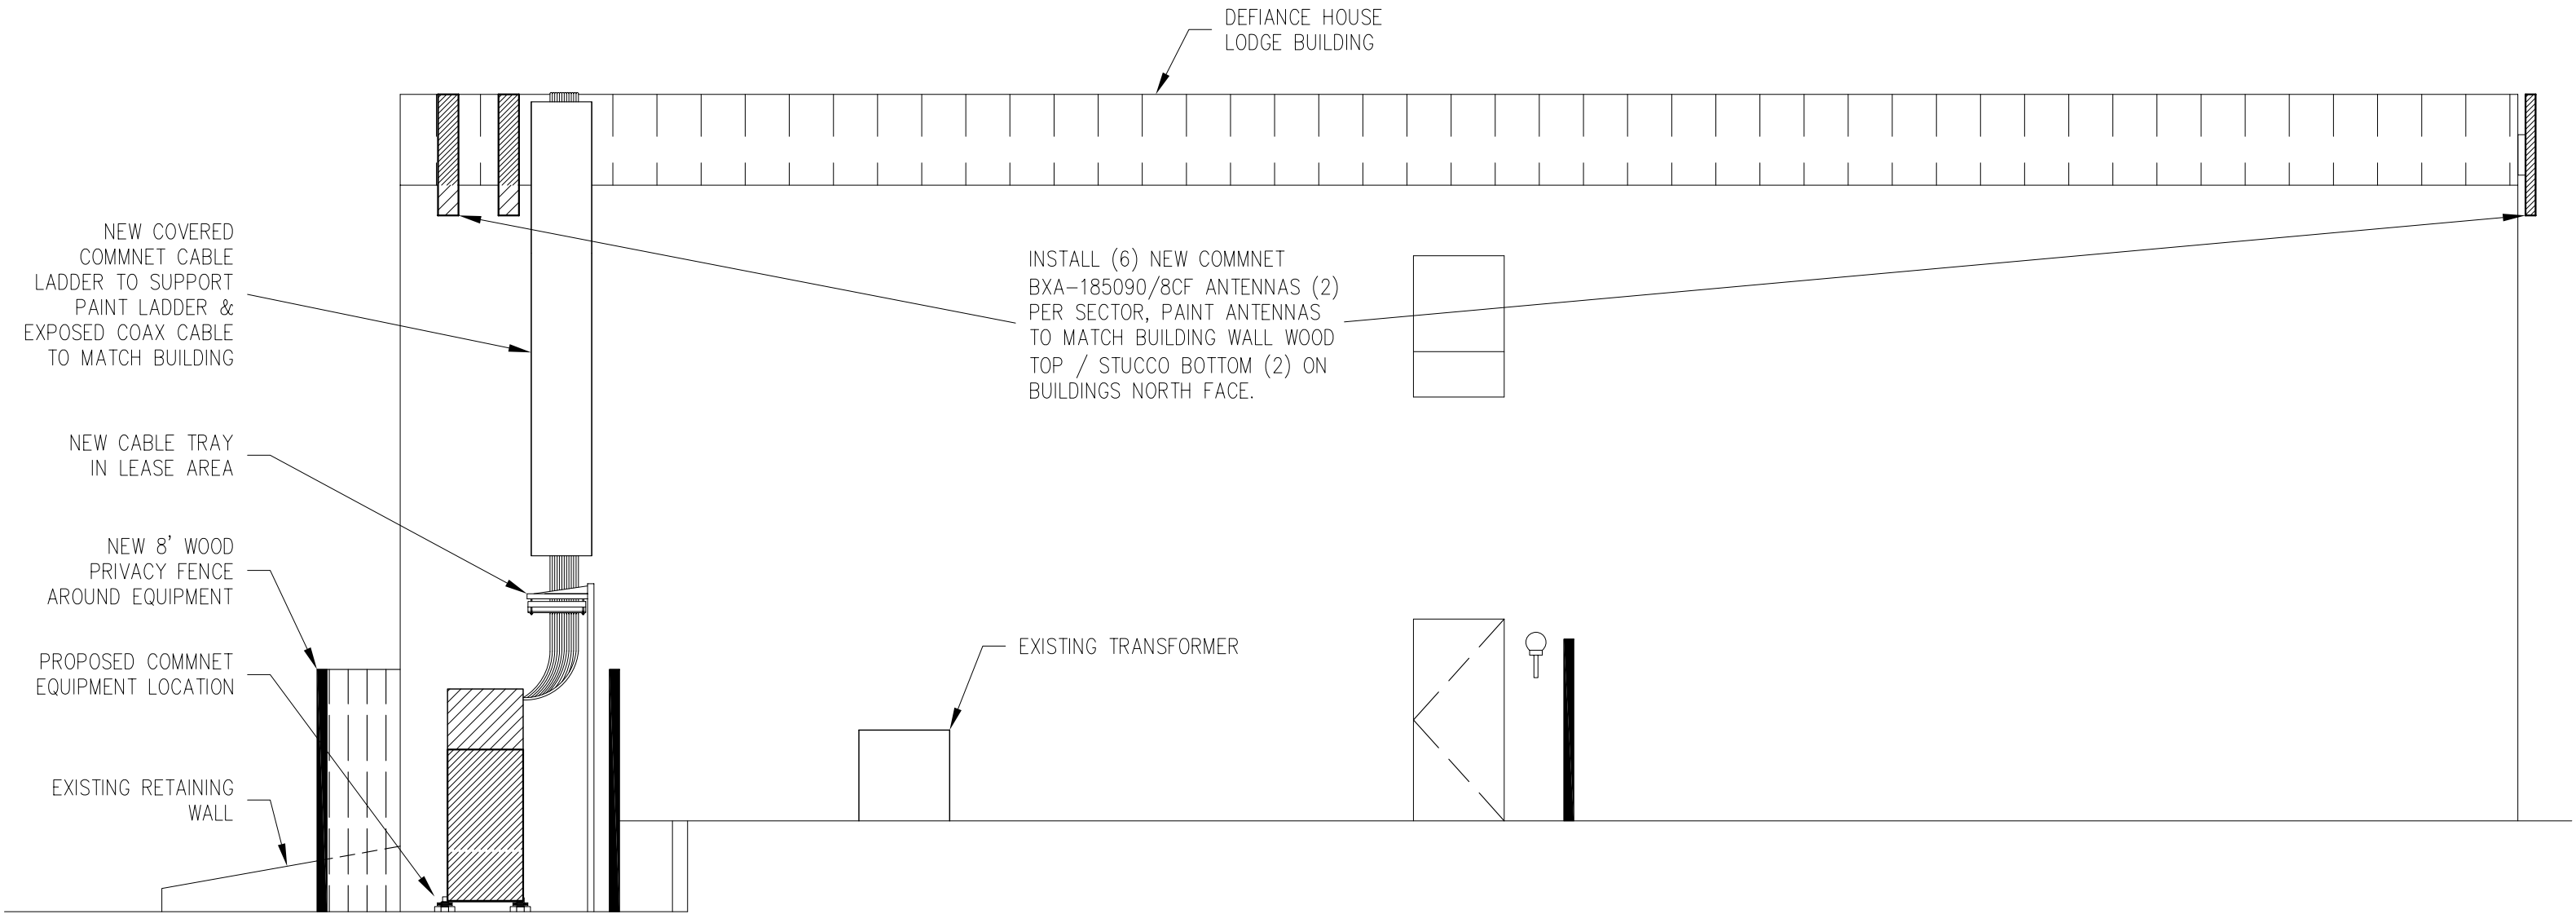

1 SOUTH BUILDING ELEV.
Scale: 3/16" = 1' - 0"