




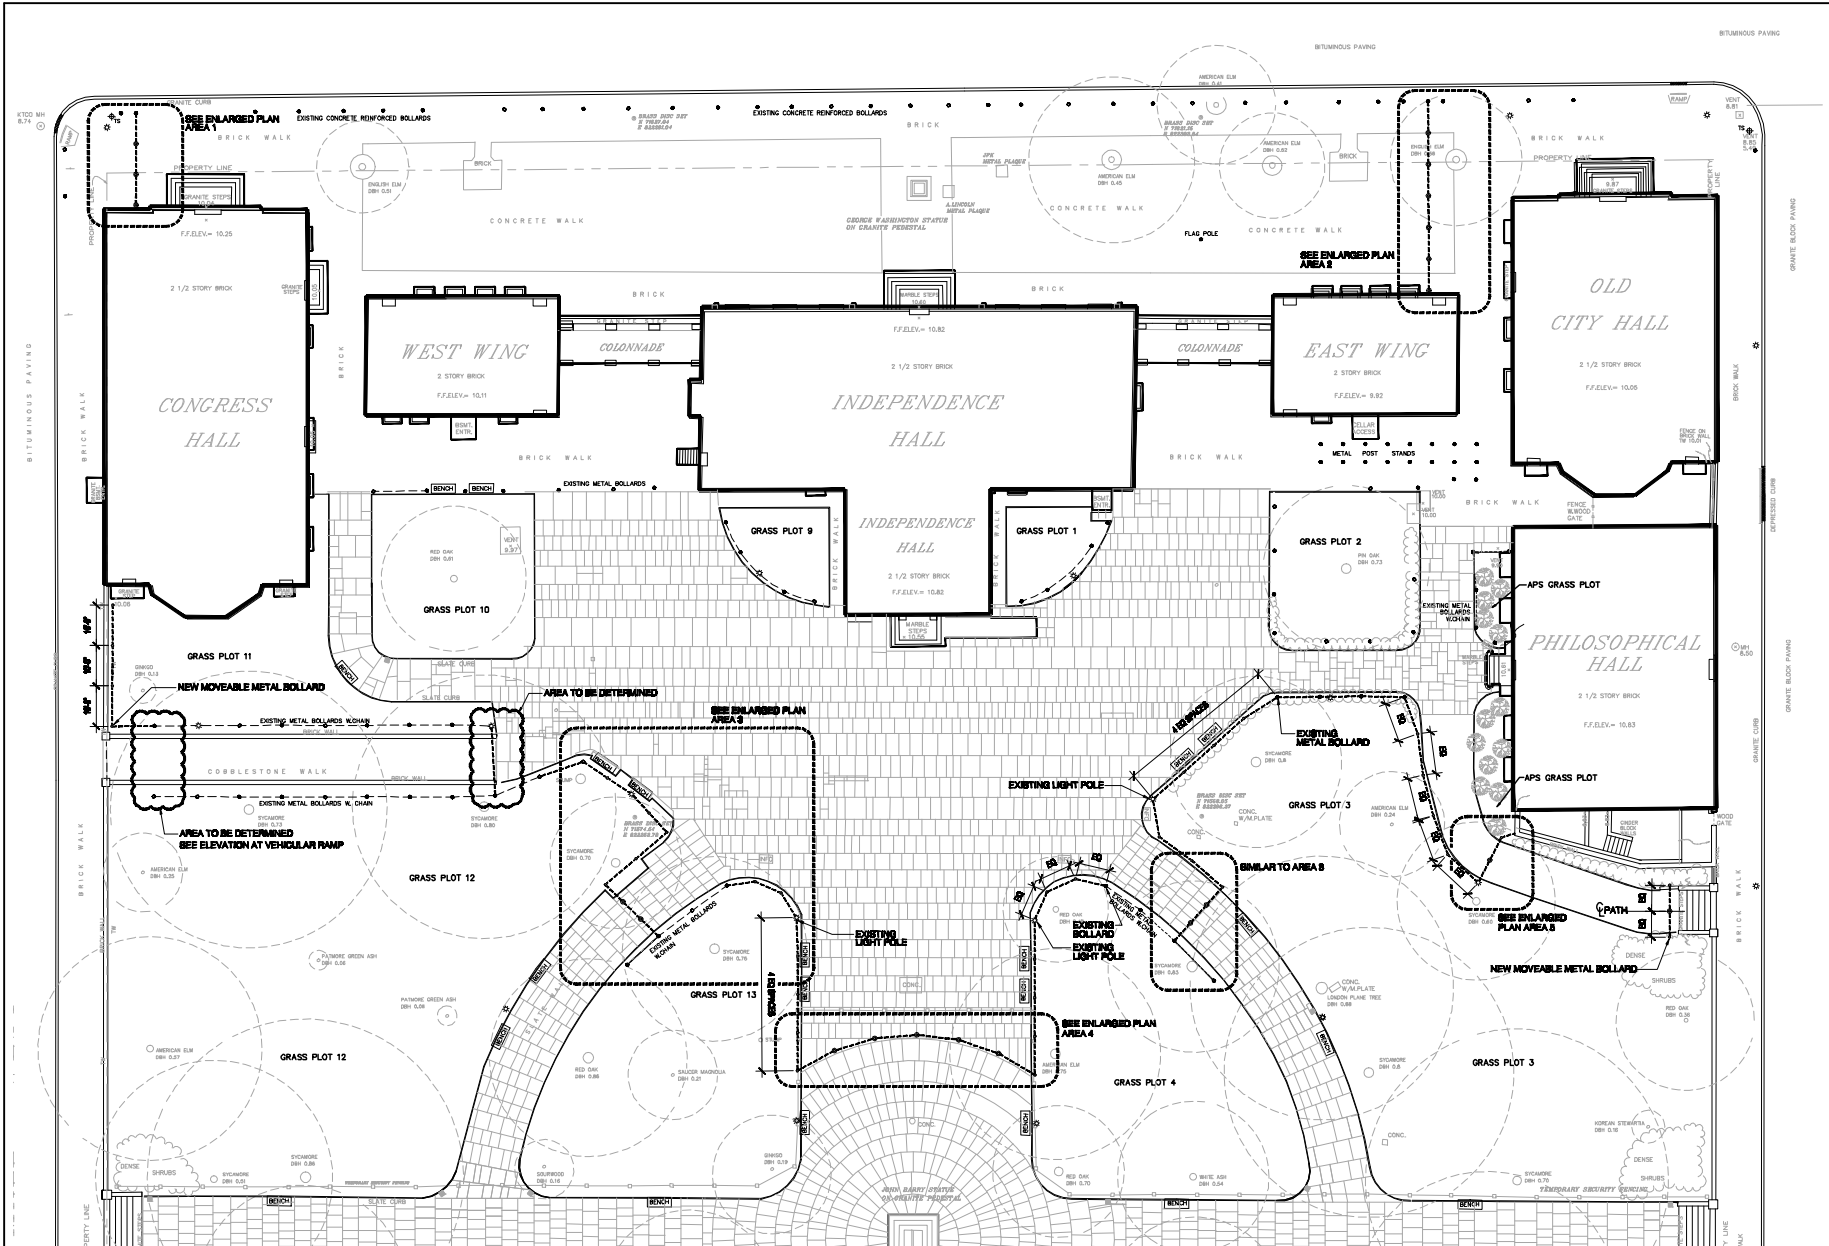


LAYOUT PLAN
SCALE 1"=200'-0"

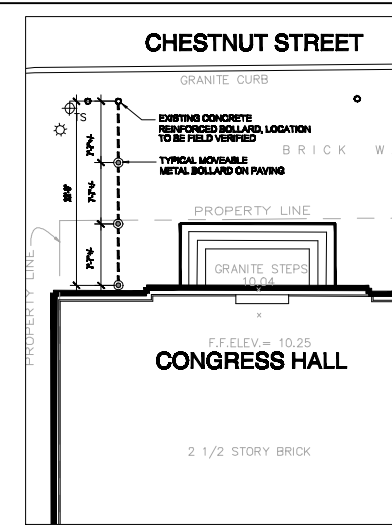


ENLARGED PLAN AREA 1
SCALE 1"=100'-0"

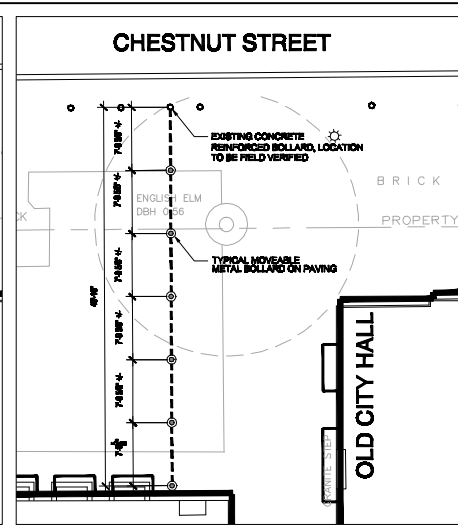


ENLARGED PLAN AREA 2
SCALE 1"=100'-0"

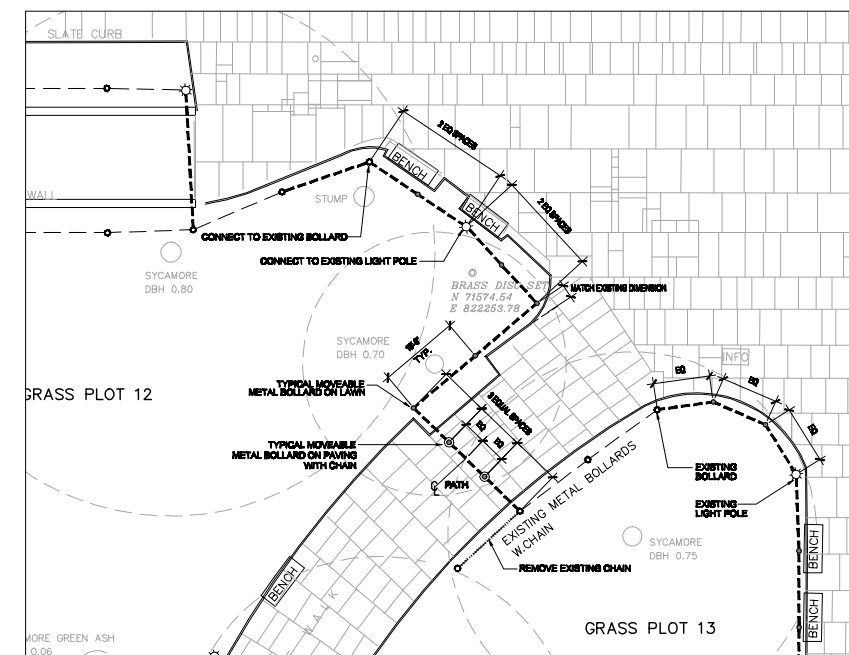

ENLARGED PLAN AREA 3
SCALE 1"=100'-0"

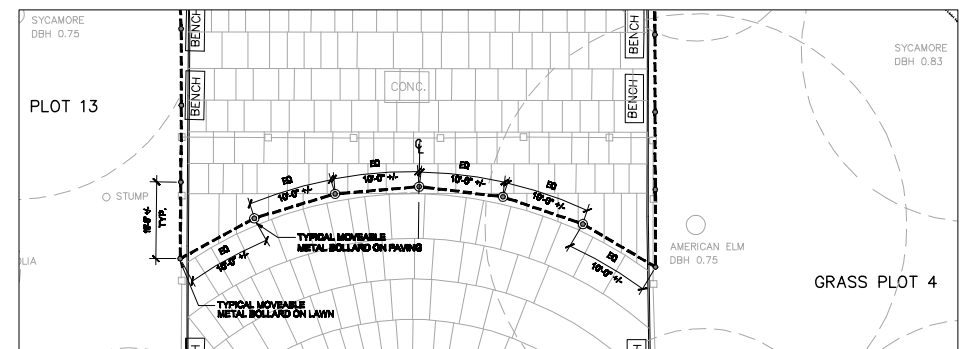


ENLARGED PLAN AREA 4
SCALE 1"=100'-0"

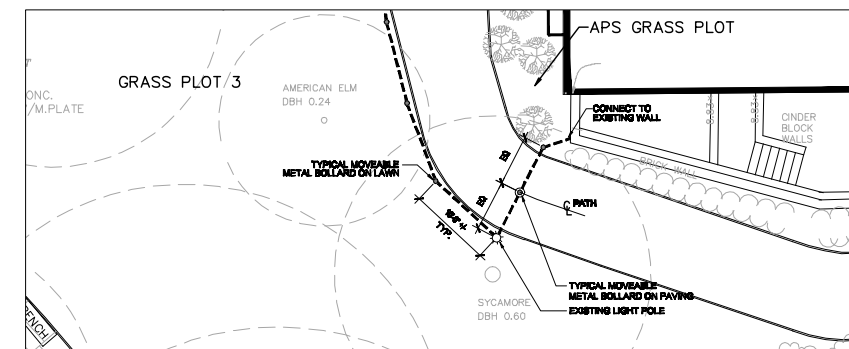

ENLARGED PLAN AREA 5
SCALE 1"=100'-0"

- LEGEND**
- EXISTING METAL BOLLARD
 - EXISTING CHAIN
 - EXISTING LIGHT POLE
 - NEW METAL BOLLARD
 - NEW MOVEABLE METAL BOLLARD
 - NEW CHAIN
 - REMOVED EXISTING CHAIN
 - EQUAL DISTANCE

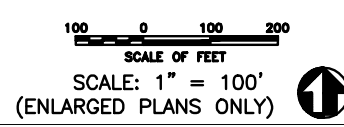

INDEPENDENCE SQUARE SECURITY PLAN
INDEPENDENCE NATIONAL HISTORICAL PARK
WORLD HERITAGE SITE

DESIGNED: CADD: TECH. REVIEW: DATE:	SUB SHEET NO. LA1.00	TITLE OF SHEET SECURITY BOLLARD LAYOUT PLAN	DRAWING NO.
1/22/07		INDEPENDENCE NATIONAL HISTORICAL PARK	